



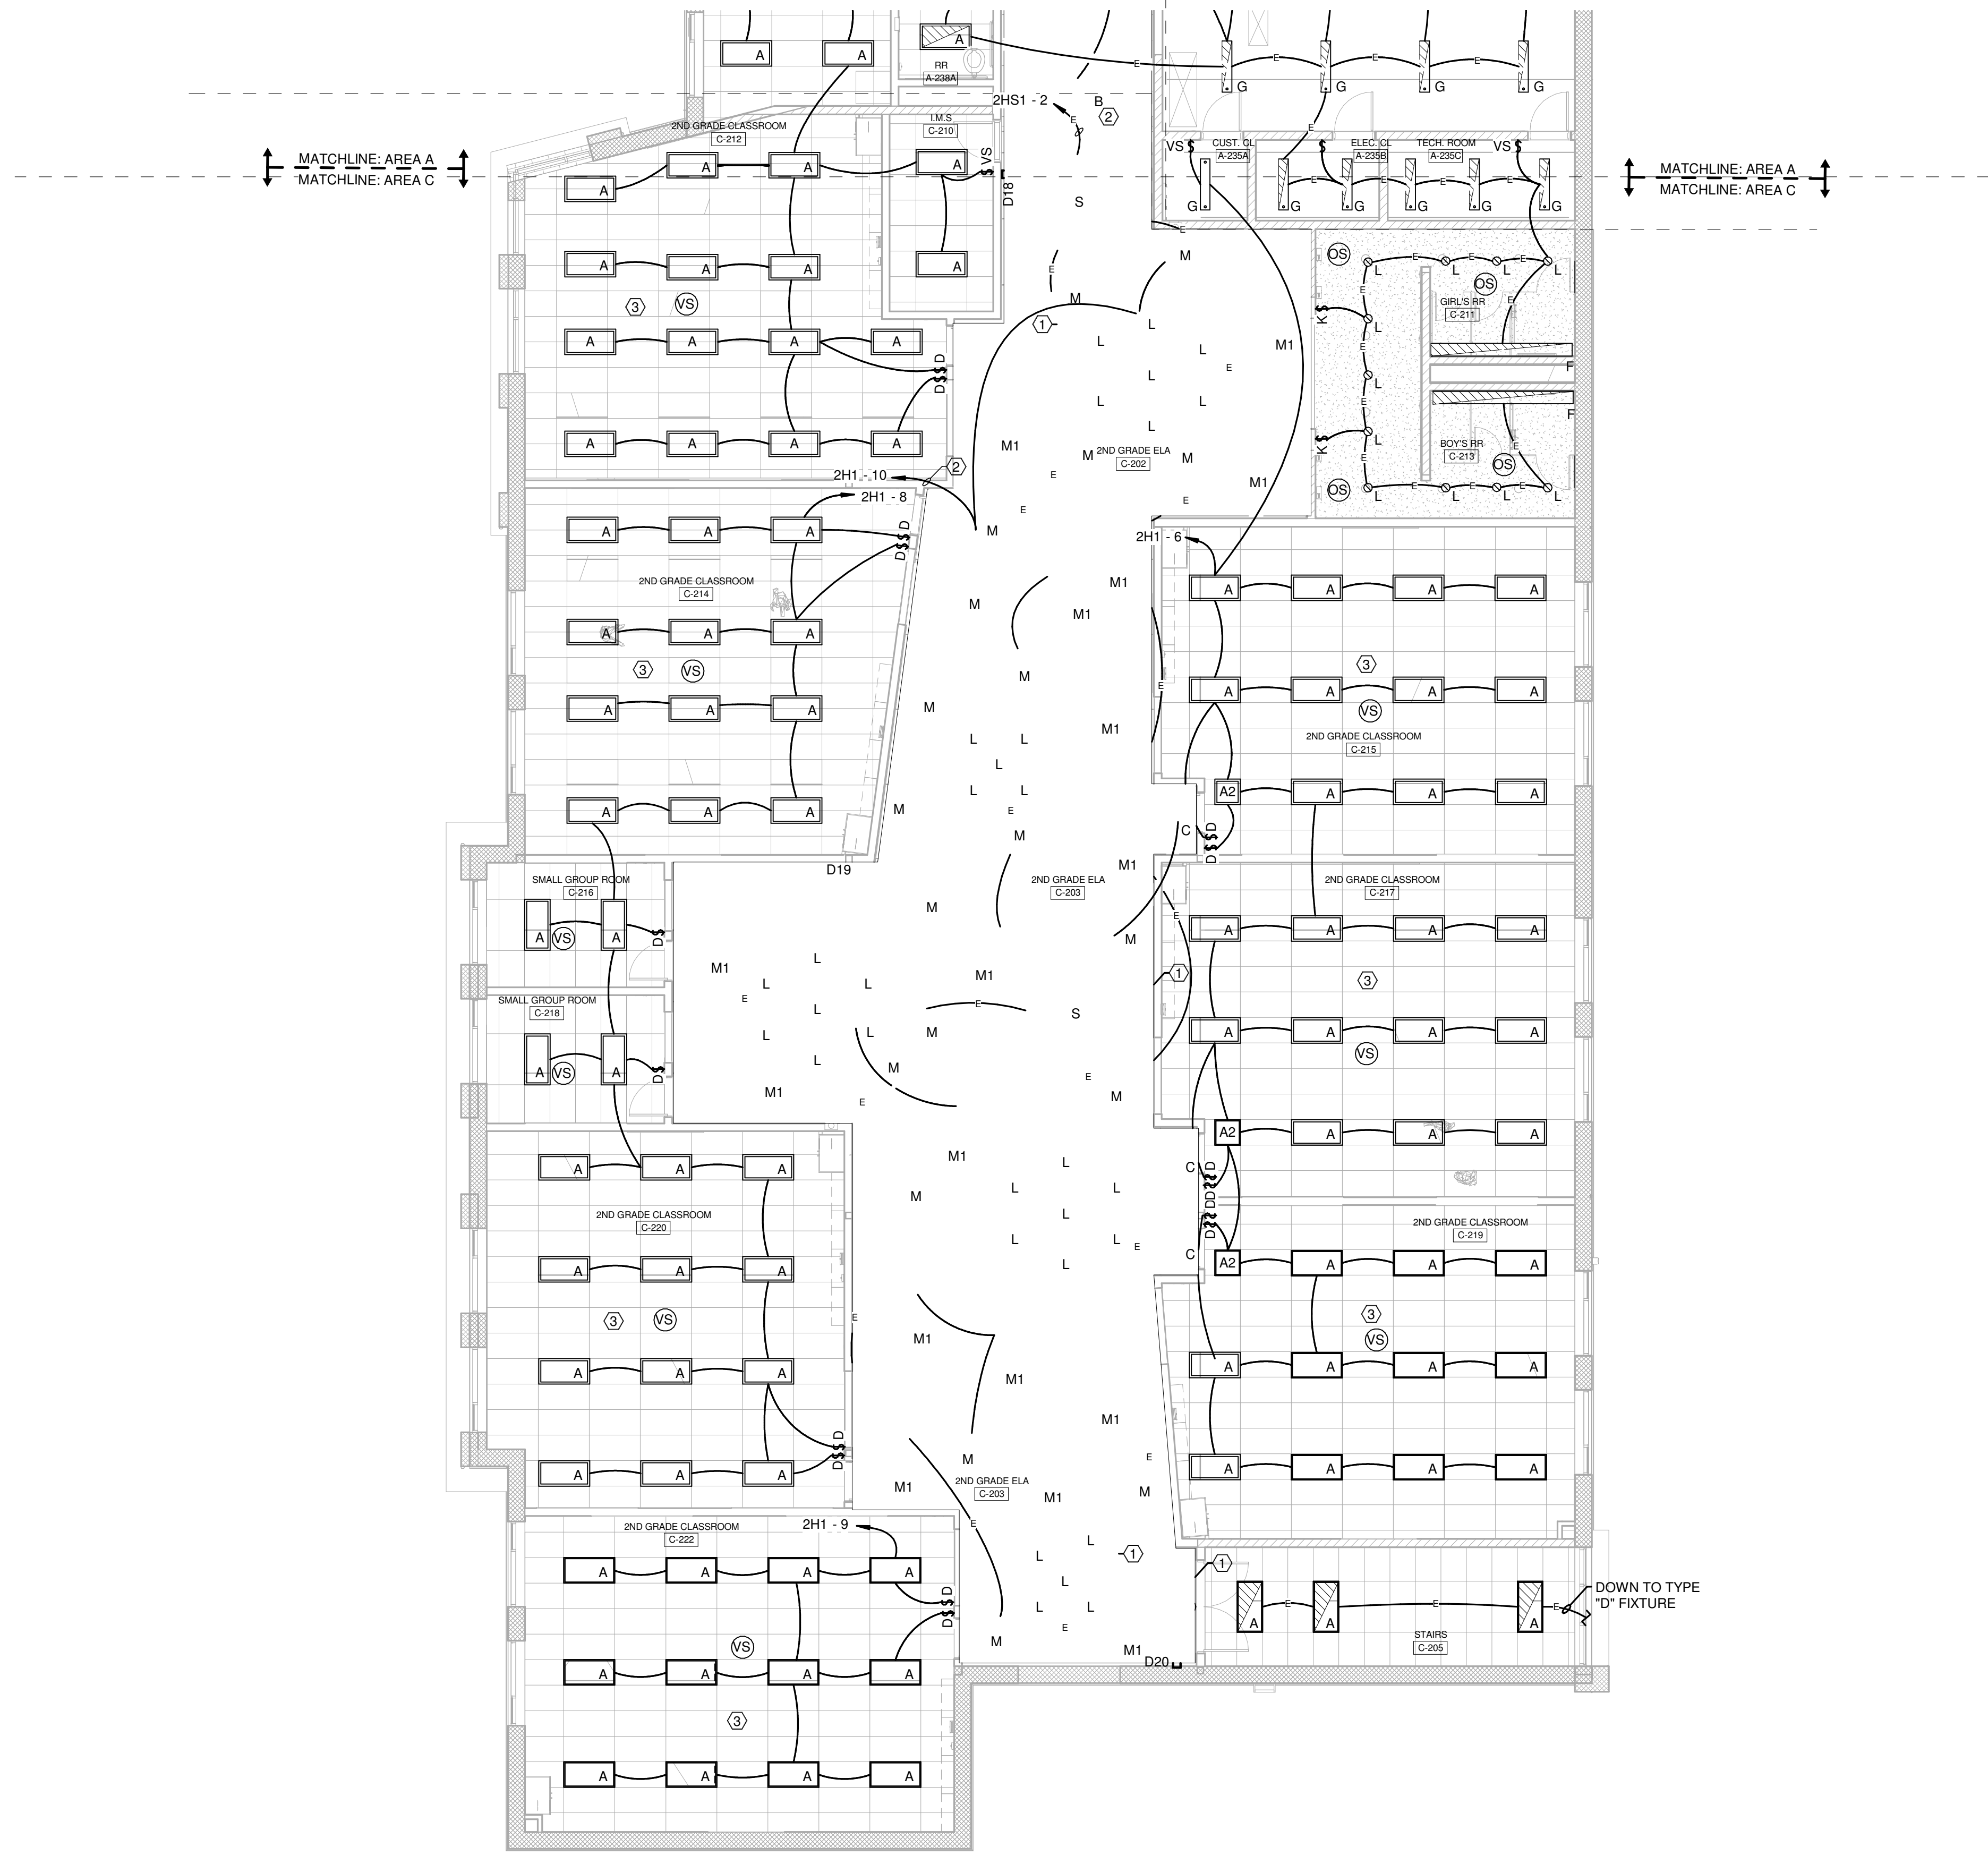

SECOND FLOOR PLAN - LIGHTING - UNIT C
SCALE: 1/8" = 1'-0"

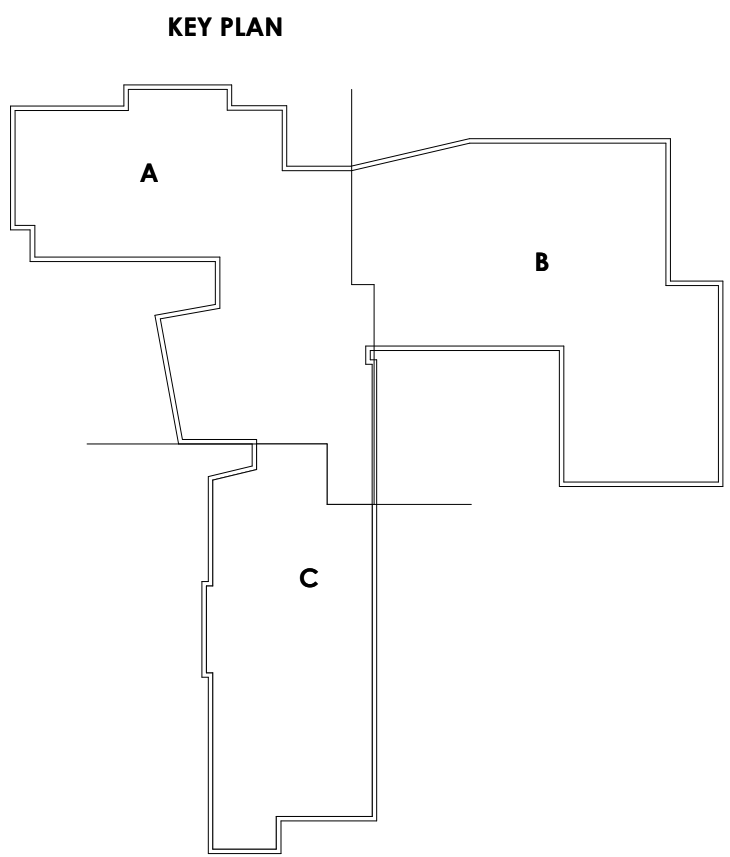

- Hex Notes**
- ① CONNECT TO RESPECTIVE ROOM EMERGENCY LIGHTING CIRCUIT AHEAD OF ALL SWITCHING/RELAYS.
 - ③ PROVIDE DUAL LEVEL DIMMING IN THIS ROOM. ONE DIMMER SHALL CONTROL THE ROW OF LIGHT FIXTURES AT THE TEACHING WALL. THE OTHER DIMMER SWITCH SHALL CONTROL ALL OF THE OTHER LIGHT FIXTURES IN THE ROOM.

PROJECT NO
2203-1

ARCHITECTURAL VISION GROUP, LTD
ARCHITECTS
23850 SPERRY DRIVE
CLEVELAND, OHIO 44145

MASSILLON CITY SCHOOL
MASSILLON WEST ELEMENTARY
PK-3
250 29TH STREET NW, MASSILLON, OHIO 44646

DATE	ISSUED AS	DESCRIPTION
07/12/23	ISSUED AS	07/12/23

PROJECT NO 2203-1
DRAWN BY WAM
CHECKED BY TJC
DATE 07/12/23

SECOND FLOOR
PLAN - LIGHTING
- UNIT C

SCALE: 1/8" = 1'-0"
SHEET NO
E-102-C