




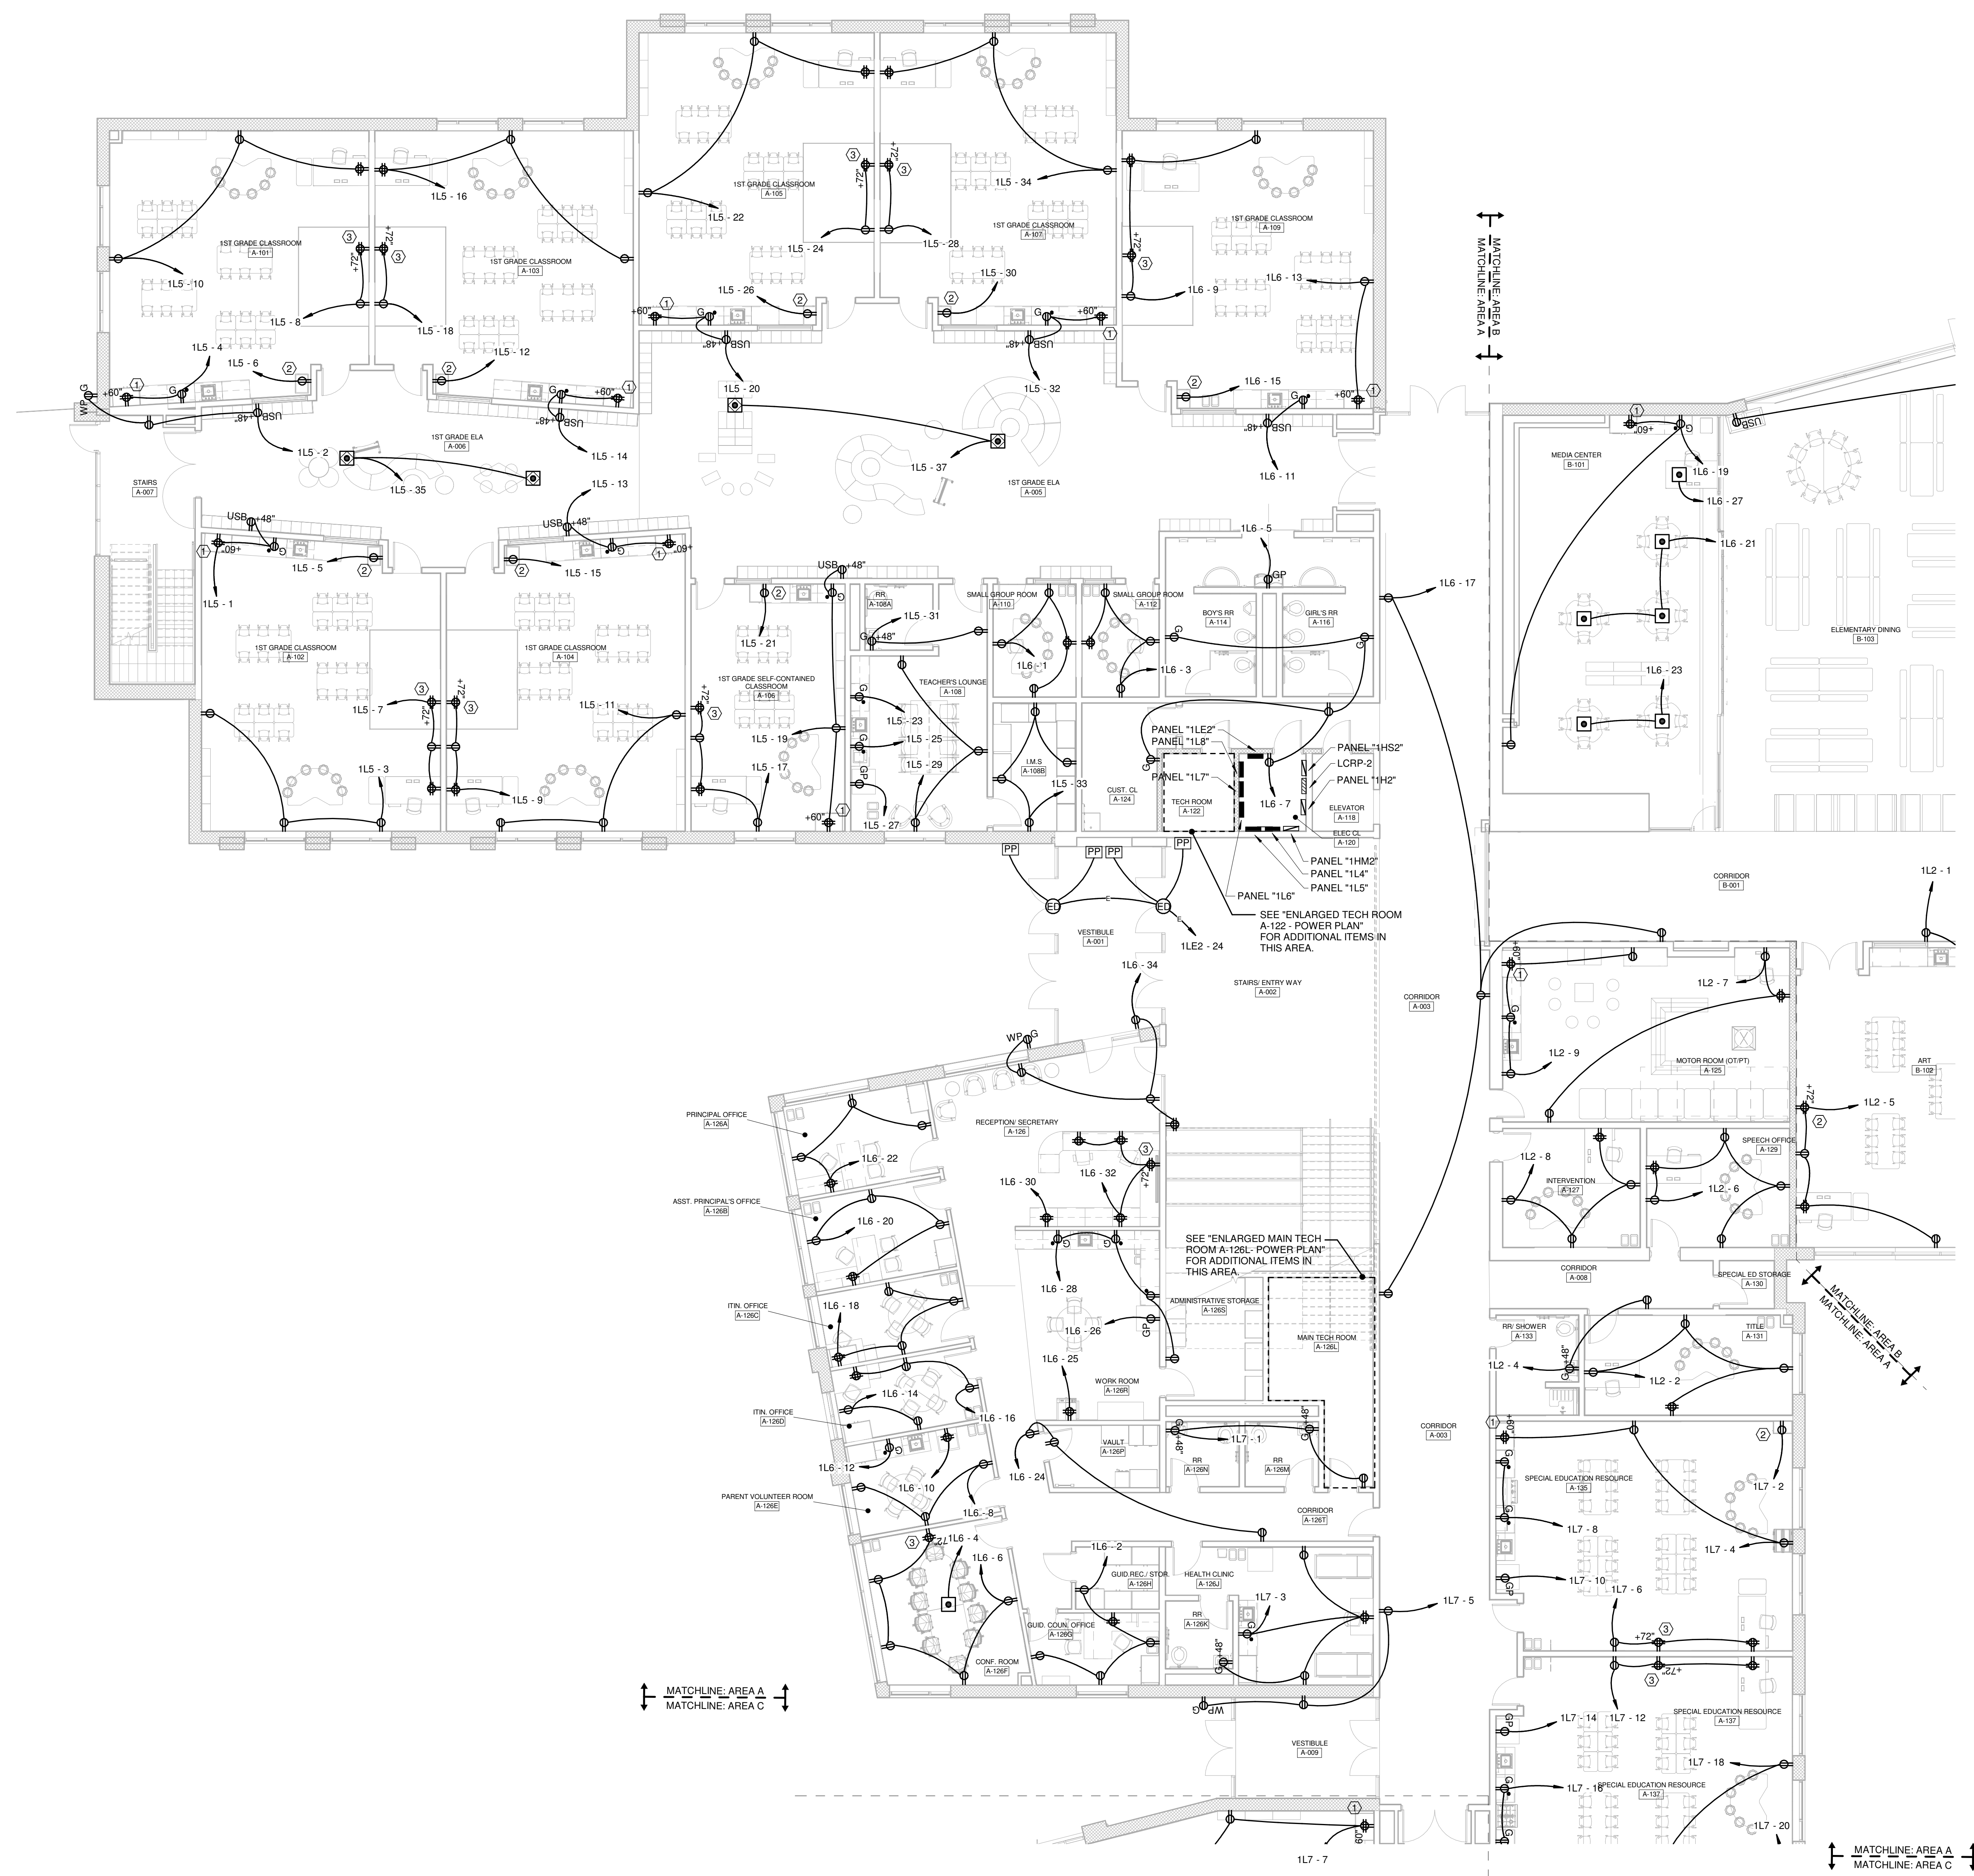

FIRST FLOOR PLAN - POWER - UNIT A
SCALE: 1/8" = 1'-0"

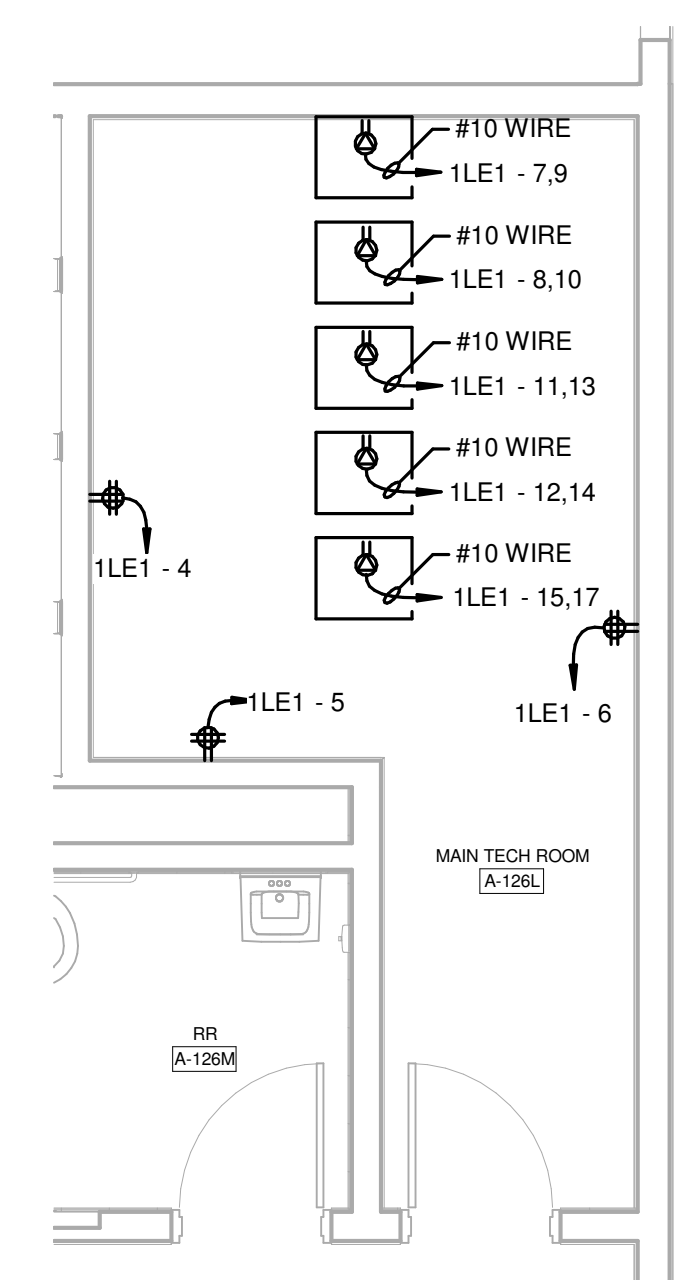


ENLARGED MAIN TECH ROOM A-126L
SCALE: 1/4" = 1'-0"

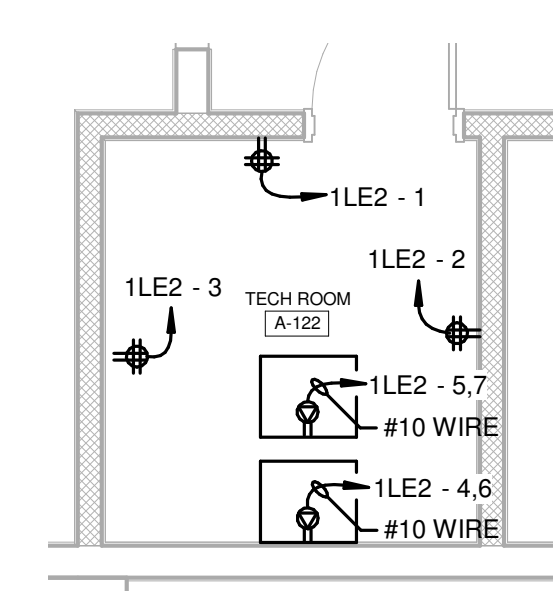

ENLARGED TECH ROOM A-122 - POWER
SCALE: 1/4" = 1'-0"


Hex Notes

- ① MOUNT INSIDE TEACHERS CABINET AT APPROXIMATELY 60" AFF. COORDINATE LOCATION.
- ② RECEPTACLE FOR CHARGING CARTS. VERIFY EXACT LOCATION PRIOR TO ROUGH-IN.
- ③ RECEPTACLE FOR WALL MOUNTED TELEVISION. VERIFY EXACT HEIGHT AND LOCATION PRIOR TO ROUGH-IN SO THAT RECEPTACLE IS HIDDEN BEHIND TELEVISION.

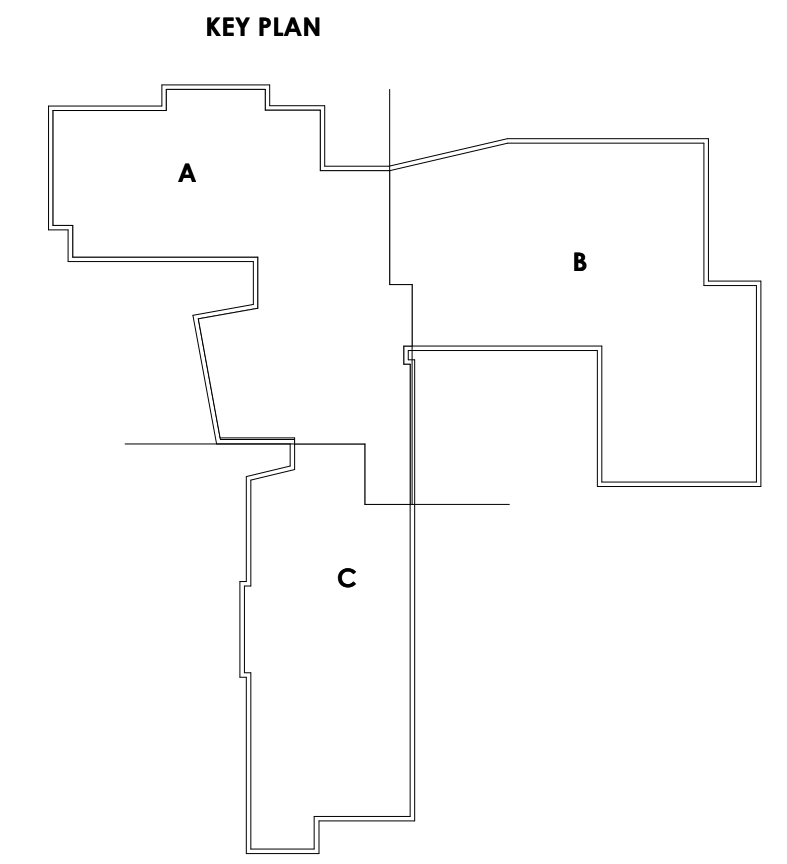

PROJECT NO
2203-1

ARCHITECTURAL VISION GROUP, LTD
PLANNERS
ARCHITECTS
23850 SPERRY DRIVE
CLEVELAND, OHIO 44145

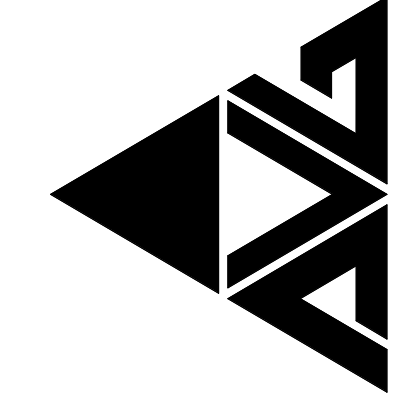

MASSILLON CITY SCHOOL
MASSILLON WEST ELEMENTARY
PK-3
250 29TH STREET NW, MASSILLON, OHIO 44646

PROJECT NO	2203-1
DRAWN BY	KVE
CHECKED BY	TJK
DATE	07/12/23

DATE	07/12/23
ISSUED BY	ISSUED AS

FIRST FLOOR
PLAN - POWER -
UNIT A

SCALE: As indicated
SHEET NO
E-201-A