


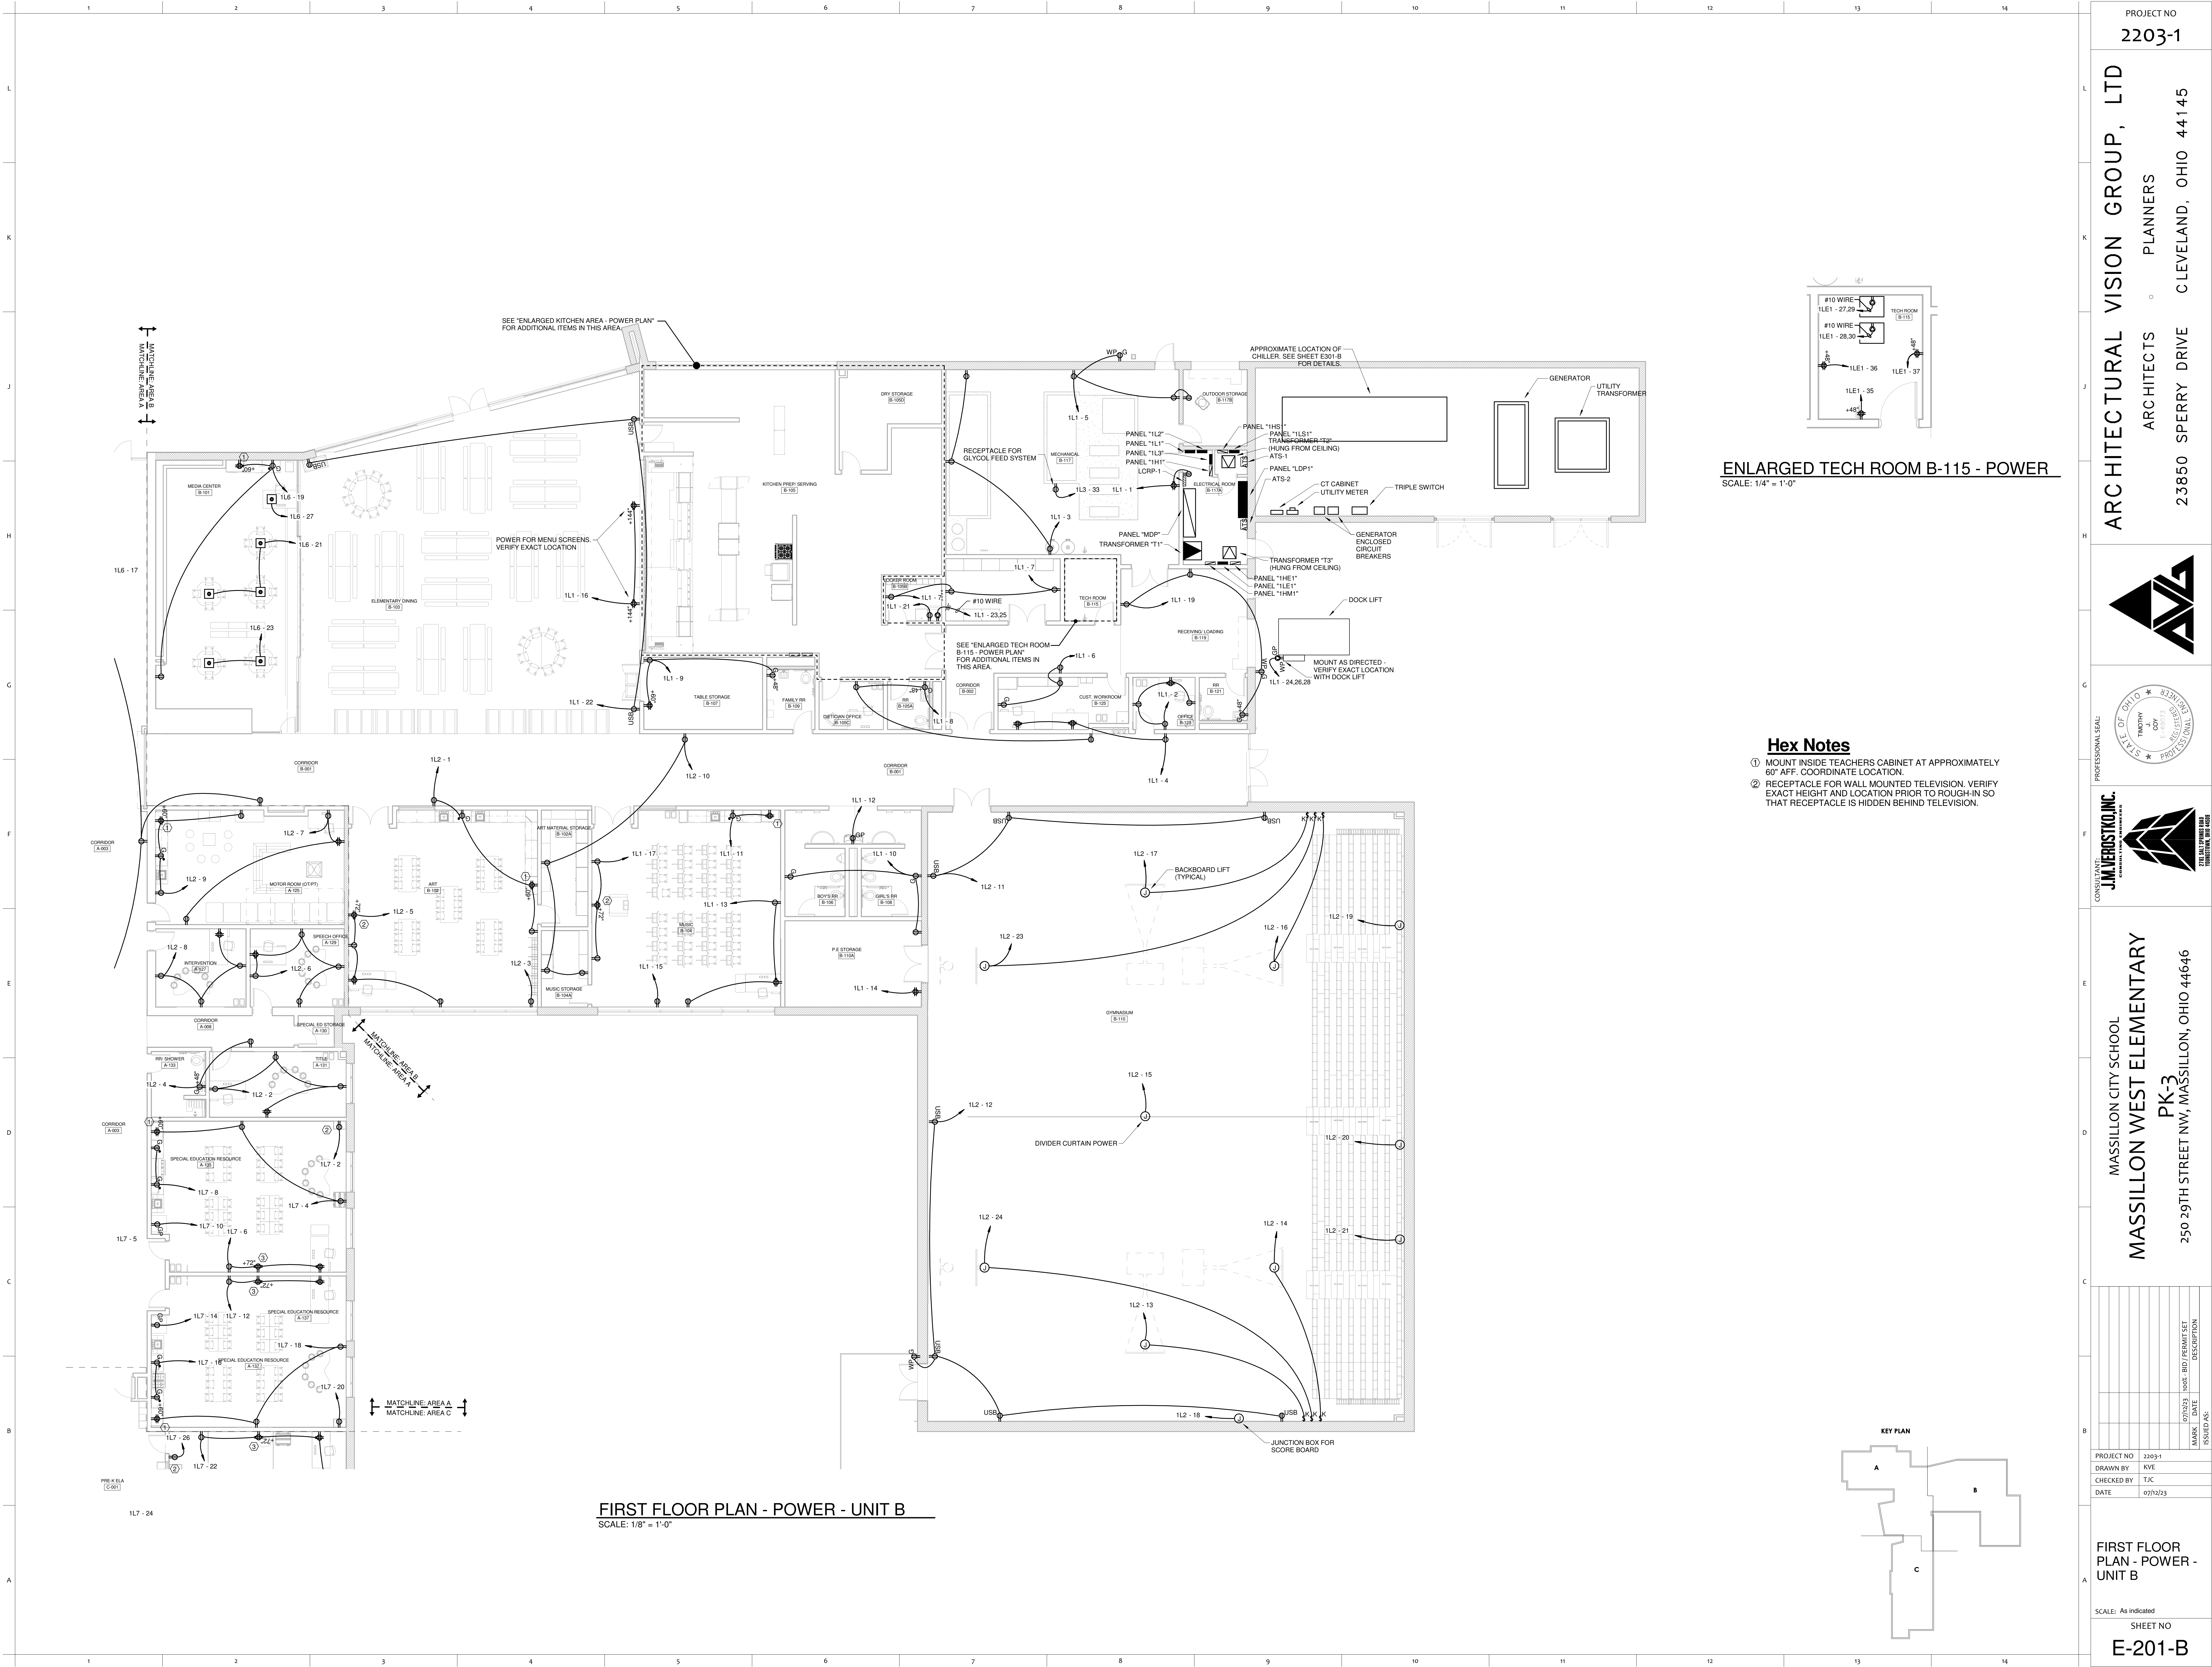

FIRST FLOOR PLAN - POWER - UNIT B
SCALE: 1/8" = 1'-0"

ENLARGED TECH ROOM B-115 - POWER
SCALE: 1/4" = 1'-0"

Hex Notes

① MOUNT INSIDE TEACHERS CABINET AT APPROXIMATELY 60" AFF. COORDINATE LOCATION.

② RECEPTACLE FOR WALL MOUNTED TELEVISION. VERIFY EXACT HEIGHT AND LOCATION PRIOR TO ROUGH-IN SO THAT RECEPTACLE IS HIDDEN BEHIND TELEVISION.

PROJECT NO
2203-1

ARCHITECTURAL VISION GROUP, LTD
ARCHITECTS
PLANNERS
CLEVELAND, OHIO 44145
23850 SPERRY DRIVE

MASSILLON CITY SCHOOL
MASSILLON WEST ELEMENTARY
PK-3
250 29TH STREET NW, MASSILLON, OHIO 44646

DATE	ISSUED AS	DESCRIPTION
07/12/23	ISSUED AS	ISSUED AS

PROJECT NO 2203-1
DRAWN BY KVE
CHECKED BY TJC
DATE 07/12/23

FIRST FLOOR
PLAN - POWER -
UNIT B

SCALE: As indicated
SHEET NO
E-201-B