



SECOND FLOOR PLAN - POWER - UNIT A
SCALE: 1/8" = 1'-0"


ENLARGED TECH ROOM A-235C - POWER
SCALE: 1/4" = 1'-0"

ENLARGED TECH ROOM A-232 - POWER
SCALE: 1/4" = 1'-0"

Hex Notes

1. MOUNT INSIDE TEACHERS CABINET AT APPROXIMATELY 60" AFF. COORDINATE LOCATION.
2. RECEPTACLE FOR CHARGING CARTS. VERIFY EXACT LOCATION PRIOR TO ROUGH-IN.
3. RECEPTACLE FOR WALL MOUNTED TELEVISION. VERIFY EXACT HEIGHT AND LOCATION PRIOR TO ROUGH-IN SO THAT RECEPTACLE IS HIDDEN BEHIND TELEVISION.

KEY PLAN

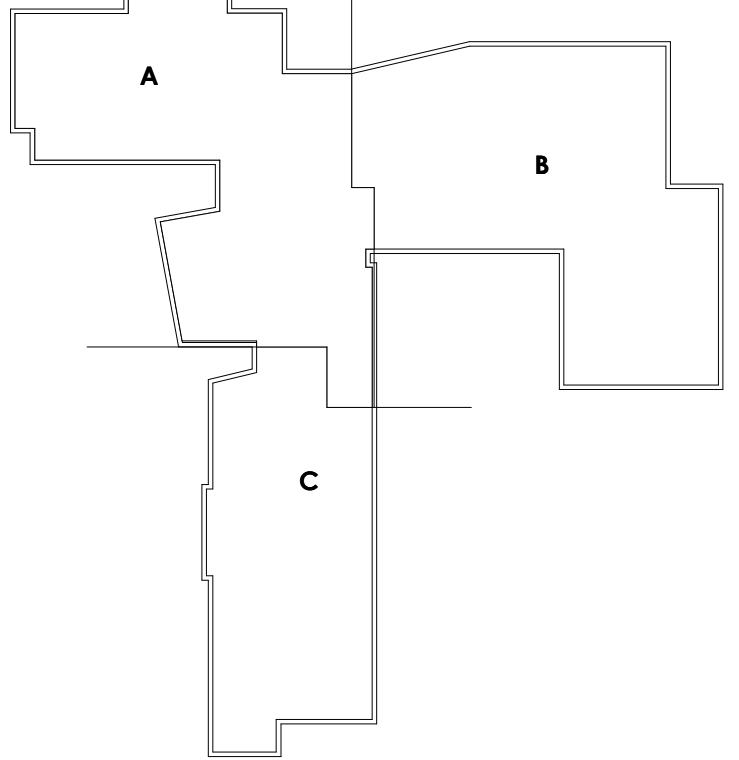

PROJECT NO
2203-1

ARCHITECTURAL VISION GROUP, LTD
ARCHITECTS
PLANNERS
CLEVELAND, OHIO 44145
23850 SPERRY DRIVE

CONSULTANT
J.M. VERSTIG, INC.
COMMERCIAL DESIGN

MASSILLON CITY SCHOOL
MASSILLON WEST ELEMENTARY
PK-3
250 29TH STREET NW, MASSILLON, OHIO 44646

PROJECT NO	2203-1
DRAWN BY	KVE
CHECKED BY	TJK
DATE	07/12/23

07/12/23
DATE
07/12/23
ISSUED AS:

07/12/23
DATE
07/12/23
ISSUED AS:

SECOND FLOOR
PLAN - POWER -
UNIT A

SCALE: As indicated
SHEET NO
E-202-A