




FIRST FLOOR PLAN - SYSTEMS - UNIT B
SCALE: 1/8" = 1'-0"


Hex Notes

- ① JUNCTION BOX FOR MOTORIZED SUN SHADES. MAKE ALL CONNECTIONS AS REQUIRED.
- ② FIRE ALARM DEVICE TO BE MOUNTED ON MULLION.
- ③ POWER FOR RETRACTABLE SEATING. VERIFY EXACT LOCATION PRIOR TO ROUGH-IN.
- ④ JUNCTION BOX ABOVE ACCESSIBLE CEILING FOR TEMPERATURE CONTROL CONTRACTOR'S USE.

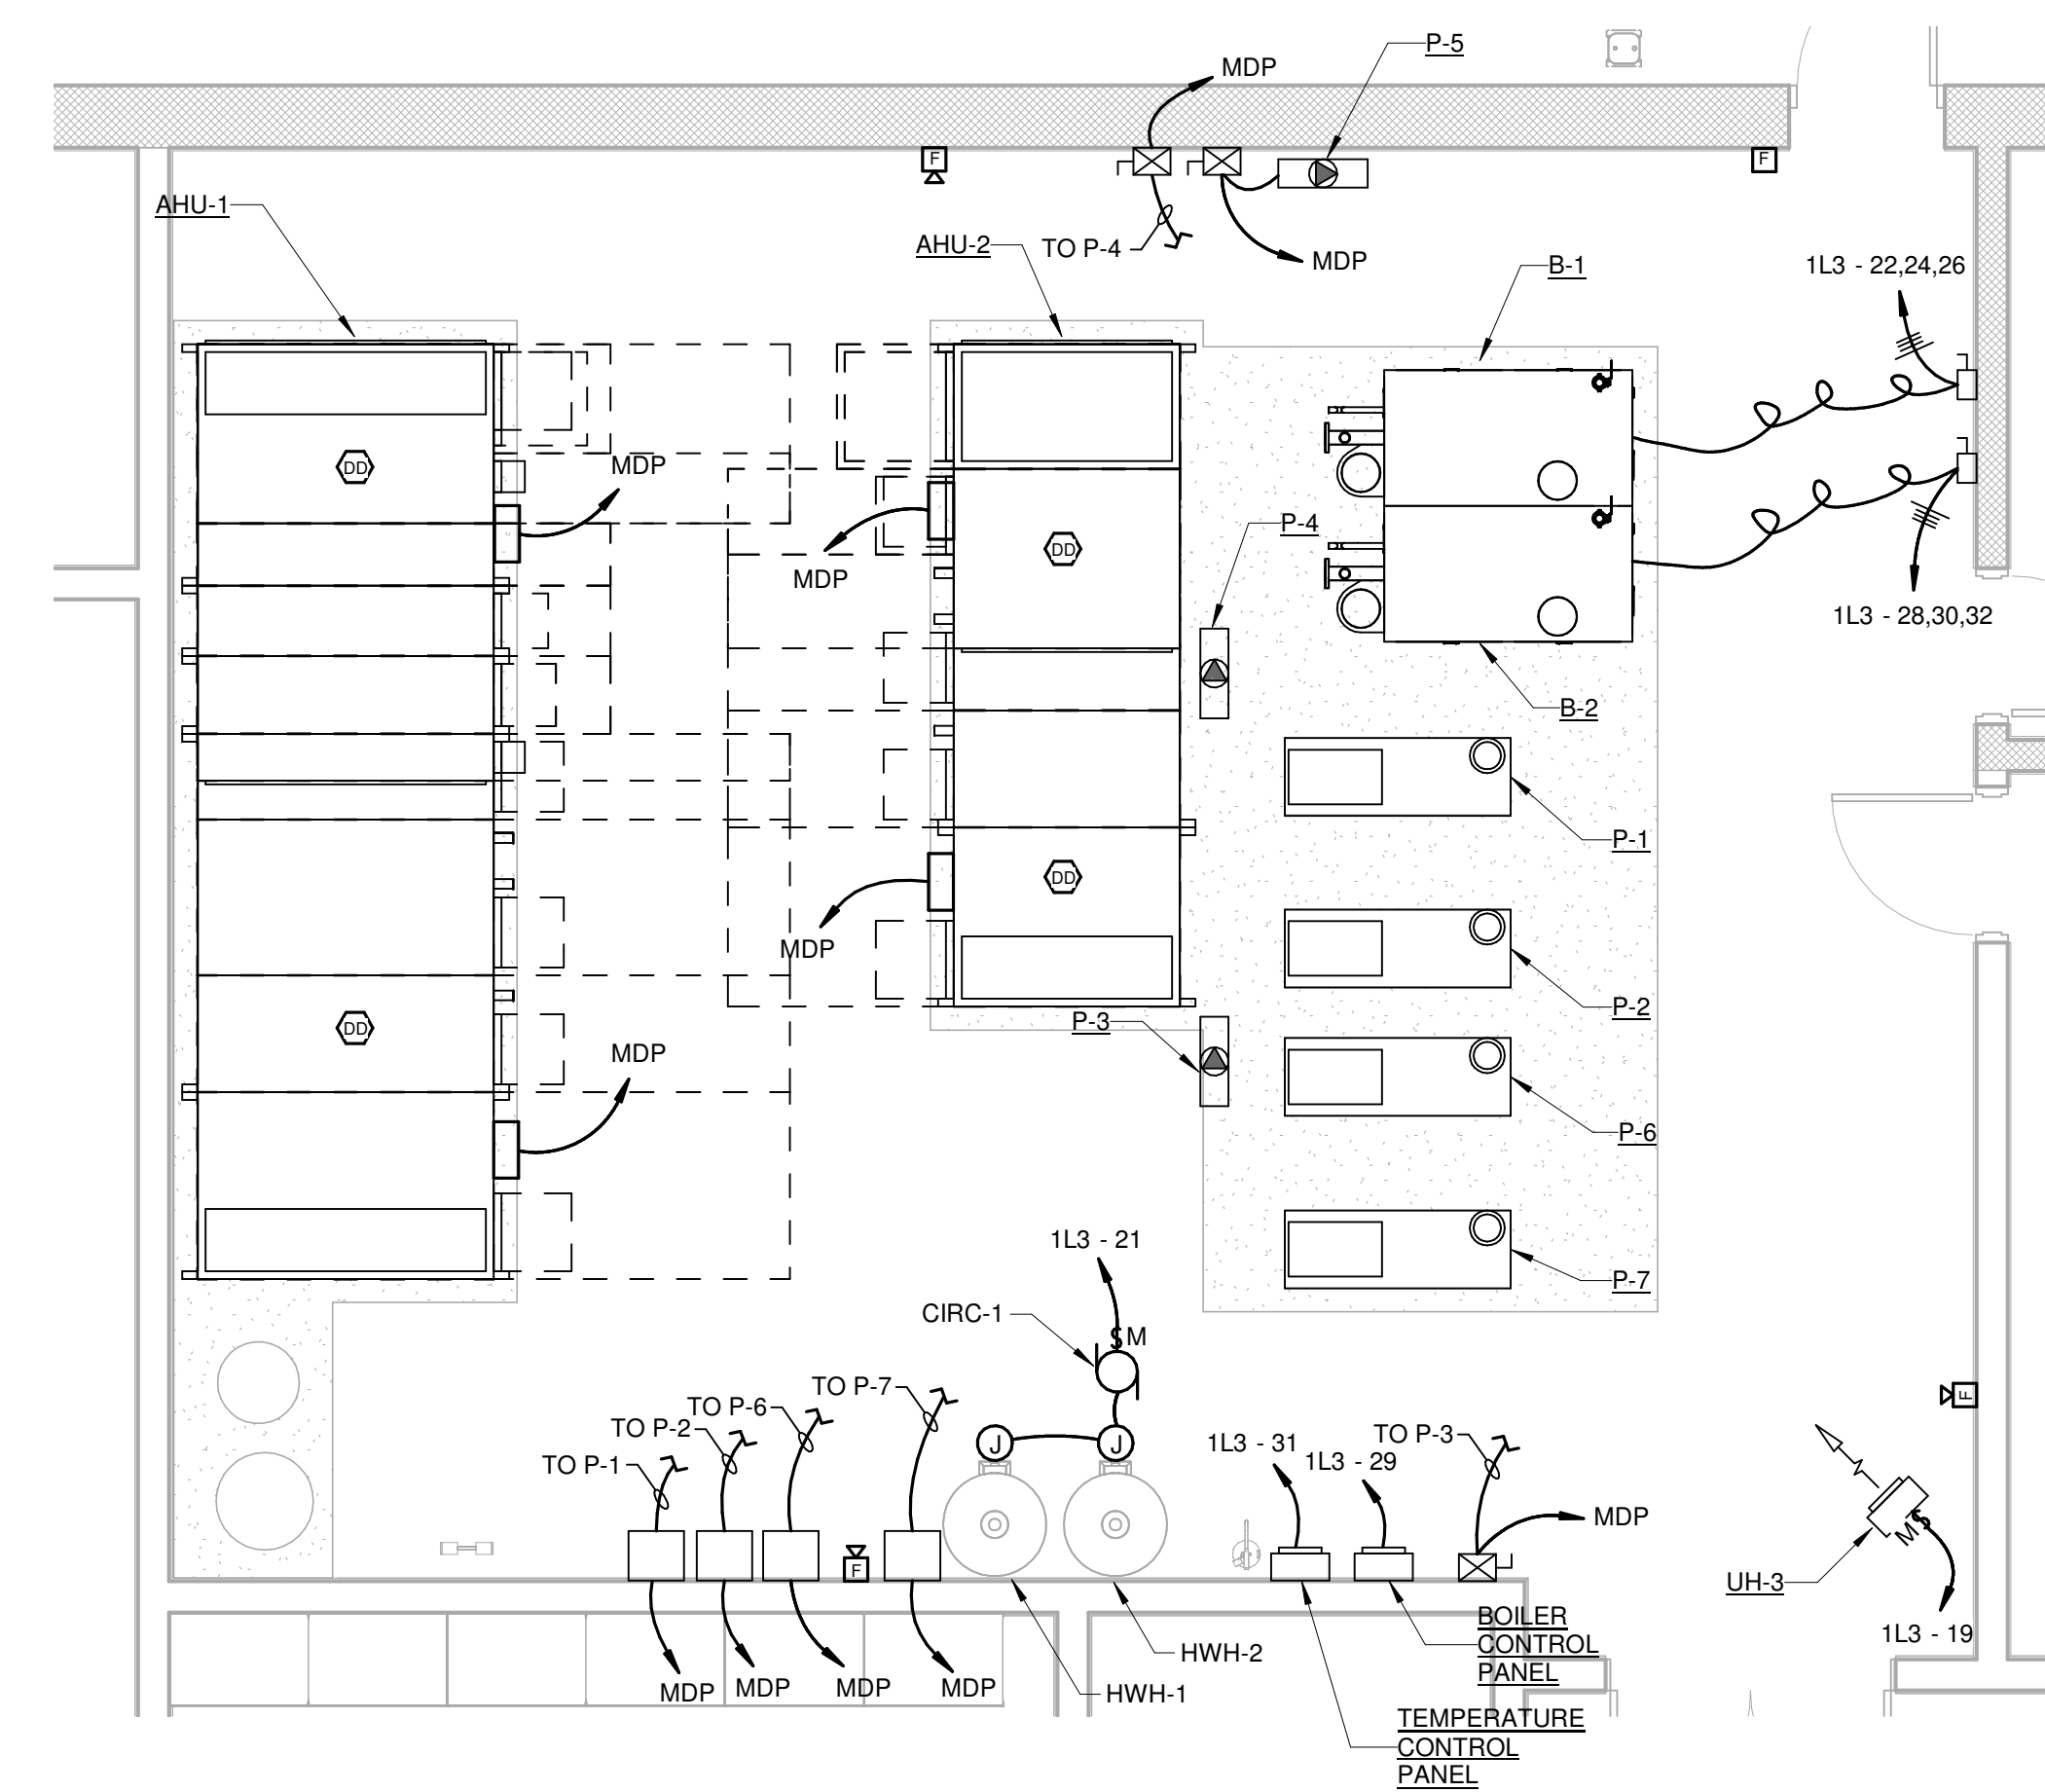



ENLARGED MECHANICAL ROOM B-117
SCALE: 1/4" = 1'-0"

KEY PLAN

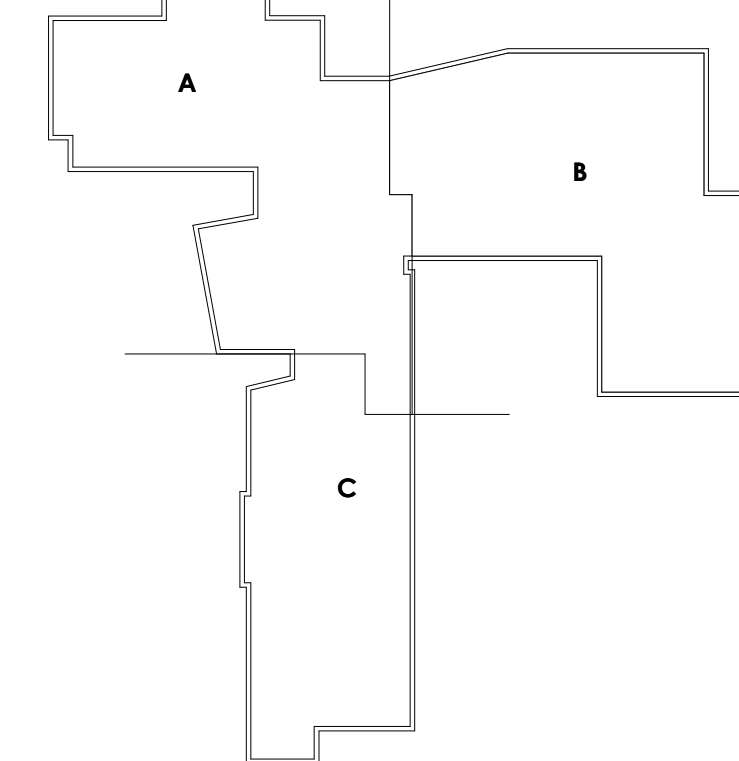

PROJECT NO
2203-1

ARCHITECTURAL VISION GROUP, LTD
ARCHITECTS
PLANNERS
23850 SPERRY DRIVE
CLEVELAND, OHIO 44145

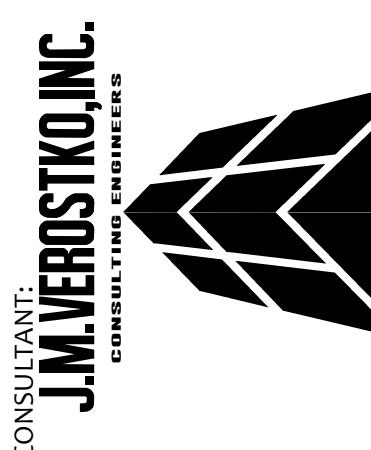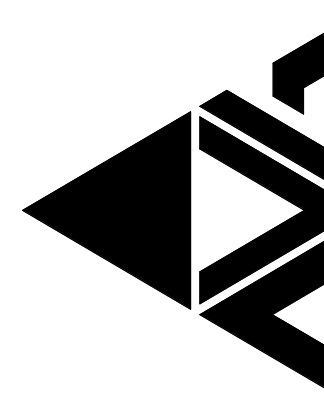

MASSILLON CITY SCHOOL
MASSILLON WEST ELEMENTARY
PK-3
250 29TH STREET NW, MASSILLON, OHIO 44646

DATE	ISSUED AS	DESCRIPTION
07/12/23	ISSUED	ISSUED AS

PROJECT NO 2203-1
DRAWN BY KVE
CHECKED BY TJC
DATE 07/12/23

FIRST FLOOR
PLAN - SYSTEMS
- UNIT B

SCALE: As indicated
SHEET NO
E-301-B