





SECOND FLOOR PLAN - SYSTEMS - UNIT A
SCALE: 1/8" = 1'-0"

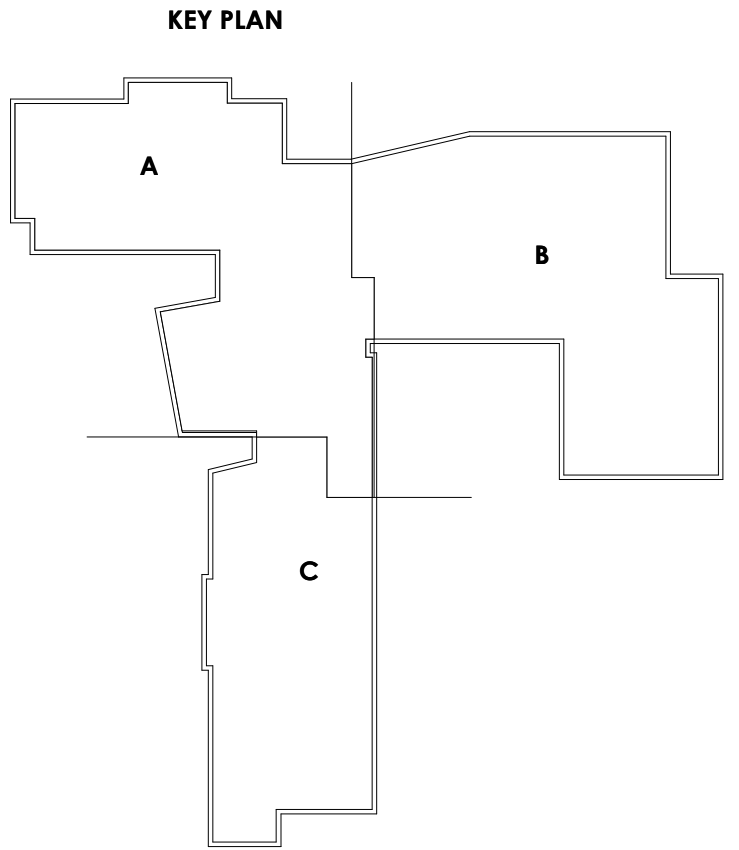



Hex Notes
① CONNECT TO LIGHTING CIRCUIT AND CONTROL WITH LIGHT FIXTURE.
② JUNCTION BOX ABOVE ACCESSIBLE CEILING FOR TEMPERATURE CONTROL CONTRACTOR'S USE.

PROJECT NO
2203-1

ARCHITECTURAL VISION GROUP, LTD
ARCHITECTS
23850 SPERRY DRIVE
CLEVELAND, OHIO 44145

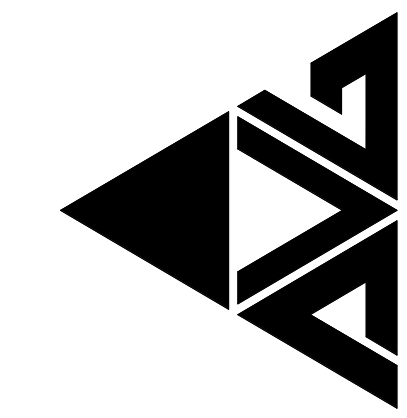

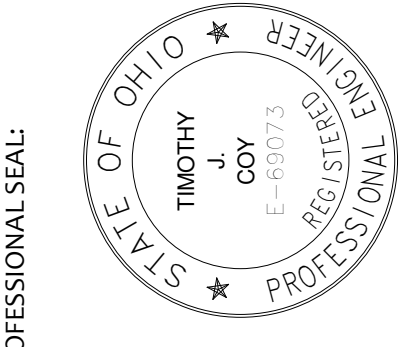

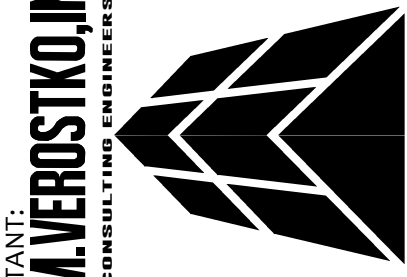

MASSILLON CITY SCHOOL
MASSILLON WEST ELEMENTARY
PK-3
250 29TH STREET NW, MASSILLON, OHIO 44646

DATE	ISSUED AS	DESCRIPTION
07/12/23	ISSUED AS	ISSUED AS

PROJECT NO 2203-1
DRAWN BY KVE
CHECKED BY TJC
DATE 07/12/23

SECOND FLOOR
PLAN - SYSTEMS
- UNIT A

SCALE: 1/8" = 1'-0"
SHEET NO
E-302-A