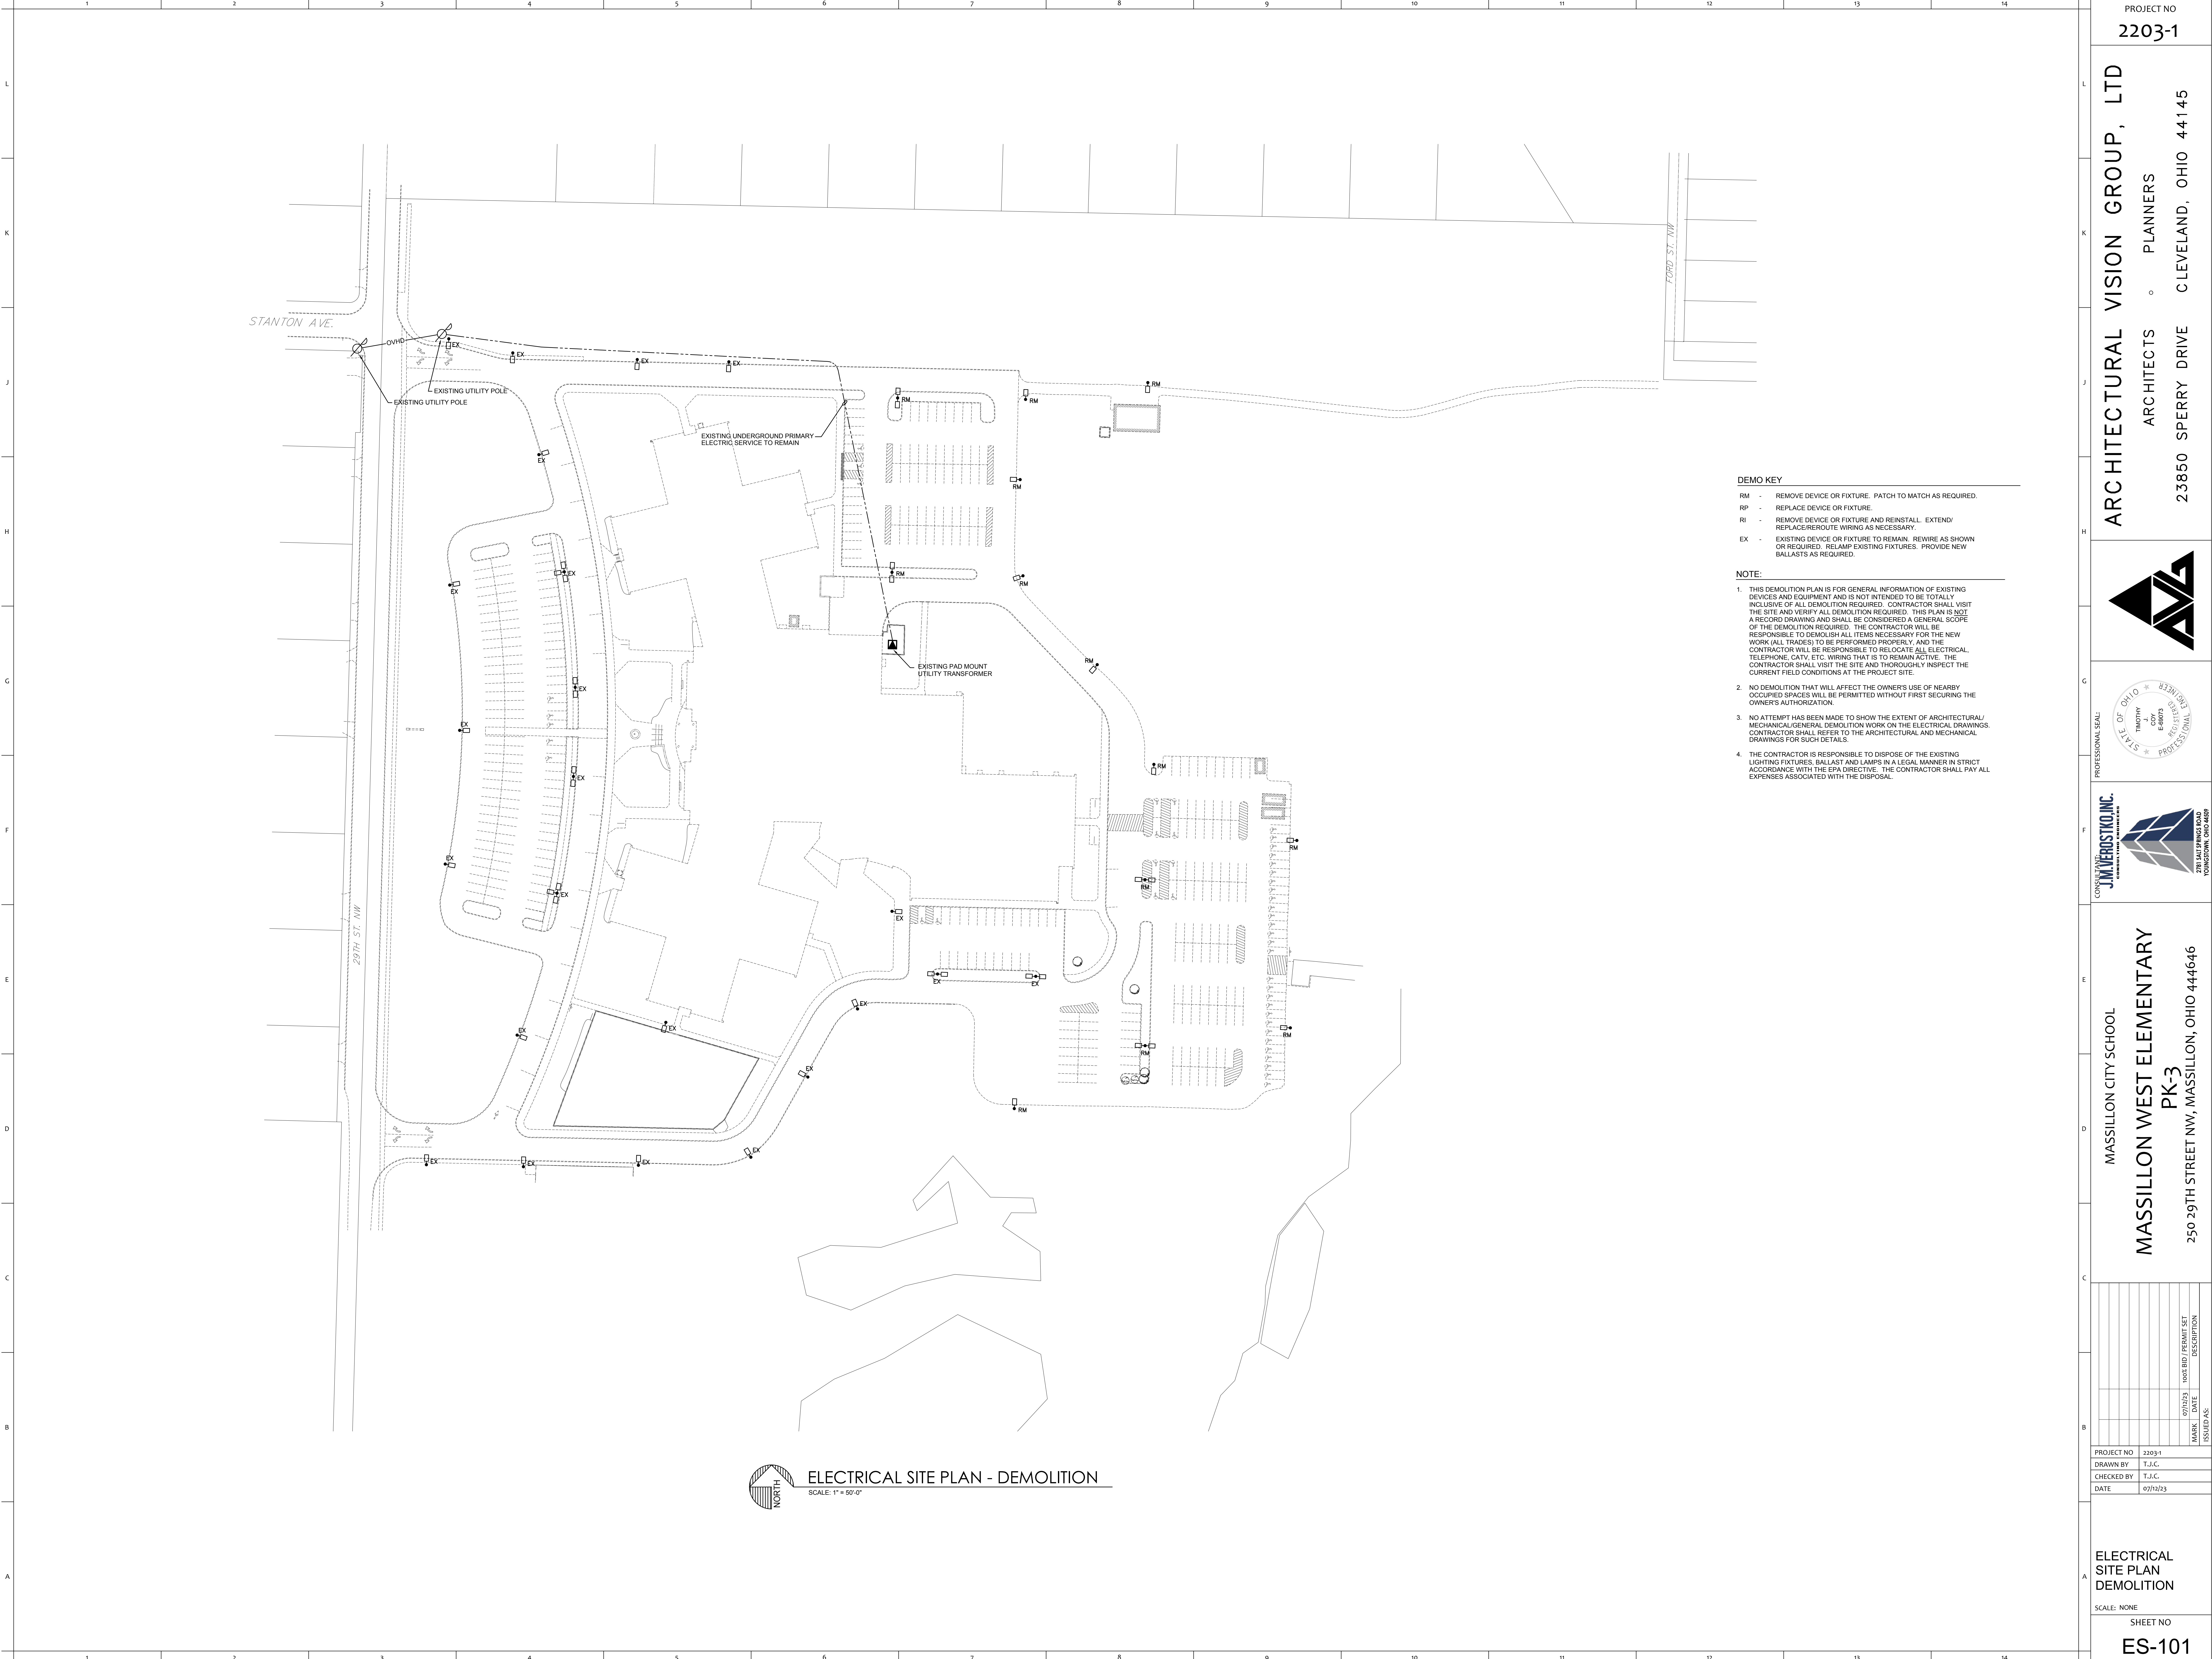


ELECTRICAL SITE PLAN - DEMOLITION

SCALE: 1" = 80'-0"

PROJECT NO  
2203-1

ARCHITECTURAL VISION GROUP, LTD  
ARCHITECTS  
PLANNERS  
23850 SPERRY DRIVE  
CLEVELAND, OHIO 44145

MASSILLON CITY SCHOOL  
MASSILLON WEST ELEMENTARY  
PK-3  
250 29TH STREET NW, MASSILLON, OHIO 44646

| MARK       | DATE     | DESCRIPTION           |
|------------|----------|-----------------------|
|            | 07/12/23 | 100% BID / PERMIT SET |
| ISSUED AS: |          |                       |

PROJECT NO 2203-1  
DRAWN BY T.J.C.  
CHECKED BY T.J.C.  
DATE 07/12/23

ELECTRICAL  
SITE PLAN  
DEMOLITION  
SCALE: NONE  
SHEET NO  
ES-101