
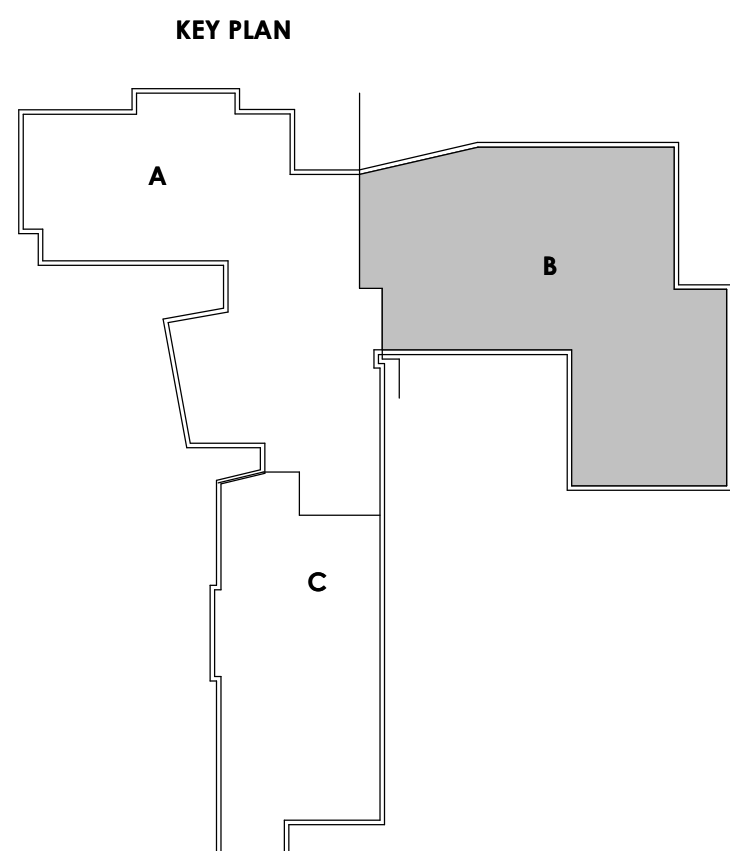


GENERAL SHEET NOTES

1. FOR ADDITIONAL INFORMATION, REFER TO DRAWING T-001.

CODED PLAN NOTES



- APPROXIMATE LOCATION OF OWNER PROVIDED LU PROJECTOR AND ASSOCIATED SOUND SYSTEM (NO. PART OF DISTRICT LFI).
- APPROXIMATE LOCATION OF FACEPLATE FOR PROJECTOR CPU (HEART). CONTRACTOR SHALL VERIFY EXACT LOCATION IN FIELD WITH OWNER AND OWNERS LU PROJECTOR CONTRACTOR PRIOR TO MOVE FREELY WHEN THE MOVABLE BLEACHERS OPEN AND CLOSE.
- FOR SCORER'S TABLE. CONTRACTOR SHALL PROVIDE A RETRACTABLE CABLING REEL TO ALLOW THE ASSOCIATED CABLING TO MOVE FREELY WHEN THE MOVABLE BLEACHERS OPEN AND CLOSE.
- PROVIDE PENDANT MOUNT FOR SOUND REINFORCEMENT SPEAKERS.
- PROVIDE PENDANT MOUNT FOR SPEAKERS.
- LOCATION OF STUDENT DINING AV CABINET. REFER TO T-600 SERIES DRAWINGS FOR ADDITIONAL INFORMATION.
- LOCATION OF GYM AV CABINET. REFER TO T-400 SERIES DRAWINGS FOR ADDITIONAL INFORMATION.
- LOCATION OF MUSIC ROOM SOUND SYSTEM CABINET. REFER TO T-600 SERIES DRAWINGS FOR ADDITIONAL INFORMATION.
- PROVIDE PROJECTOR AND ASSOCIATED CEILING MOUNTED SCISSOR LIFT ATTACHED TO STRUCTURE ABOVE. VERIFY EXACT LOCATION IN FIELD WITH OTHER TRADES.

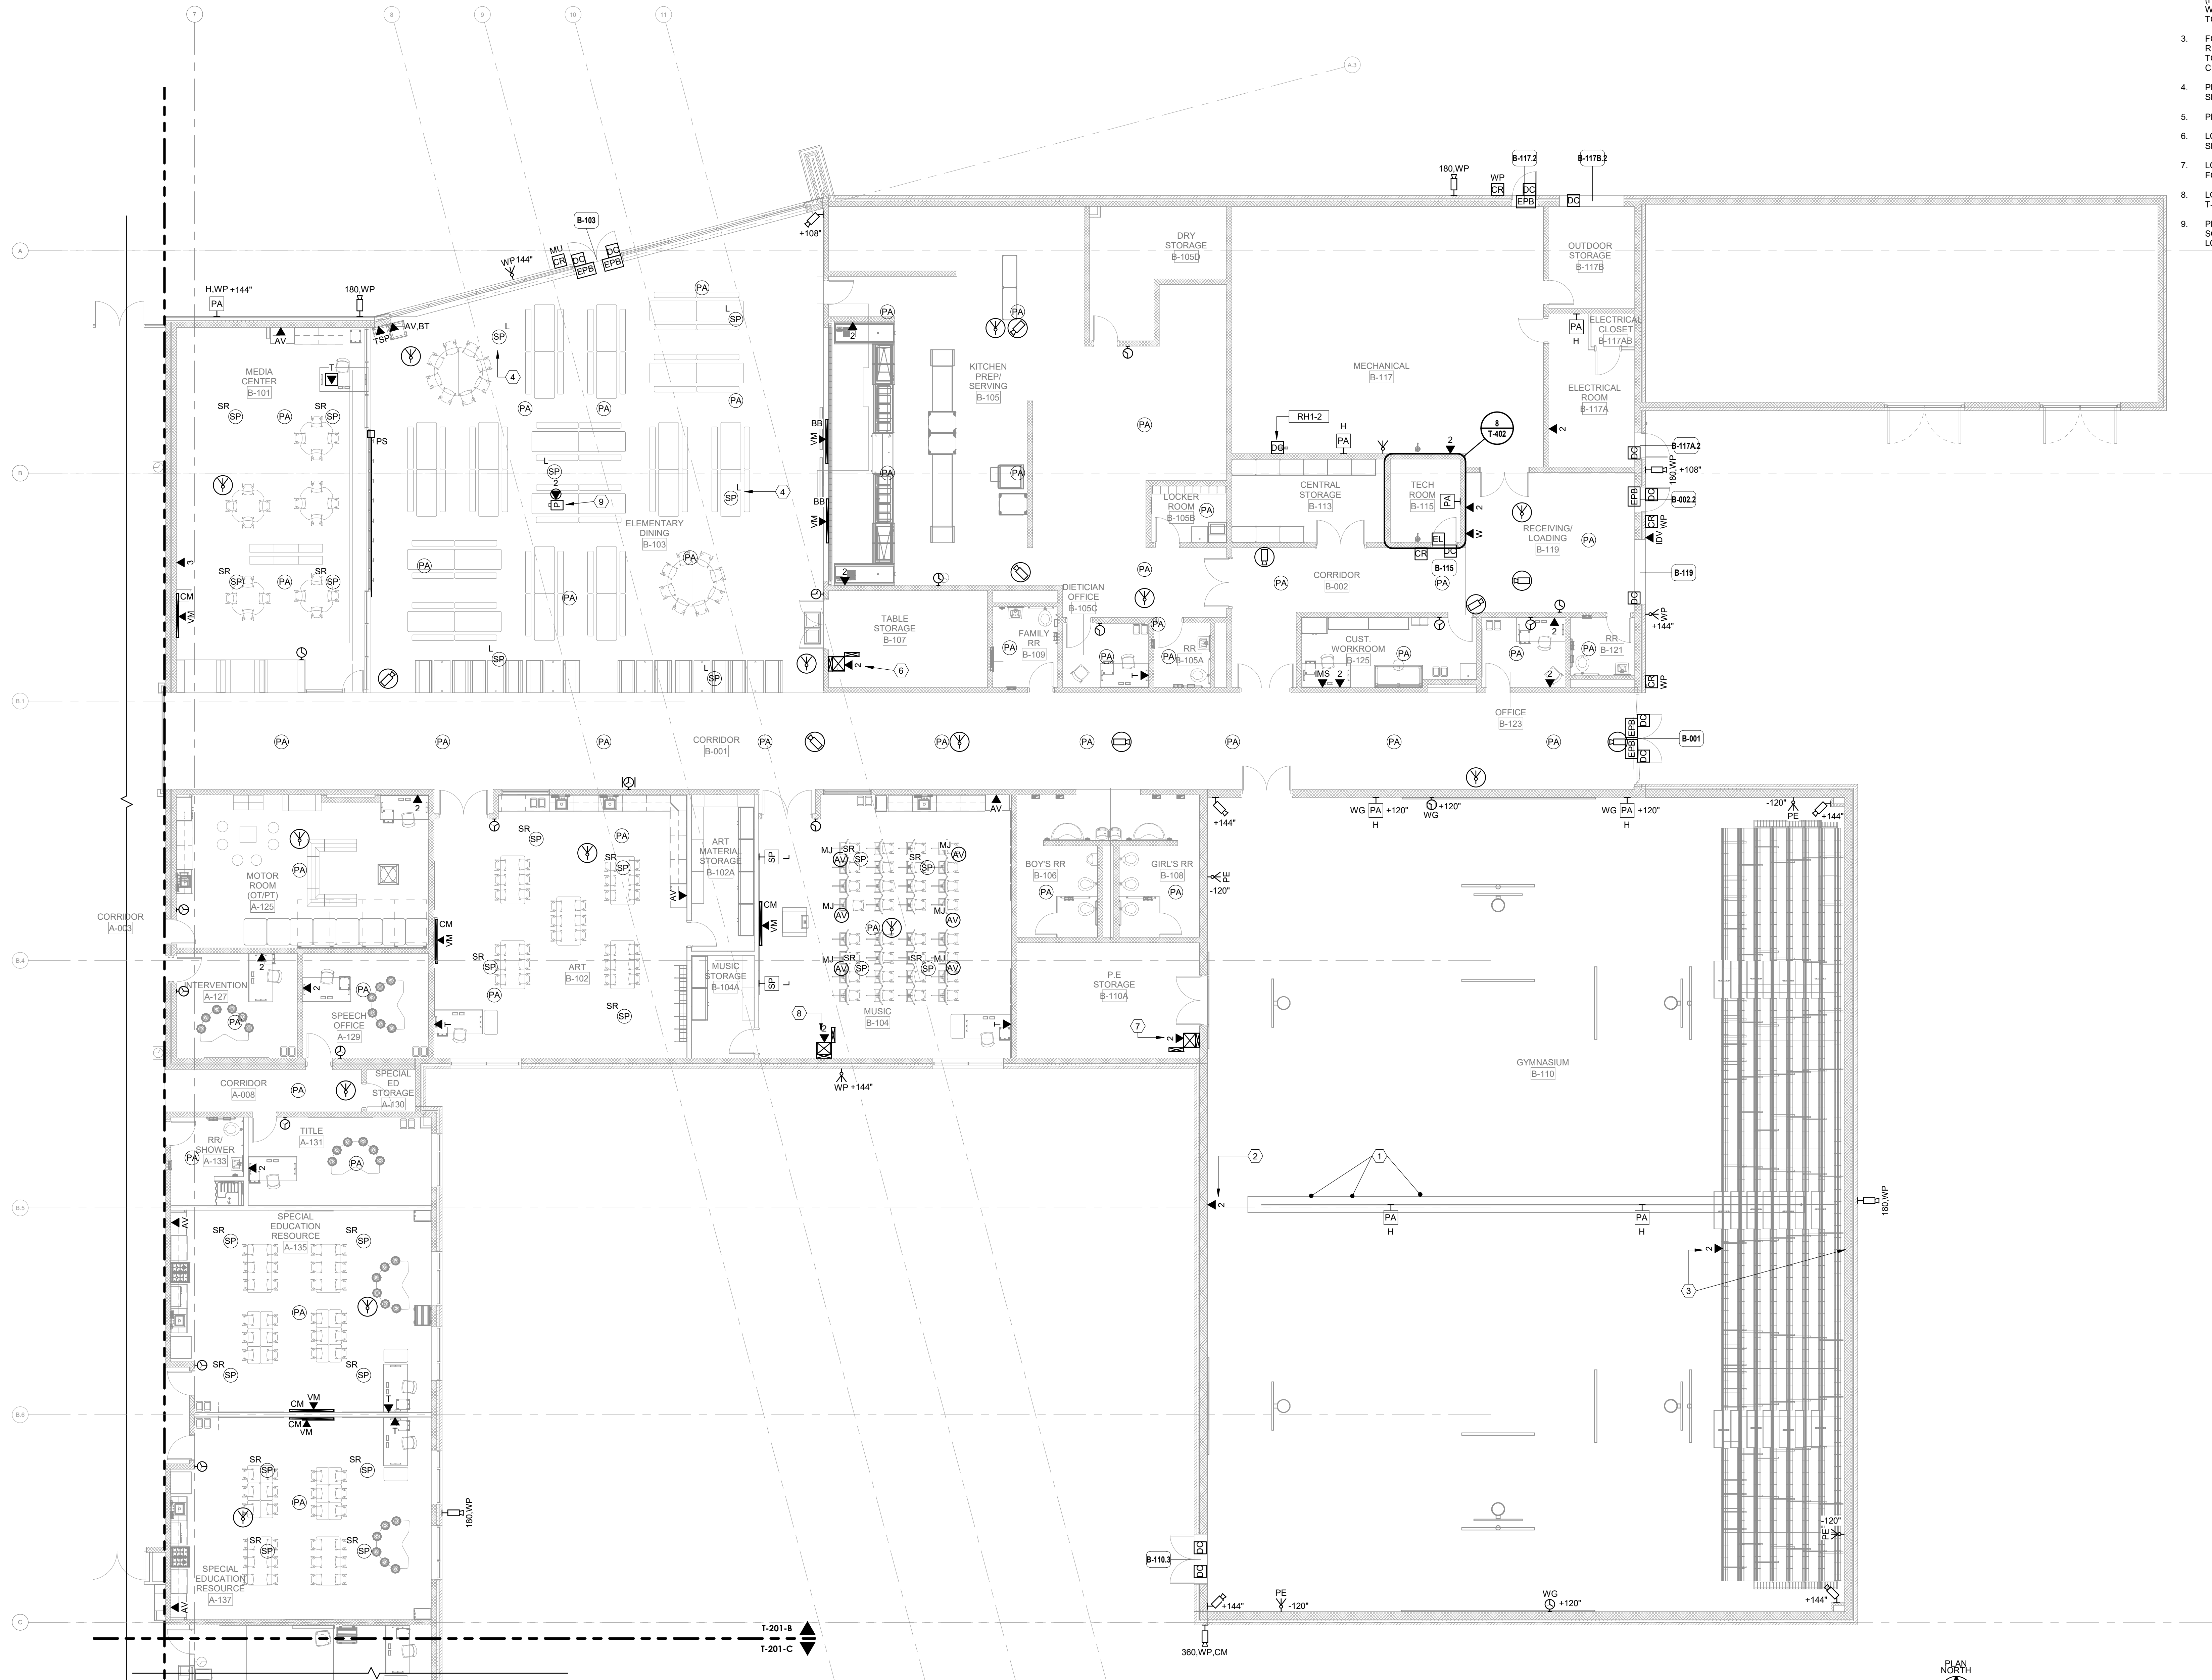

01 FIRST FLOOR TECHNOLOGY PLAN - UNIT B
SCALE: 1/8" = 1'-0"

PROJECT NO
2203-1

ARCHITECTURAL VISION GROUP, LTD
PLANNERS
ARCHITECTS
23850 SPERRY DRIVE
CLEVELAND, OHIO 44145

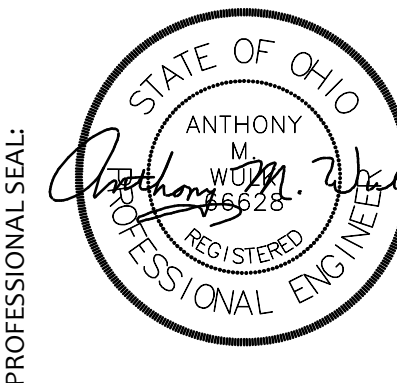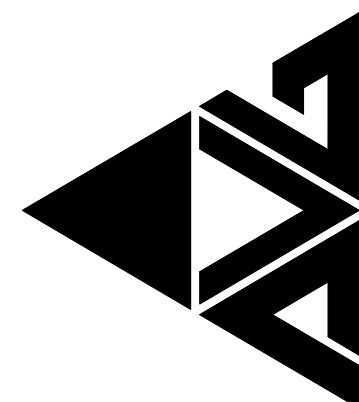

MASSILLON CITY SCHOOLS
MASSILLON WEST ELEMENTARY
PK-3
250 20TH STREET NW, MASSILLON, OHIO 44646
MASSILLON CITY SCHOOL DISTRICT MASSILLON, OHIO

MARK	DATE	DESCRIPTION
	07/12/23	100% BID PERMIT SET

PROJECT NO	2203-1
DRAWN BY	DRK
CHECKED BY	AMW
DATE	07/12/23

FIRST FLOOR
TECHNOLOGY
PLAN UNIT B

SCALE: 1/8" = 1'-0"
SHEET NO
T-201-B