

GENERAL SHEET NOTES


1. FOR ADDITIONAL INFORMATION, REFER TO DRAWING T-001.

CODED PLAN NOTES

1. PROVIDE PENDANT MOUNT FOR SPEAKER.
2. PROVIDE PENDANT MOUNT FOR CAMERA.

PROJECT NO
2203-1

ARCHITECTURAL VISION GROUP, LTD
PLANNERS
ARCHITECTS
23850 SPERRY DRIVE
CLEVELAND, OHIO 44145

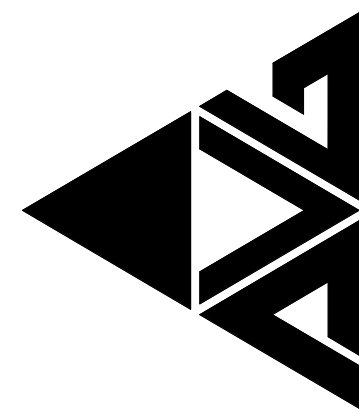

MASSILLON CITY SCHOOLS
MASSILLON WEST ELEMENTARY
PK-3
250 20TH STREET NW, MASSILLON, OHIO 44646
MASSILLON CITY SCHOOL DISTRICT MASSILLON, OHIO

MARK	DATE	DESCRIPTION
	07/12/23	100% BID PERMIT SET


PROJECT NO 2203-1
DRAWN BY DRK
CHECKED BY AMW
DATE 07/12/23

FIRST FLOOR
TECHNOLOGY
PLAN UNIT C

SCALE: 1/8" = 1'-0"
SHEET NO
T-201-C

01 FIRST FLOOR TECHNOLOGY PLAN - UNIT C
SCALE: 1/8" = 1'-0"

KEY PLAN

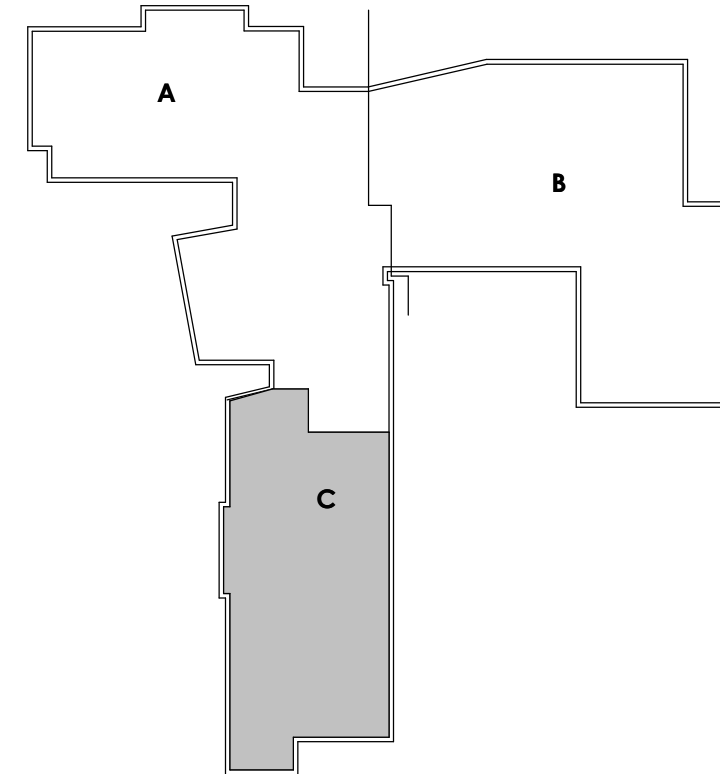

0 4' 8' 12'