


1 02 SECOND FLOOR TECHNOLOGY PLAN - UNIT C
SCALE: 1/8" = 1'-0"

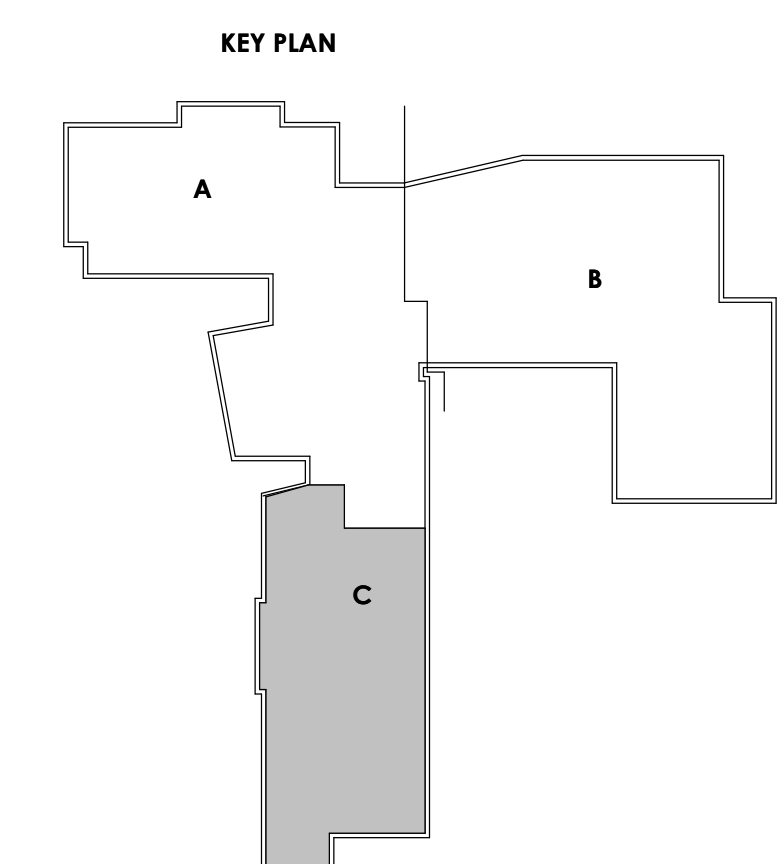

GENERAL SHEET NOTES

1. FOR ADDITIONAL INFORMATION, REFER TO DRAWING T-001.

CODED PLAN NOTES


1. PROVIDE PENDANT MOUNT FOR SPEAKERS.

PROJECT NO
2203-1

ARCHITECTURAL VISION GROUP, LTD

PLANNERS

CLEVELAND, OHIO 44145

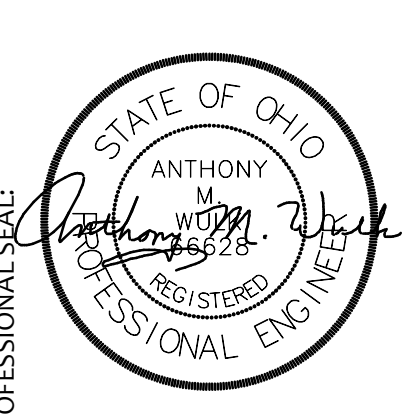

MASSILLON CITY SCHOOLS
MASSILLON WEST ELEMENTARY

PK-3
250 20TH STREET NW, MASSILLON, OHIO 44646

MASSILLION CITY SCHOOL DISTRICT MASSILLON, OHIO

[illegible]

PROJECT NO	2203-1
DRAWN BY	DRK
CHECKED BY	AMW
DATE	07/12/23

SECOND FLOOR
TECHNOLOGY
PLAN UNIT C

SCALE: 1/8" = 1'-0"

SHEET NO

T-202-C