


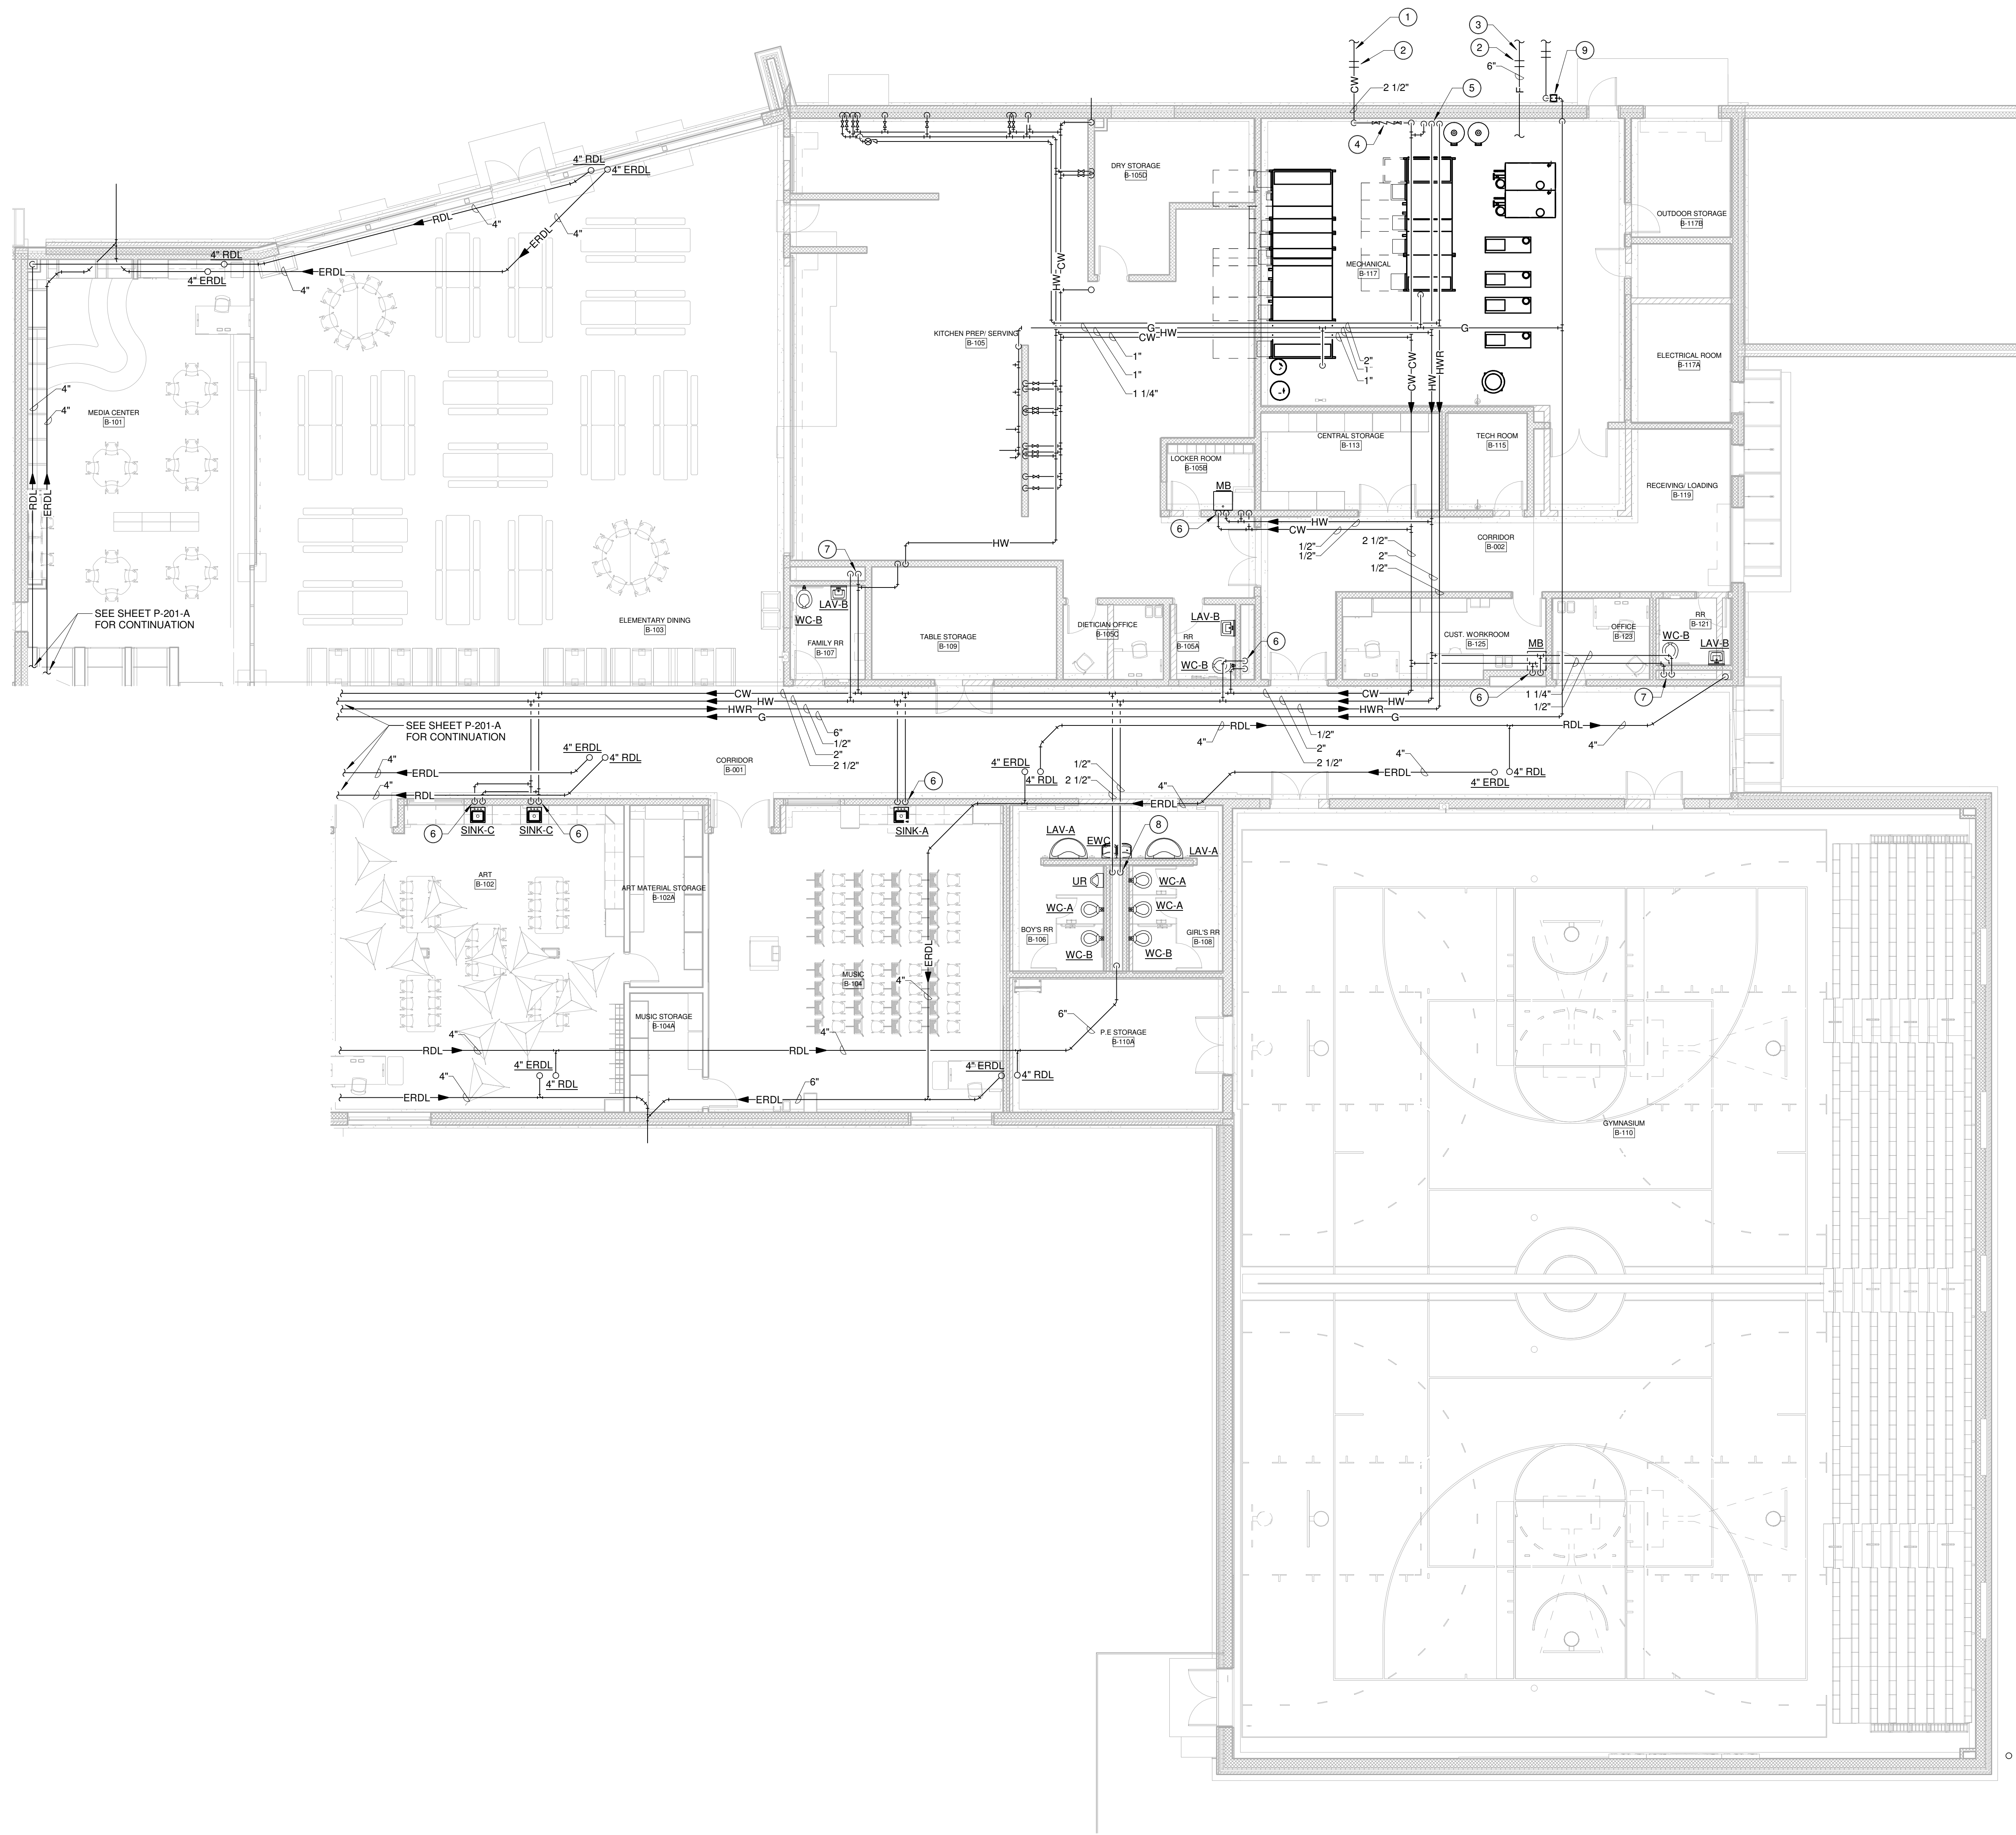

- CODED NOTES:**
- 1 2 1/2" WATER MAIN BY SITE UTILITY CONTRACTOR.
 - 2 FINAL CONNECTION TO SITE WATER MAIN BY PLUMBING CONTRACTOR.
 - 3 6" FIRE MAIN.
 - 4 2 1/2" WATER SERVICE. SEE DETAIL ON SHEET P-401.
 - 5 3/4" CW, 2" HW, AND 1/2" HWR DOWN FOR CONNECTION TO HWH. SEE DETAIL ON SHEET P-401.
 - 6 1/2" CW AND HW LINES DOWN FOR CONNECTION TO FIXTURE.
 - 7 1 1/4" CW AND 1/2" HW LINES DOWN INTO CHASE FOR CONNECTION TO FIXTURES.
 - 8 2" CW AND 1/2" HW LINES DOWN INTO CHASE FOR CONNECTIONS TO FIXTURES.
 - 9 PLUMBING CONTRACTOR'S RESPONSIBILITY BEGINS AT PURCHASING AND INSTALLING GAS METER BAR/SET. PER GAS COMPANY DIRECTION (VERIFY EXACT LOCATION OF METER). COORDINATE INSTALLATION OF GAS LINE WITH OTHER UTILITIES.

FIRST FLOOR PLAN - DOMESTIC PLUMBING PLAN - UNIT B
SCALE: 1/8" = 1'-0"

FOR REFERENCE ONLY

PROJECT NO
2203-1

ARCHITECTURAL VISION GROUP, LTD
ARCHITECTS
PLANNERS
23850 SPERRY DRIVE
CLEVELAND, OHIO 44145

PROFESSIONAL SEAL

FOR PROGRESS ONLY

CONSULTANT

J.M. VERSTIG, INC.

2716 S.W. 10TH AVE., SUITE 100
MIAMI, FL 33135

MASSILLON CITY SCHOOL
MASSILLON WEST ELEMENTARY
PK-3
250 29TH STREET NW, MASSILLON, OHIO 44646

MARK	DATE	DESCRIPTION

PROJECT NO
2203-1

DRAWN BY
JRS

CHECKED BY
Checker

DATE

FIRST FLOOR
PLAN -
PLUMBING - UNIT
B

SCALE: 1/8" = 1'-0"

SHEET NO
P-201-B