


AQUA OHIO WATER UTILITY SUMMARY		
DESCRIPTION	UNIT	QUANTITY
8" CL 52 DUCTILE IRON WATER LINE	LF	2,154
6" CL 52 DUCTILE IRON WATER LINE	LF	133
4" CL 52 DUCTILE IRON WATER LINE	LF	264
3" CL 52 DUCTILE IRON WATER LINE	LF	72
10" GATE VALVE	EACH	2
8" GATE VALVE	EACH	8
6" GATE VALVE	EACH	3
4" GATE VALVE	EACH	1
3" GATE VALVE	EACH	1
8" - 45° BEND	EACH	10
6" - 45° BEND	EACH	1
4" - 45° BEND	EACH	4
3" - 45° BEND	EACH	1
10" X 8" TEE	EACH	1
8" X 8" TEE	EACH	2
8" X 6" TEE	EACH	10
6" X 6" TEE	EACH	1
8" X 6" REDUCER	EACH	1
DOMESTIC WATER TAP	EACH	2
FIRE SERVICE TAP	EACH	1
STORTZ REMOTE FIRE CONNECTION	EACH	1
FIRE HYDRANT ASSEMBLY WITH WATCH VALVE	EACH	8

NOTE: SUMMARY IS FOR AQUA OHIO APPROVAL ONLY. CONTRACTOR RESPONSIBLE TO DETERMINE THEIR OWN QUANTITIES NECESSARY TO CONSTRUCT THE WATER LINE PER PLAN.


NOTE:
SEE EXISTING TOPOGRAPHIC SURVEY
BY DEIBEL FOR EXISTING UTILITY
INFORMATION

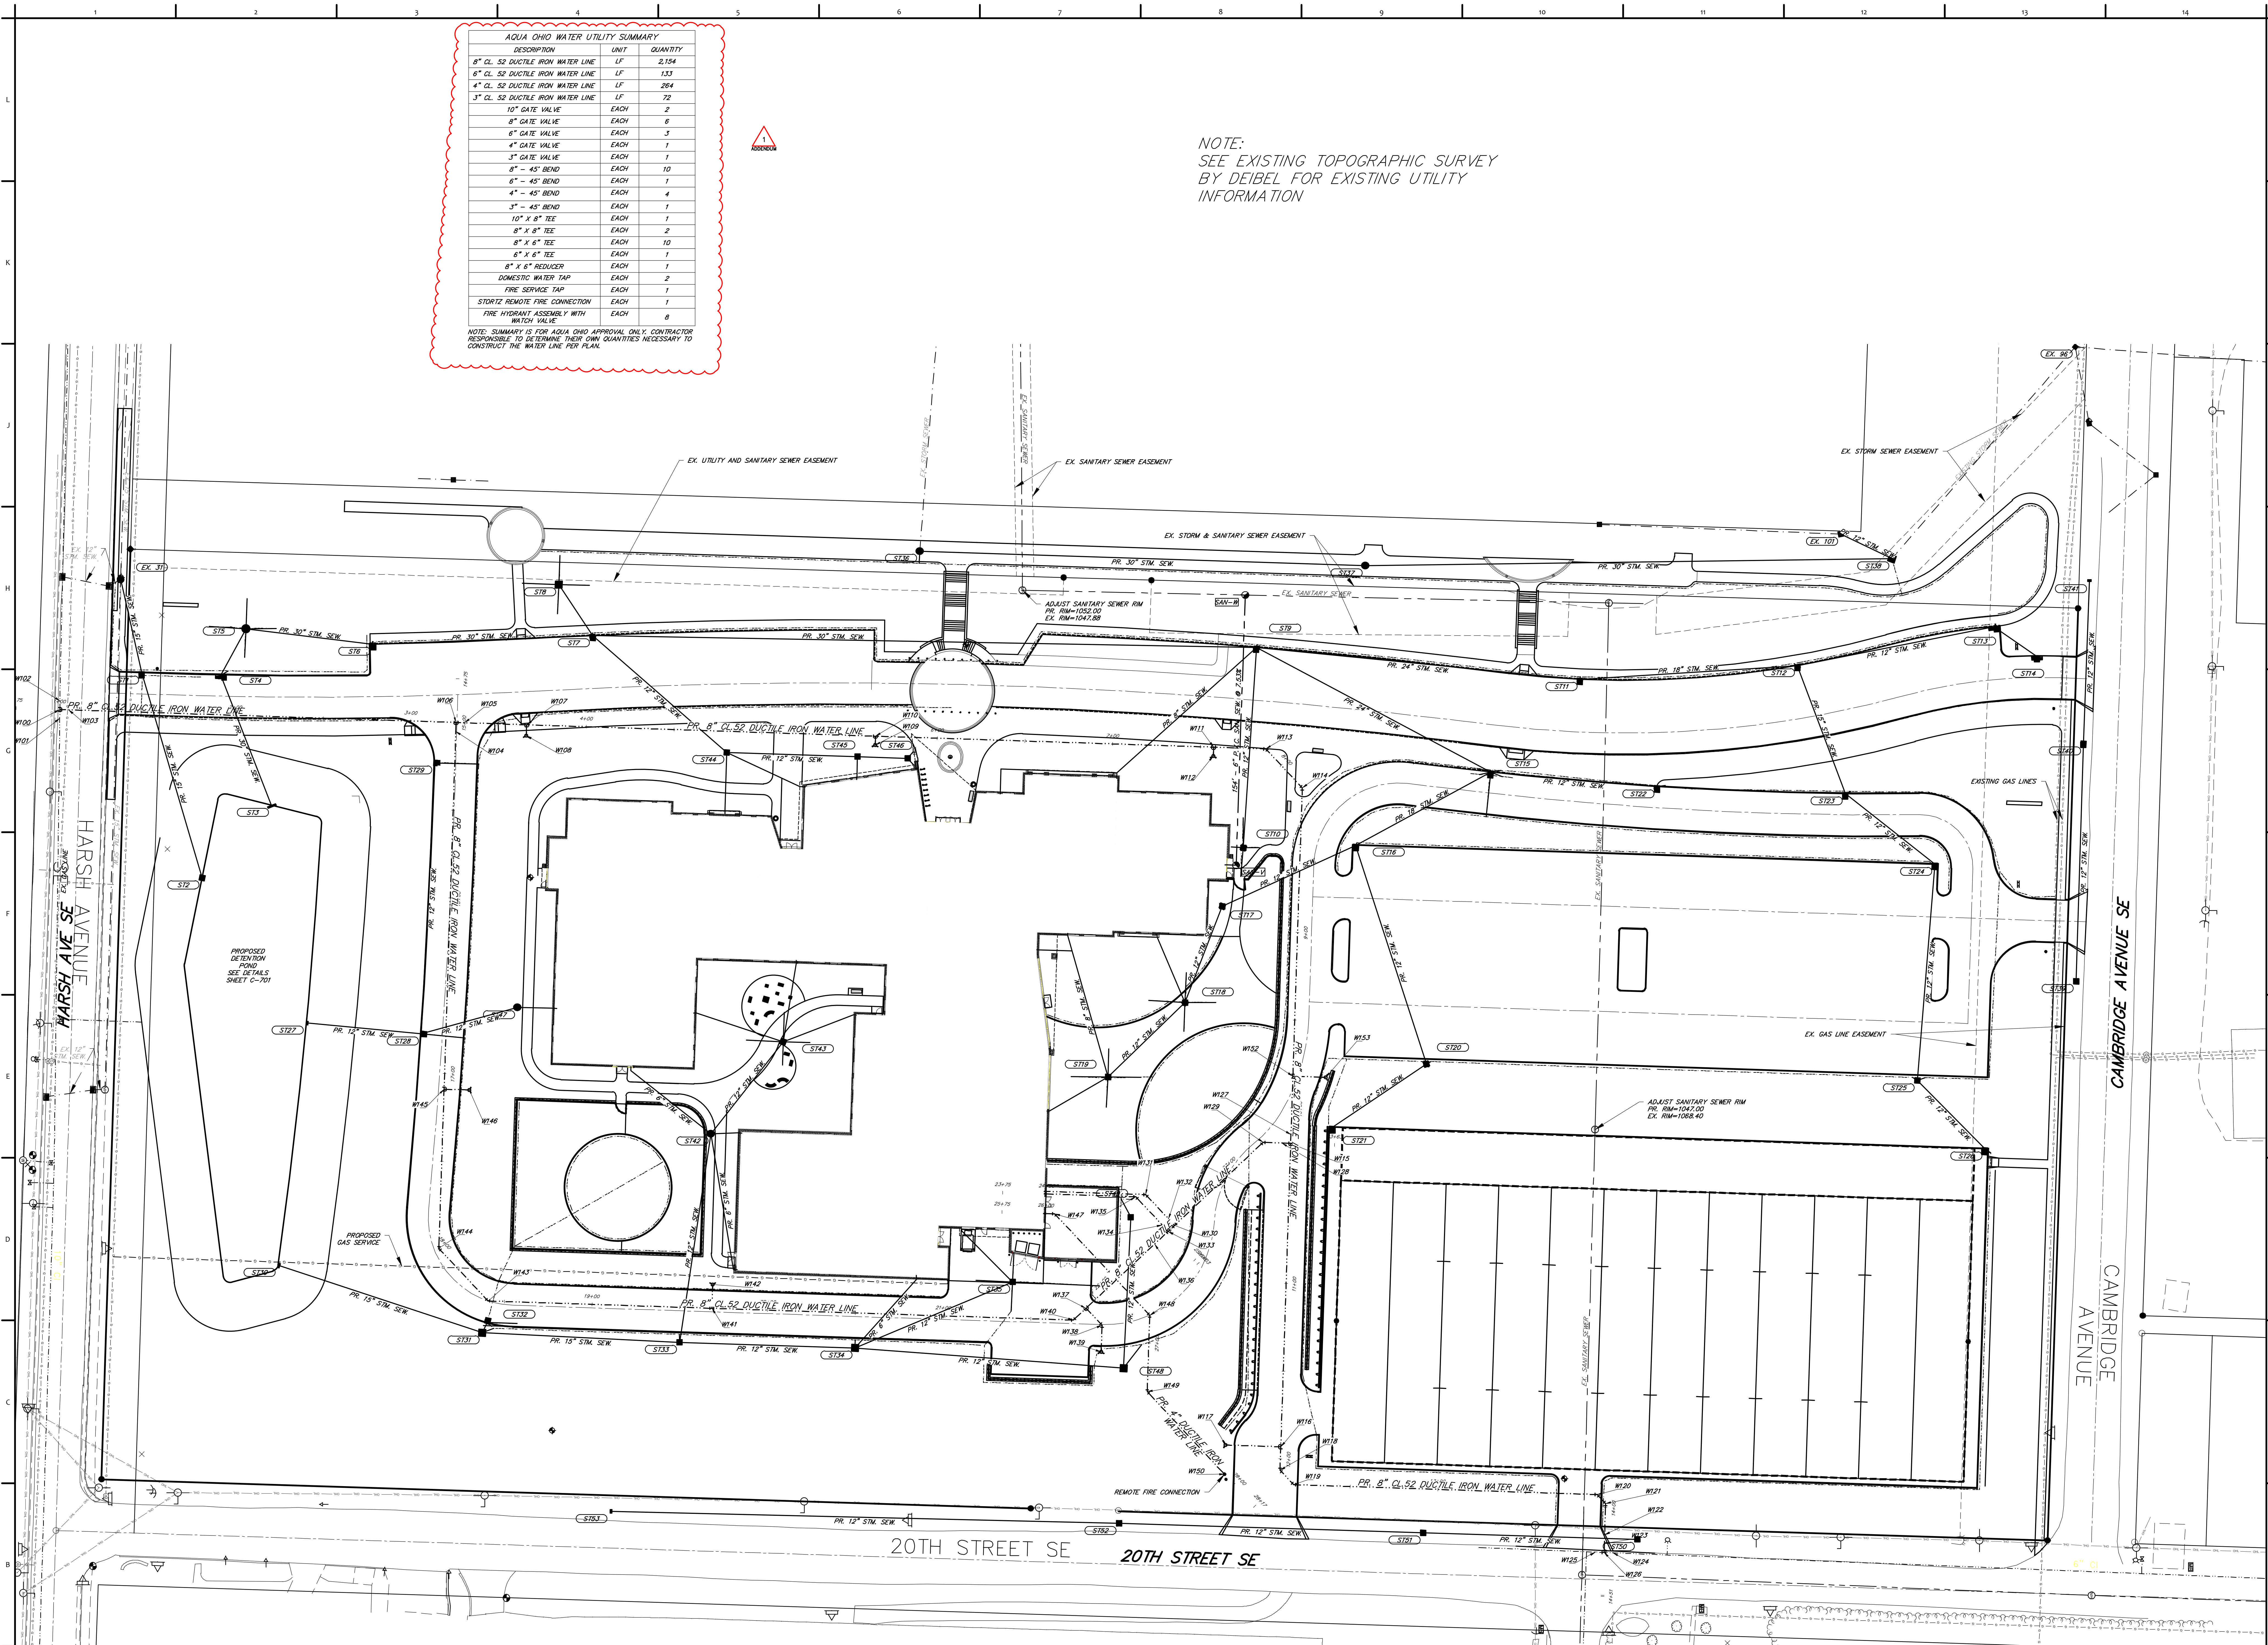

NOTE:
SEE SHEET C-401 FOR UTILITY NOTES.
SEE SHEET C-401 FOR UTILITY SCHEDULE.
SEE SHEET C-701 FOR STORMWATER MANAGEMENT BASIN PLANS.



— PLAN PREPARED BY —
LEWIS LAND PROFESSIONALS INC.

CIVIL ENGINEERING LAND SURVEYING
8691 WADSWORTH ROAD SUITE 100
WADSWORTH, OH 44281 (330) 335-8232

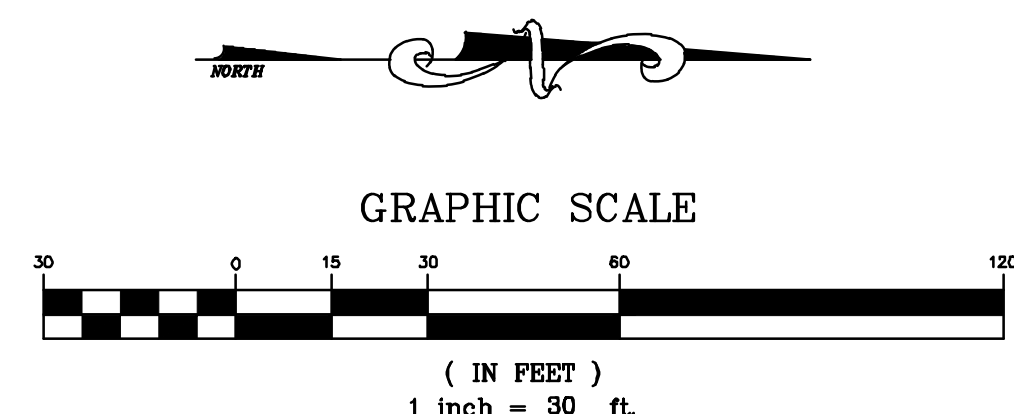

PROJECT NO
2203-2

ARCHITECTURAL VISION GROUP, LTD
ARCHITECTS • PLANNERS
23850 SPERRY DRIVE CLEVELAND, OHIO 44145

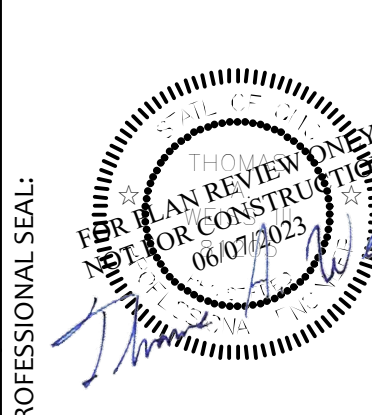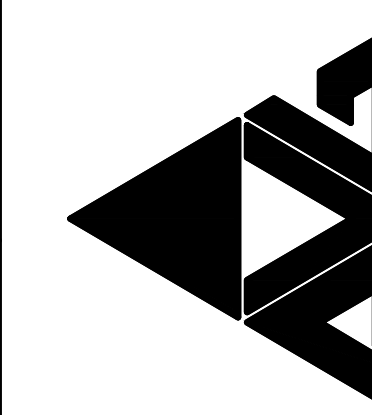

CONSULTANT
LEWIS LAND PROFESSIONALS
Civil Engineering & Land Surveying
8691 WADSWORTH ROAD
WADSWORTH, OH 44281
PH (330) 335-8232
FX (330) 335-0442
WWW.LEWISLANDPRO.COM

Massillon East Site PK-3
Eastside PK-3 Elementary School
1 Paul E Brown Drive SE
MASSILLON CITY SCHOOL DISTRICT MASSILLON, OHIO

REVISION	DATE	DESCRIPTION
06.13.23	06.13.23	BULLETIN 2
06.20.23	06.20.23	BULLETIN 1
04.24.23	04.24.23	ADDENDUM 1
03.30.23	03.30.23	PLAN REVIEW & EFP
03.30.23	03.30.23	ISSUED TO OWNER SITE PACKAGE

PROJECT NO	2203-2
DRAWN BY	
CHECKED BY	
DATE	03.17.2023

UTILITY PLAN

SCALE: 1"=30'
SHEET NO
C-400