

WWTP IMPROVEMENTS AERATION TANK RECYCLE

CITY OF MASSILLON
STARK COUNTY, STATE OF OHIO
FEBRUARY 16, 2011


INDEX OF SHEETS

CIVIL

TITLE SHEET	1
SYMBOLS AND ABBREVIATIONS	2
PLAN AND PROFILE	3

PROCESS

PLAN, SECTIONS, AND DETAILS	4
-----------------------------------	---

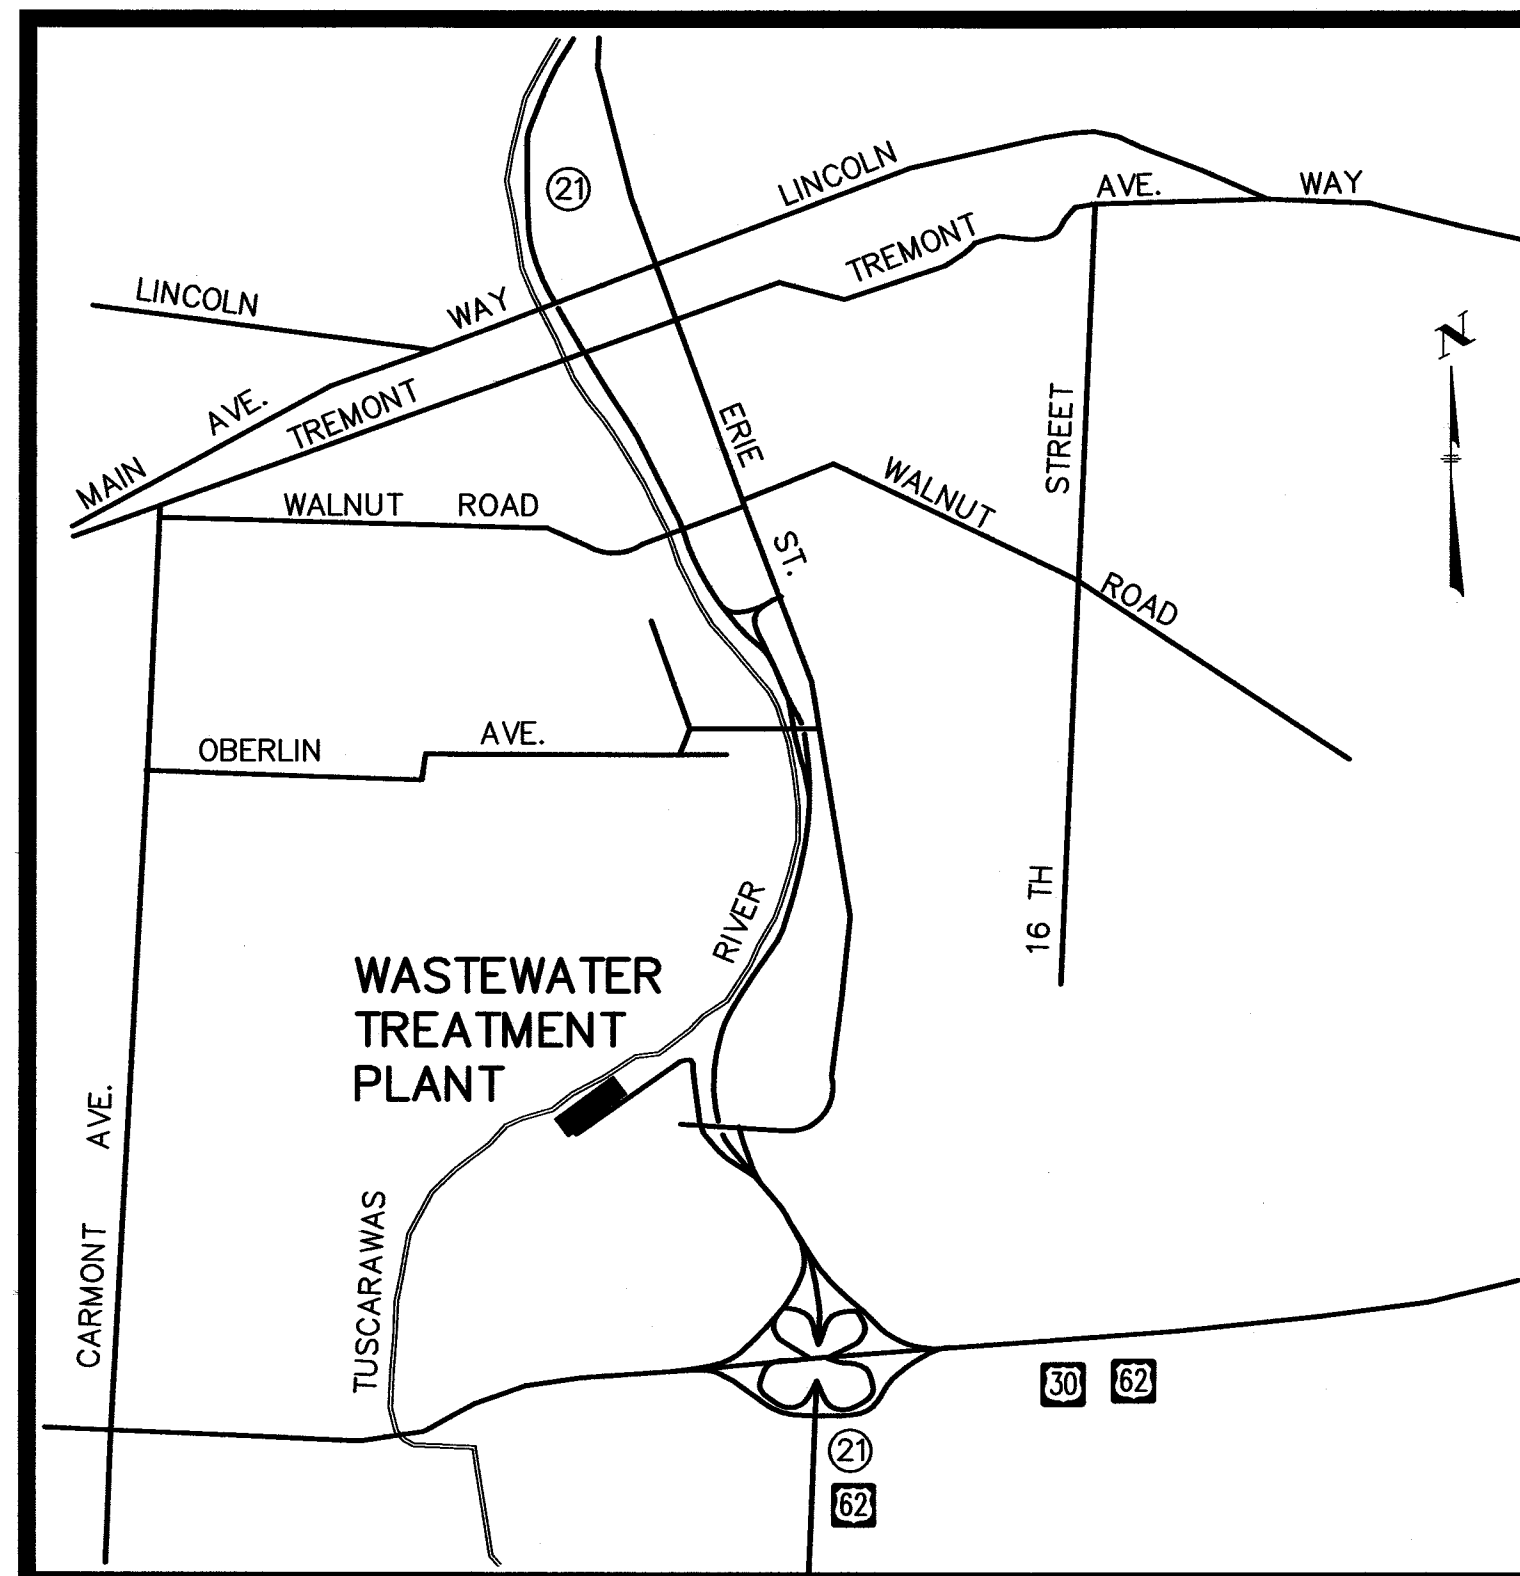

LOCATION MAP

NOT TO SCALE

Richard W. Reed 2-23-11
RICHARD W. REED P.E.
REG. ENGINEER NO. E-57288 DATE

PLANS PREPARED BY



191 CENTRAL PLAZA SOUTH, SUITE 400
CANTON, OH 44702
330-455-7733

CITY OFFICIALS

FRANCIS H. CICCHINELLI, JR.	MAYOR
MICHAEL LOUDIANA	SAFETY/SERVICE DIRECTOR
JAYNE FERRERO	AUDITOR
PAUL LAMBERT	TREASURER
PERICLES G STERGIOS	LAW DIRECTOR
KEITH A. DYLEWSKI	CITY ENGINEER
TONY ULRICH	MANAGER WASTEWATER TREATMENT DEPARTMENT

CITY COUNCIL

GLENN GAMBER	PRESIDENT
RONALD MANG	MEMBER, WARD 1
GARY ANDERSON	MEMBER, WARD 2
KATHERINE CATAZARO-PERRY	MEMBER, WARD 3
TONY M. TOWNSEND	MEMBER, WARD 4
DONNIE PETERS JR.	MEMBER, WARD 5
DAVID K. MCCUNE	MEMBER, WARD 6
PAUL MANSON	MEMBER AT LARGE
LARRY SLAGLE	MEMBER AT LARGE
DAVID HERSHER	MEMBER AT LARGE
MARY BETH BAILEY	CLERK

APPROVED BY:

Keith A. Dylewski
KEITH A. DYLEWSKI P.E. P.S.
CITY ENGINEER

3/11/11
DATE

Michael Loudiana
MICHAEL LOUDIANA
DIRECTOR OF PUBLIC SERVICE AND SAFETY

3/14/11
DATE



UNDERGROUND UTILITIES


TWO WORKING DAYS
BEFORE YOU DIG
Call 800-362-2764 (Toll Free)
OHIO UTILITIES PROTECTION SERVICE
NON-MEMBERS
MUST BE CALLED DIRECTLY

THIS DRAWING IS AN INSTRUMENT OF SERVICE OWNED
BY CTI ENGINEERS, INC. WHICH SHALL BE DEEMED
THE AUTHOR AND WHICH SHALL RETAIN ALL STATUTORY
AND COMMON LAW RIGHTS, INCLUDING COPYRIGHTS.
THIS DRAWING SHALL NOT BE SCANNED, COPIED, OR
DISTRIBUTED TO OTHERS IN ANY FORM OR USED FOR
ANY OTHER PURPOSE OR PROJECT WITHOUT PRIOR
WRITTEN CONSENT OF CTI ENGINEERS, INC.
CTI ENGINEERS, INC. CANNOT GUARANTEE THAT
ELECTRONIC COPIES OF THIS DRAWING ARE EXACT
DUPLICATES OF THE SEALED ORIGINAL DRAWING.
IN THE EVENT OF A CONFLICT BETWEEN AN ELECTRONIC
COPY AND THE SEALED ORIGINAL, THE SEALED ORIGINAL
SHALL GOVERN.


ABBREVIATIONS

A AB ACP ADJT AFF ALT ALUM AT ASPH AUTO AVG	ANCHOR BOLT ASBESTOS CEMENT PIPE ADJUSTABLE ABOVE FINISHED FLOOR ALTERNATIVE ALUMINUM AT ASPHALT AUTOMATIC AVERAGE	G GA GAL GALV GEN GRD	GAS GAUGE OR GAGE GALLON GALVANIZED GRAVITY BELT THICKENER GENERAL GRADE OR GRADING	Q QUAN	QUANTITY
B BIP BF BFP BLDG BLK BM BOS BOT BRG	BLACK IRON PIPE BLIND FLANGE OR BOTTOM FACE BELT FILTER PRESS BUILDING BLOCK BENCHMARK BOTTOM OF SLAB BOTTOM BEARING	H HB HC HDPE HE HK HM HORIZ HP HPT HS HT HU HVAC	HOSE BIBB HOLLOW CORE HIGH DENSITY POLYETHYLENE HEAT EXCHANGER HOOK(S) HOLLOW METAL HORIZONTAL HORSEPOWER HIGH POINT HIGH SERVICE HEATING UNIT HEATING/VENTILATION AIR CONDITIONING HIGH WATER LEVEL HOT WATER HOT WATER RETURN HOT WATER SUPPLY	R RAD RAS RB RCP RD RECIRC RED REINF REQ'D RM RT R/W	RISE RADIUS RETURNED ACTIVATED SLUDGE ROOF BEAM REINFORCED CONCRETE PIPE ROOF DRAIN RECIRCULATION REDUCER REINFORCING REQUIRED ROOM RIGHT RIGHT OF WAY
C CB CF CFM CI CIP C, C/L C/C CL CLG CMP CMU CO COL CON CONC CONIN CPR CU CONTR JT CONST CONT CPLG CTRL CW CY	CHEMICAL CATCH BASIN CUBIC FEET CUBIC FEET PER MINUTE CAST IRON CAST IRON PIPE CENTERLINE CENTERLINE TO CENTERLINE CLEAR CEILING CORRUGATED METAL PIPE CONCRETE MASONRY UNIT CLEAN OUT COLUMN CONCENTRIC CONCRETE CONNECTION COPPER CONSTRUCTION JOINT CONTRACTION JOINT CONSTRUCTION CONTINUOUS COUPLING CONTROL COLD WATER CUBIC YARD	I ID IF IJ IN INFL INT INV IP JT LB LG LL LLH LLV LPT LR LS LT LTG LWL	INSIDE DIAMETER INSIDE FACE ISOLATION JOINT INCHES INFLUENT INTERIOR INVERT IRON PIN JOINT POUND LENGTH LIVE LOAD LONG LEG HORIZONTAL LONG LEG VERTICAL LOW POINT LONG RADIUS LOW SERVICE LEFT LIGHTING LOW WATER LEVEL	S SAN SCH SEC SF SHT SJ SIM SPC SPEC SPG SQ S STL ST STA STD STIR STL STR STM SUP SY SYM SW	SLAB, SOUTH SANITARY SCHEDULE SECTION SQUARE FEET SHEET SAW JOINT SIMILAR SPACES SPECIFICATION SPACING SQUARE STAINLESS STEEL STRAIGHT STATION STANDARD STIRRUPS STEEL STRUCTURAL STORM SEWER SUPERWATENT SQUARE YARD SYMMETRICAL SWITCH
D D DEMO DIA, Ø DIAG DIG DIM DIP DISCH D.L. DO DSL DS DTL DWG	DRAIN DEMOLITION DIAMETER DIAGONAL DIGESTED DIMENSION DUCTILE IRON PIPE DISCHARGE DEAD LOAD DOOR OPENING, DISSOLVED OXYGEN MIN DIGESTED SLUDGE DOWN SPOUT OR DICONNECT SWITCH DETAIL DRAWING	M MCC MFR MG MGD MH MISC MIN MJ MK MO	MAXIMUM MOTOR CONTROL CENTER MANUFACTURER MILLION GALLONS MILLION GALLONS PER DAY MANHOLE MISCELLANEOUS MINIMUM MECHANICAL JOINT MARK MASONRY OPENING OR MOTOR OPERATED	T TBM TF THK THKD T TOB TOC TOS T&B TC T&G TP	TEMPORARY BENCHMARK TOP FACE THICKNESS THICKENED TOP TOP OF BANK OR TOP OF BLOCK TOP OF CONCRETE TOP OF SLAB TOP AND BOTTOM TOP OF COVER TONGUE AND GROOVE TURNING POINT OR TANGENT POINT TRANSFER TYPICAL
E EA ECC ED EF EFFL ELEC EL ELB EQ EW EXIST EJ EXP EXT	EAST EACH ECCENTRIC EQUIPMENT DRAIN EACH FACE EFFLUENT ELECTRICAL ELEVATION ELBOW EQUAL EACH WAY EXISTING EXPANSION JOINT EXPOSED EXTERIOR	N NC NF NO NPW NTS NWL	NORTH NORMALLY CLOSED NEAR FACE NORMALLY OPEN NUMBER NON-POTABLE WATER NOT TO SCALE NORMAL WATER LEVEL	U UE UT V VAR VCP VERT	UNDERGROUND ELECTRIC UNDERGROUND TELEPHONE VACUUM VARIES VITRIFIED CLAY PIPE VERTICAL
F FA FB FD FDN FE FF FH FIBREINFP FIG FIN FLG FLR FLRET FM FRP FT FTG	FRESH AIR FLOOR BOX OR FOUNDATION BEAM FLOOR DRAIN FOUNDATION FIRE EXTINGUISHER FINISHED FLOOR FIRE HYDRANT FIBERGLASS REINFORCED POLYMERS FIGURE FINISHED FLANGE FLOOR FLOW RETENTION FORCE MAIN FIBERGLASS REINFORCED PLASTIC PIPE FEET OR FOOT FOOTING	O OC OD OF OH OPG OPP OZ	ON CENTER OUTSIDE DIAMETER OUTSIDE FACE OVERHEAD OPENING OPPOSITE OUNCE	W WAS W W/O WC WD WH WHA WL WWF	WASTE ACTIVATED SLUDGE WATER OR WIDE WITH WITHOUT WATER CLOSET WOOD WATER HEATER WATER HAMMER ARRESTER WATER LEVEL OR WATER LINE WELDED WIRE FABRIC
P POF POP PE PEJM PL PLCS PLT PNL POT PP PROP PS PSF PSI PVC PVMT PW PWD	POUNDS PER CUBIC FOOT PUMP CONTROL PANEL PLAIN END PREMOLDED EXP. JT. MATERIAL PLATE PLACES PLANT PANEL POTABLE POLYPROPYLENE PRESTRESSED REINFORCED CONCRETE PIPE PROPOSED PUMP STATION POUNDS PER SQUARE FOOT POUNDS PER SQUARE INCH POLYVINYL CHLORIDE PAVEMENT POTABLE WATER PLYWOOD	Y YH	YARD HYDRANT	TRANS TYP	


SECTION DESIGNATIONS

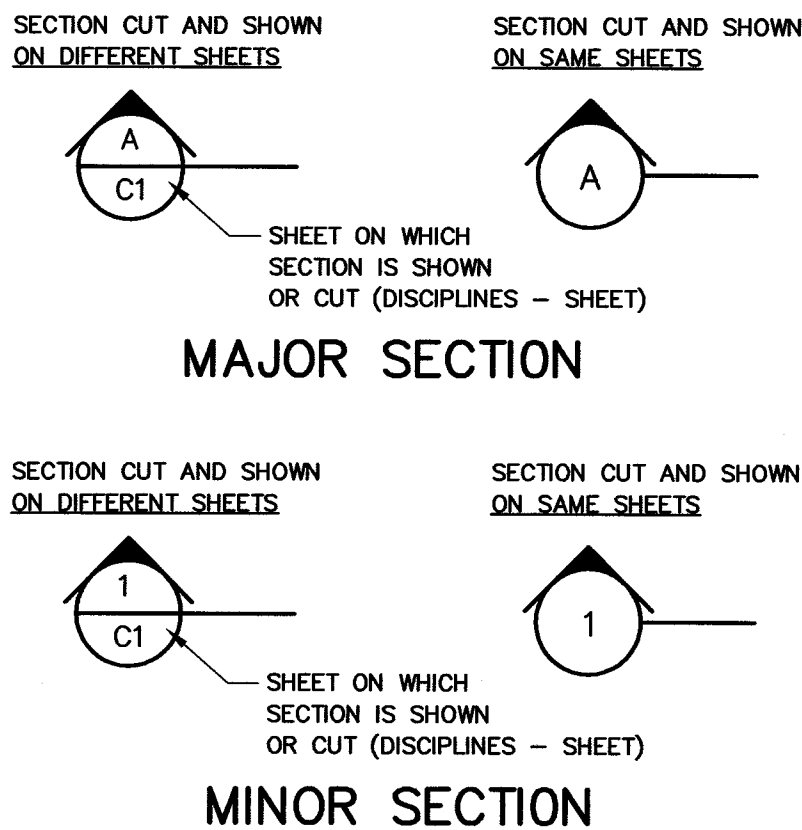

SITE PLAN SYMBOLS

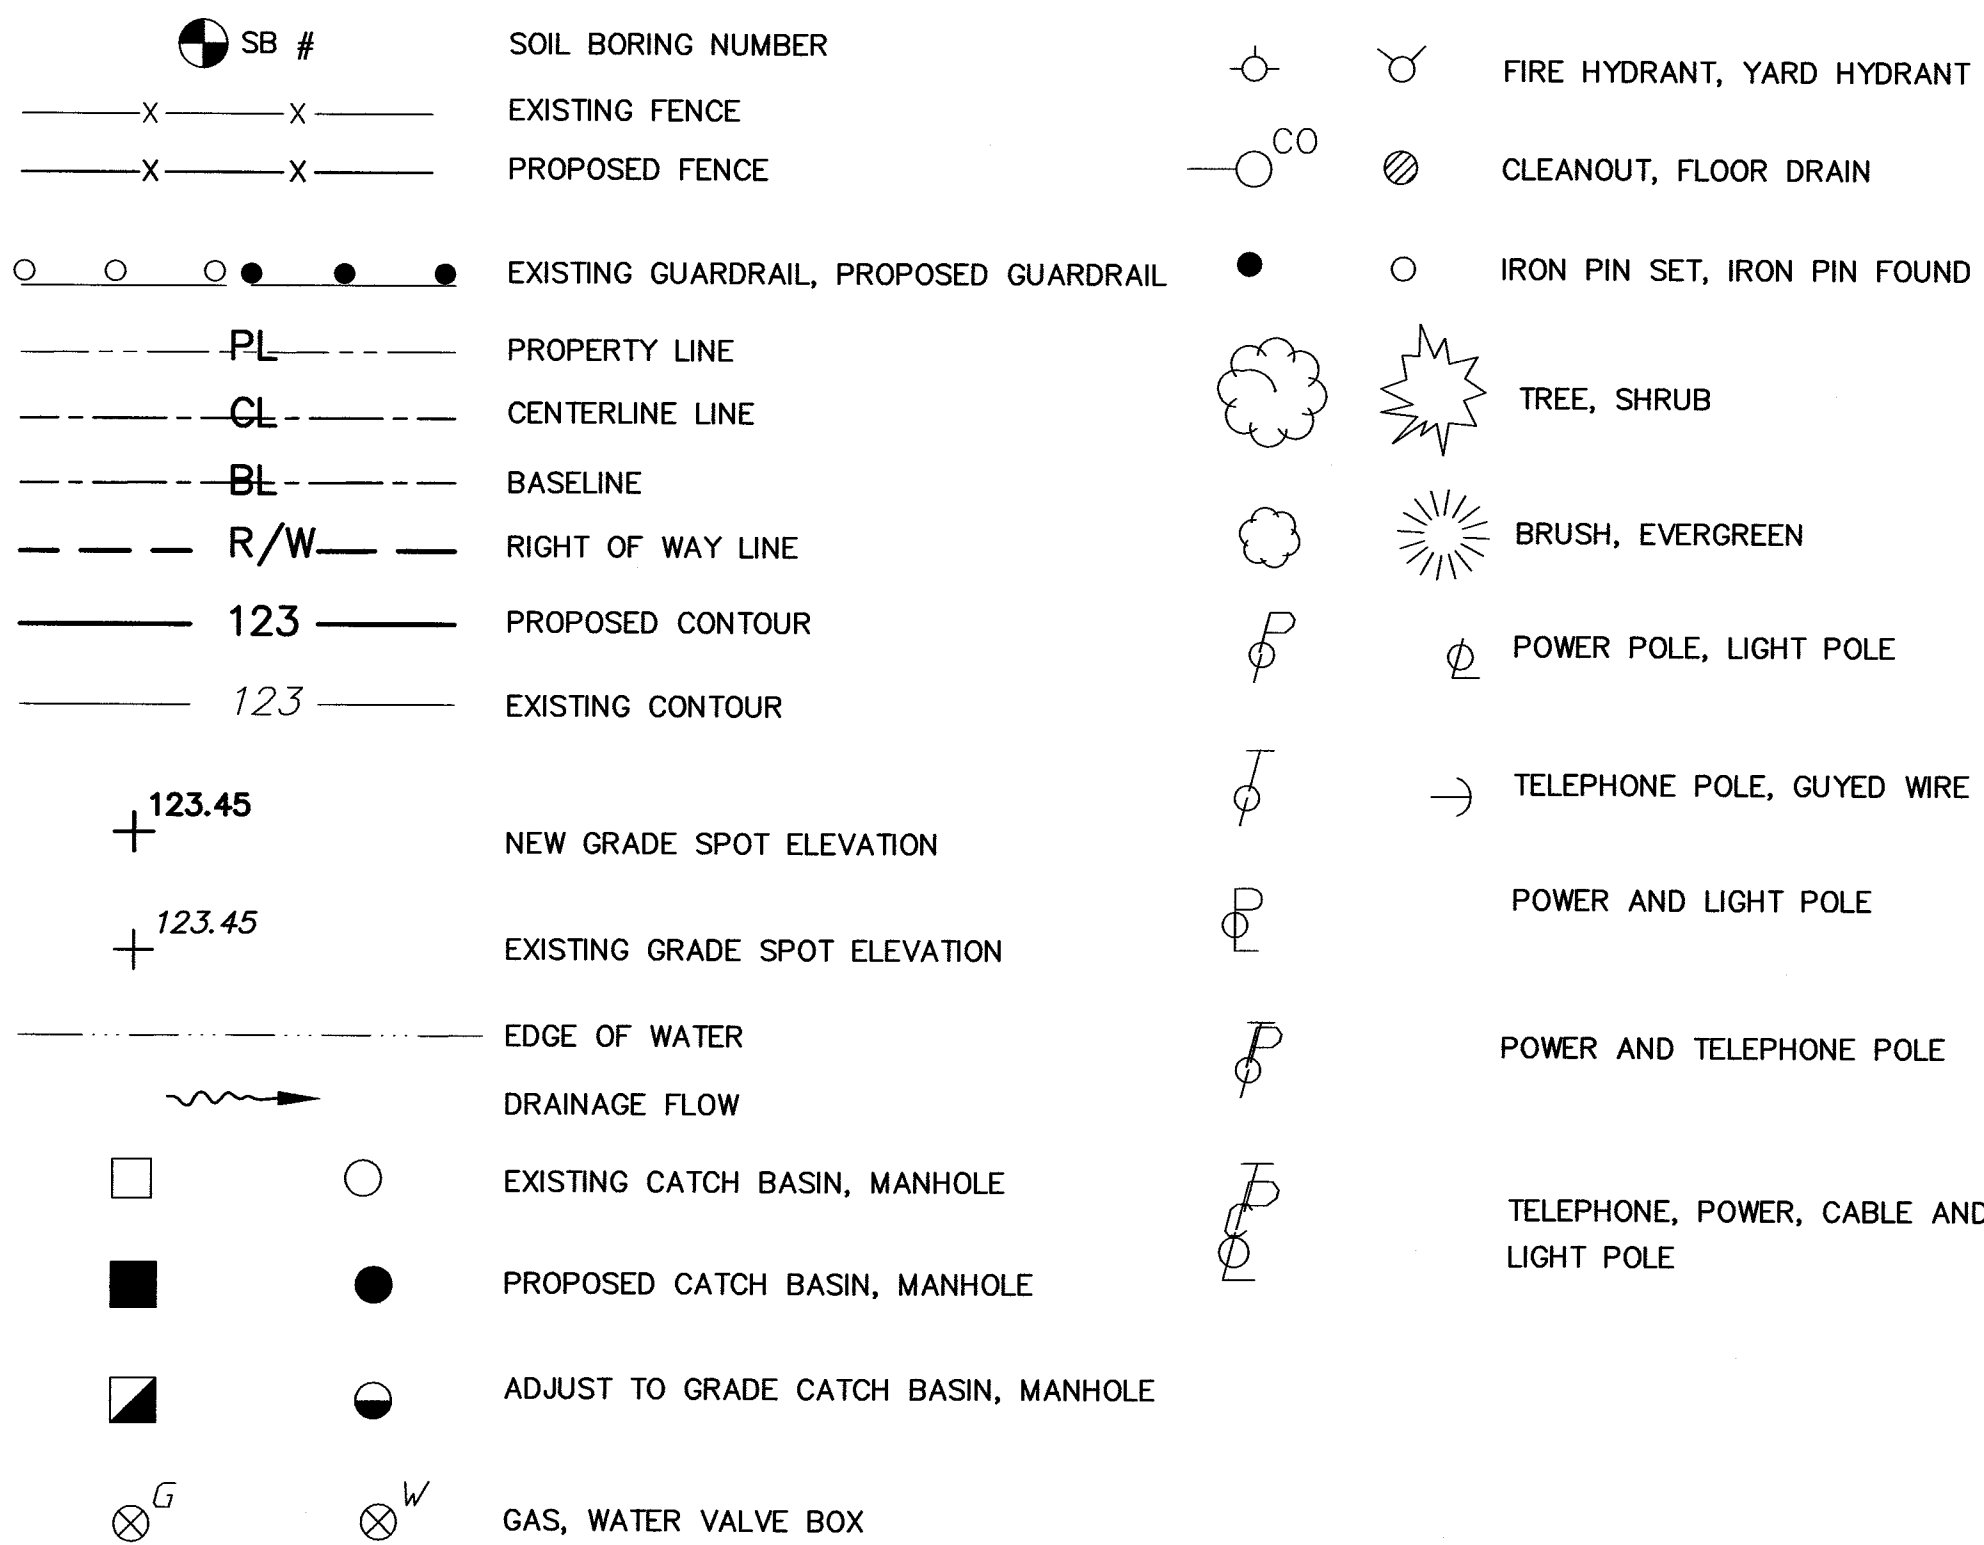

STRUCTURAL/ARCHITECTURAL LEGEND

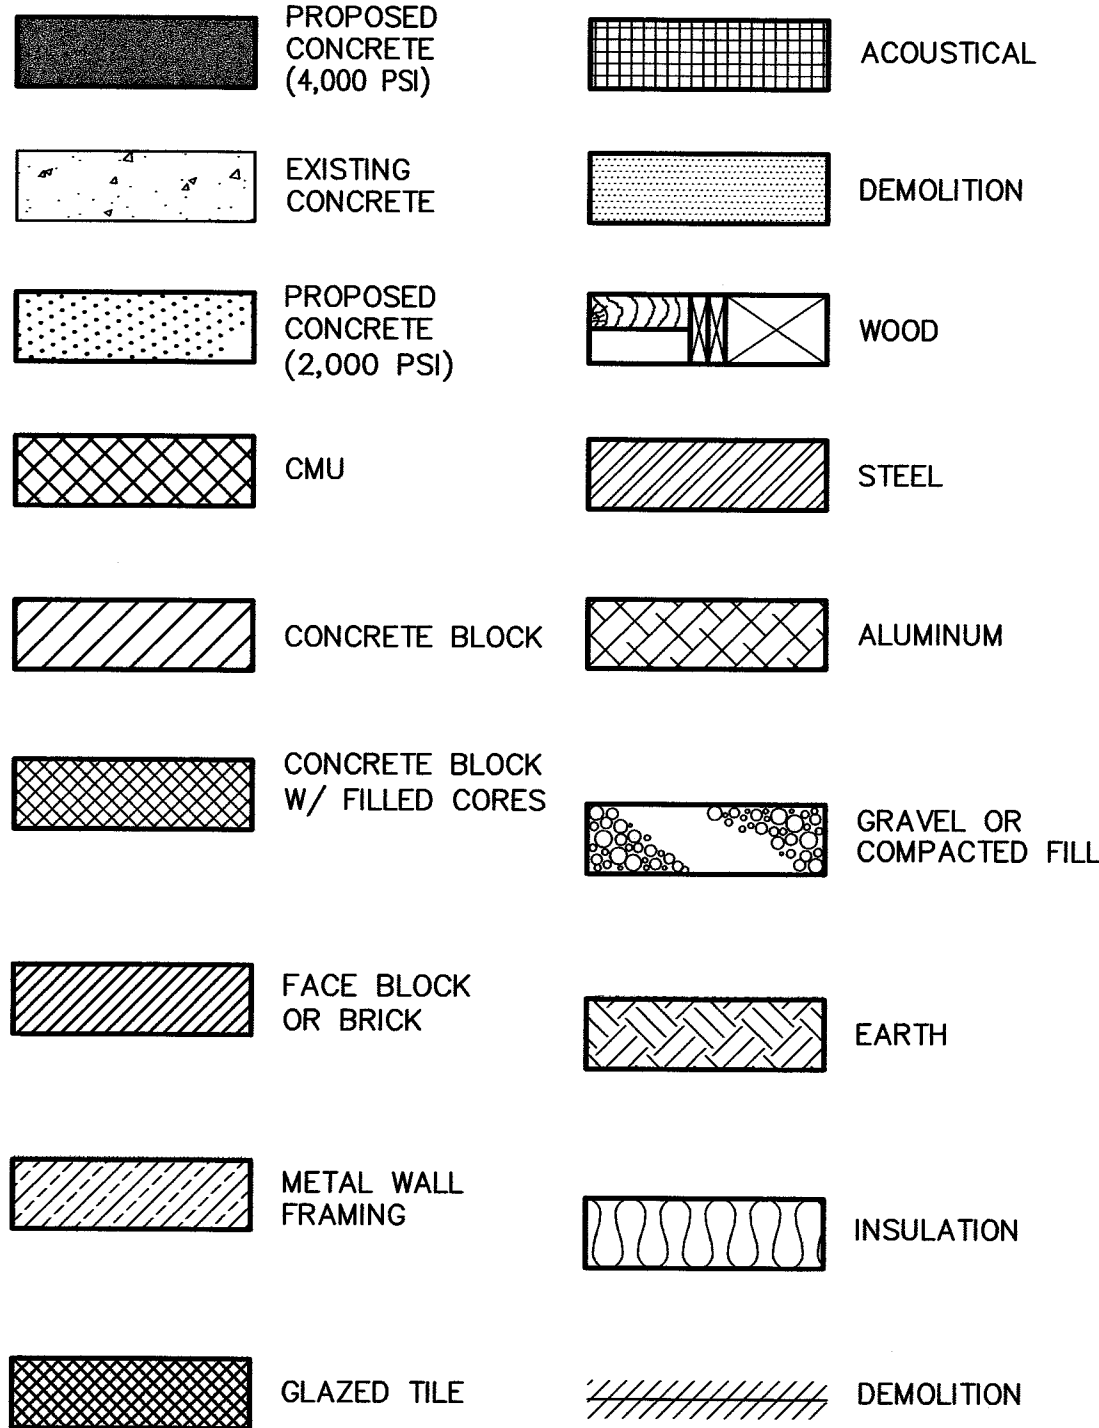

TEXT LEGEND


EXISTING TEXT

PROPOSED TEXT


SLANTED AND LIGHTER TEXT - EXISTING FEATURES

UPRIGHT AND BOLDER TEXT - PROPOSED WORK


TWO LINE PIPING SYMBOLS

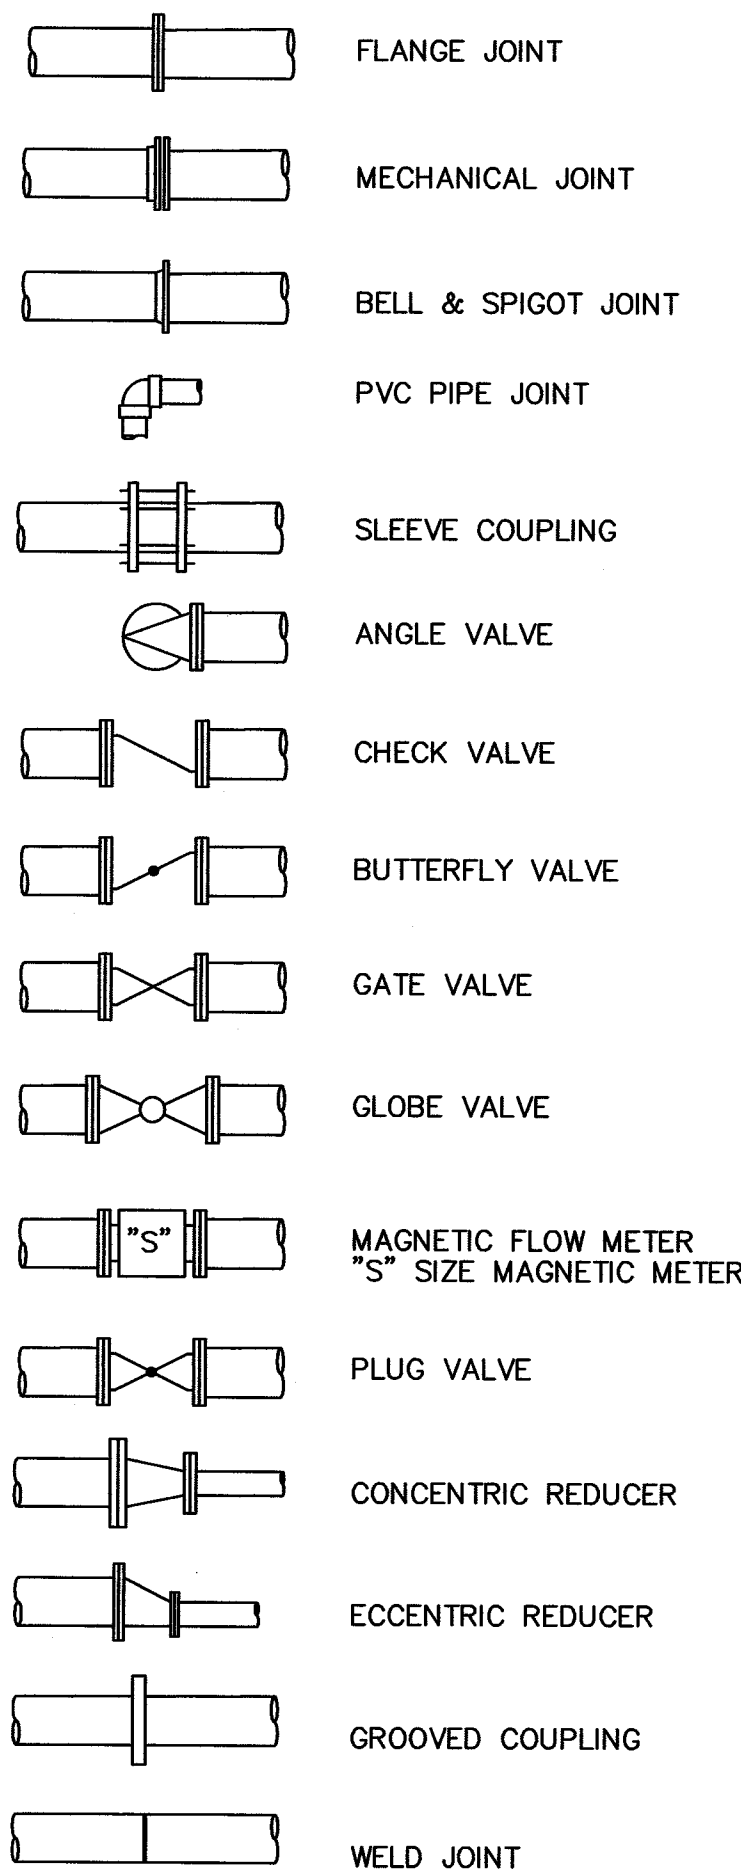

PAVING LEGEND

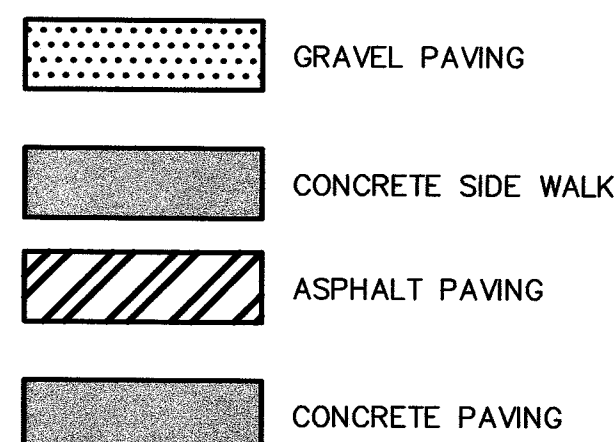

CALL OUTS

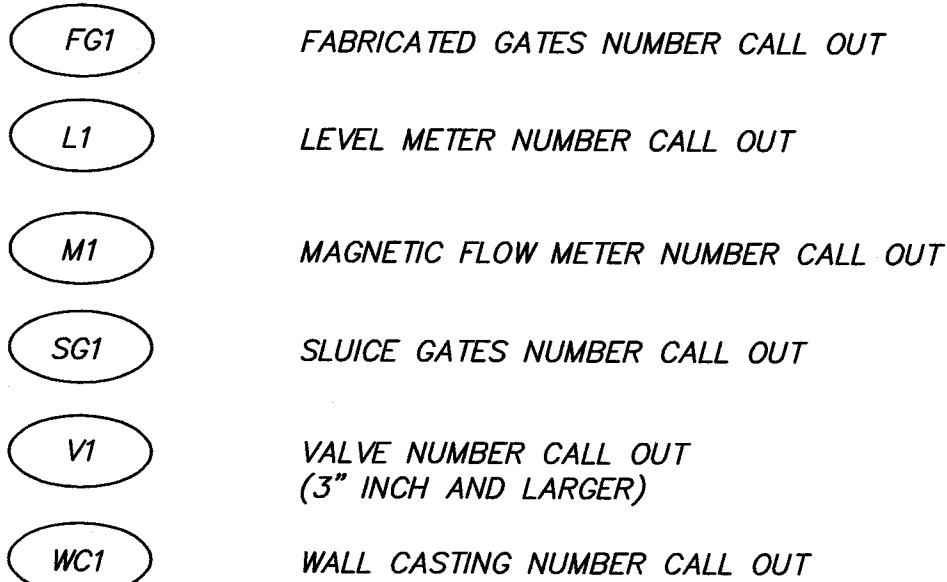

THIS DRAWING IS AN INSTRUMENT OF SERVICE OWNED BY C.T.I. ENGINEERS, INC. WHICH SHALL BE DEEMED TO HAVE BEEN LOANED TO THE CLIENT FOR THE PROJECT AND COMMON LAW RIGHTS, INCLUDING COPYRIGHTS, IN THIS DRAWING SHALL NOT BE SCANNED, COPIED, OR REPRODUCED IN ANY MANNER WITHOUT THE WRITTEN CONSENT OF C.T.I. ENGINEERS, INC. THAT ELECTRONIC COPIES OF THIS DRAWING ARE EXACT DUPLICATES OF THE SEALED ORIGINAL DRAWING. THIS DRAWING IS NOT TO BE USED FOR ANY OTHER PROJECT WITHOUT THE WRITTEN CONSENT OF C.T.I. ENGINEERS, INC. THE SEALED ORIGINAL DRAWING SHALL GOVERN.

DESIGNED BY	TMK	DRAWN BY	AJP	CHECKED BY	TMK	APPROVED BY	RWR
NO.		DATE		DATE		DATE	
DESCRIPTIONS							

CITY OF MASSILLON, OHIO
WWTP IMPROVEMENTS

AERATION TANK RECYCLE
ABBREVIATIONS AND SYMBOLS



C.T.I. ENGINEERS, INC.
191 CENTRAL PLAZA SOUTH, SUITE 400
SANDUSKY, OH 44870
(334) 697-0301

JOB NO.
E11004

DATE
2/16/2011

SCALE
NOT TO SCALE

SHEET NO
C2

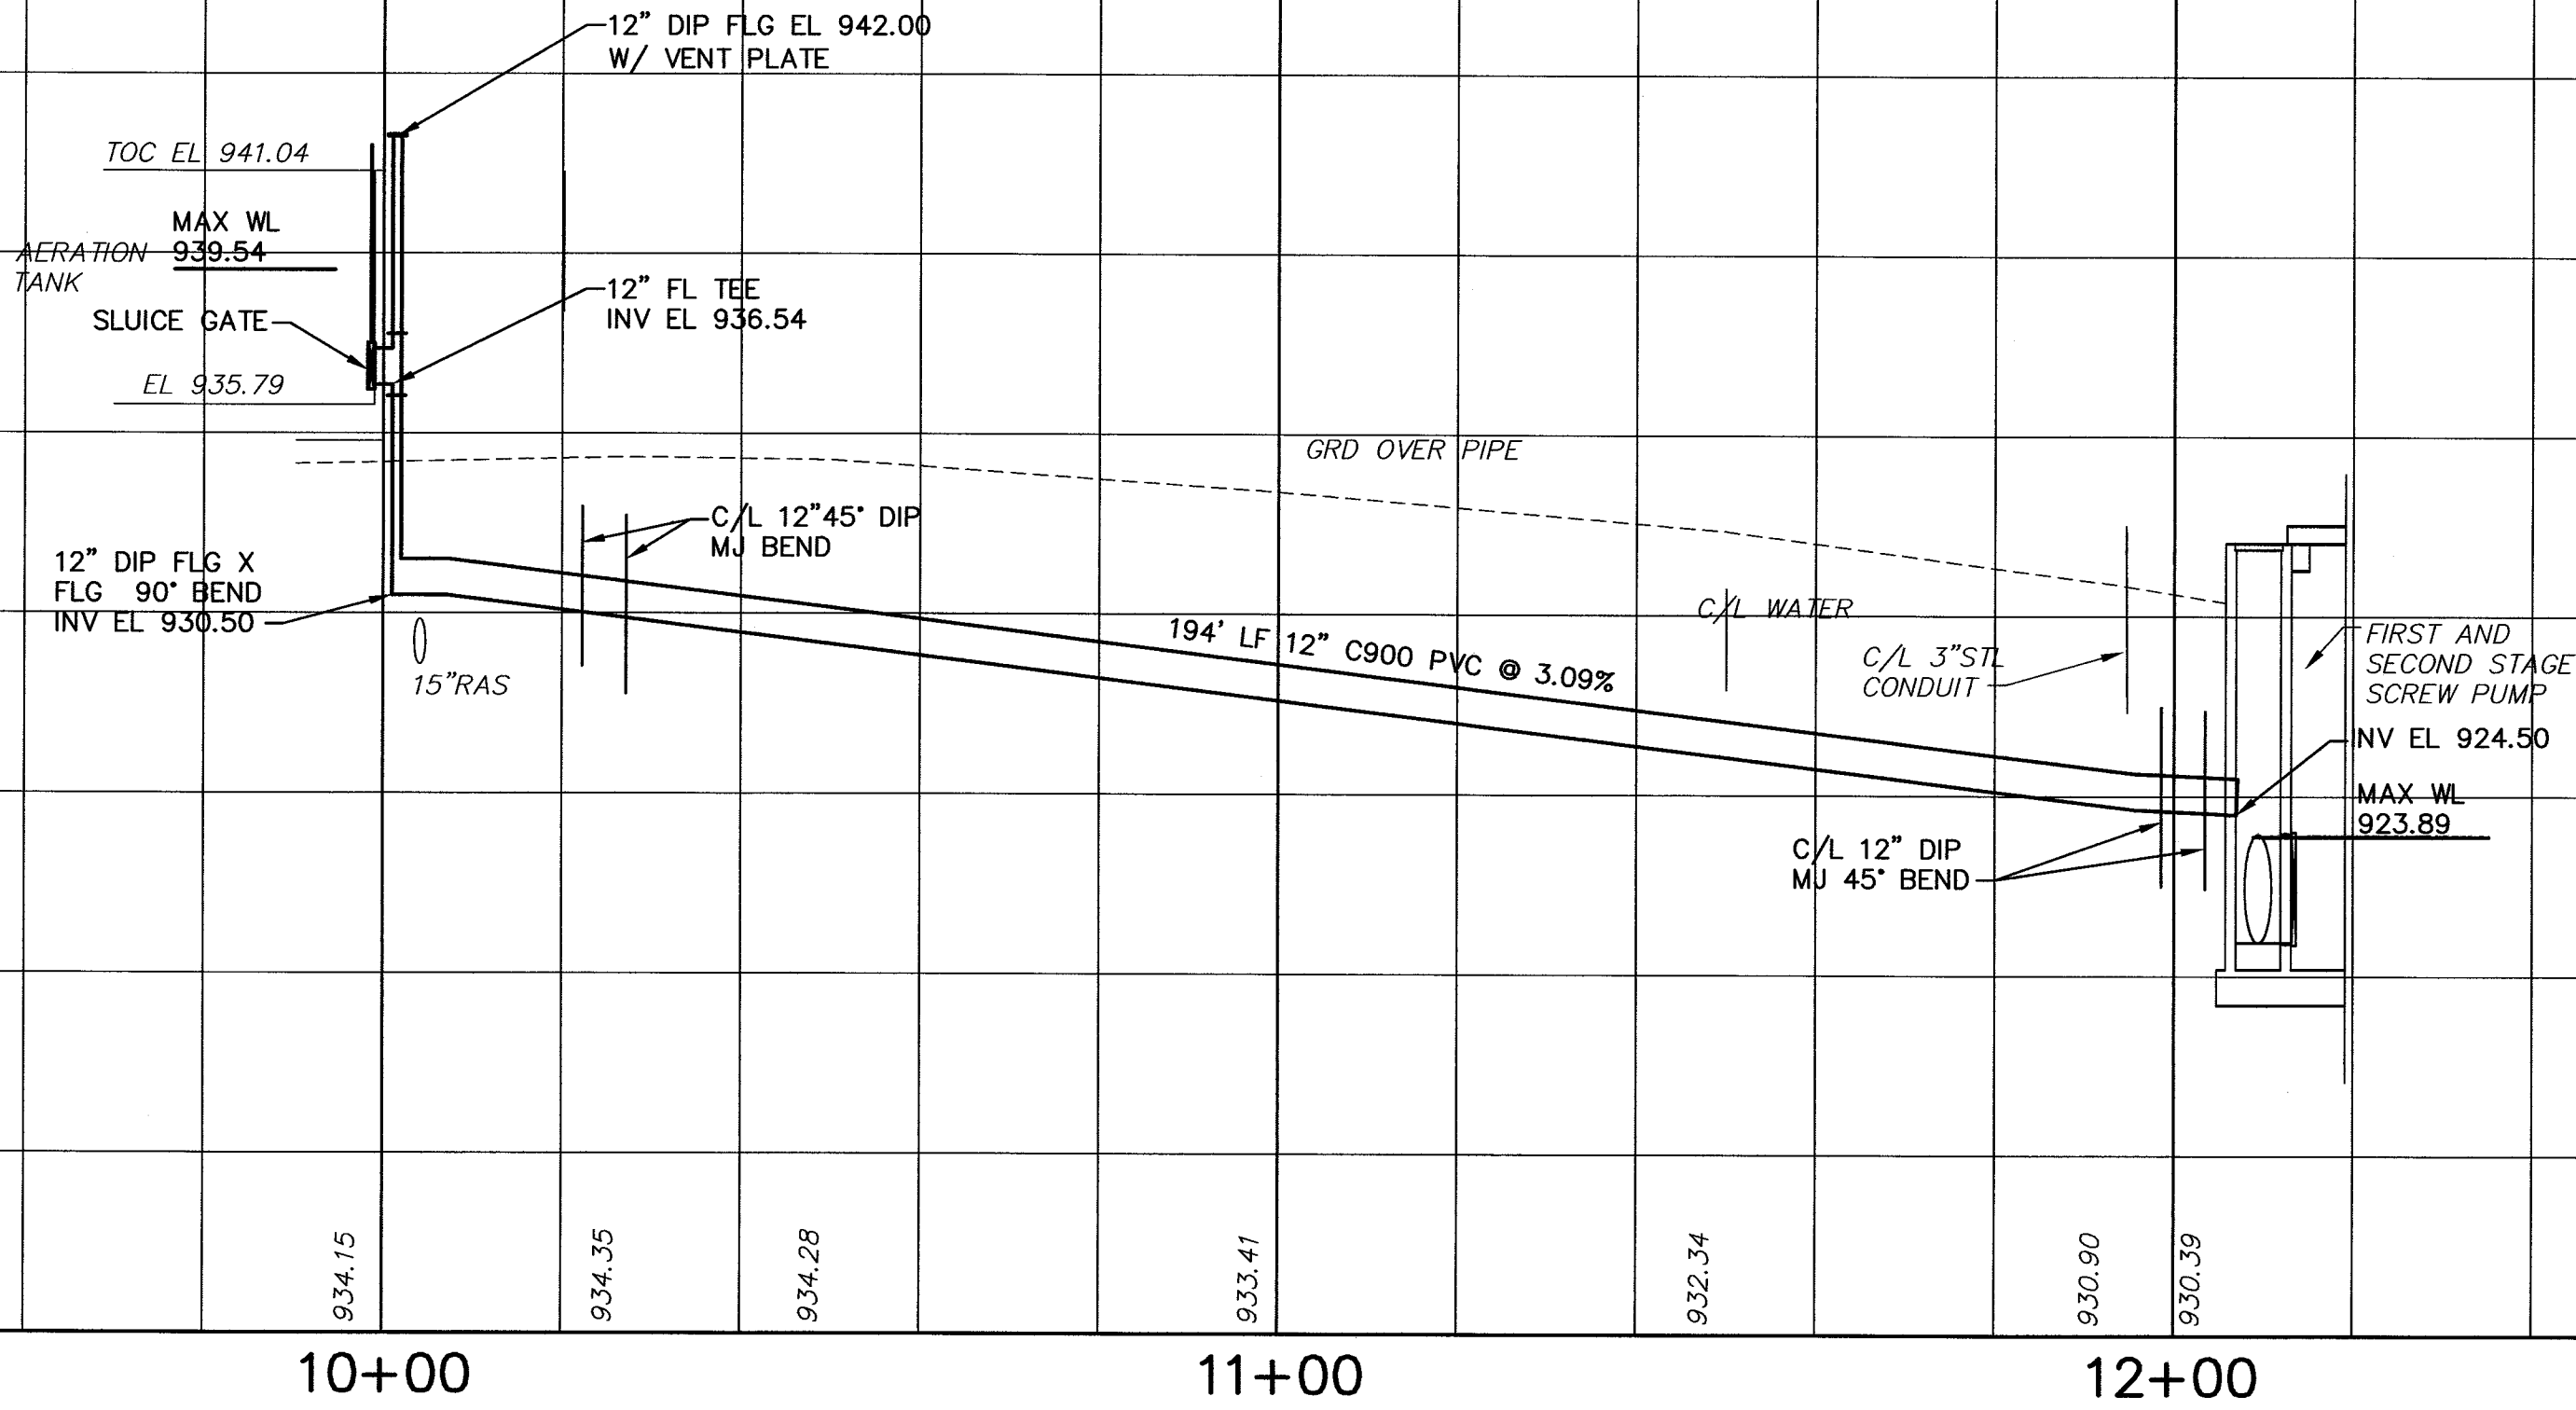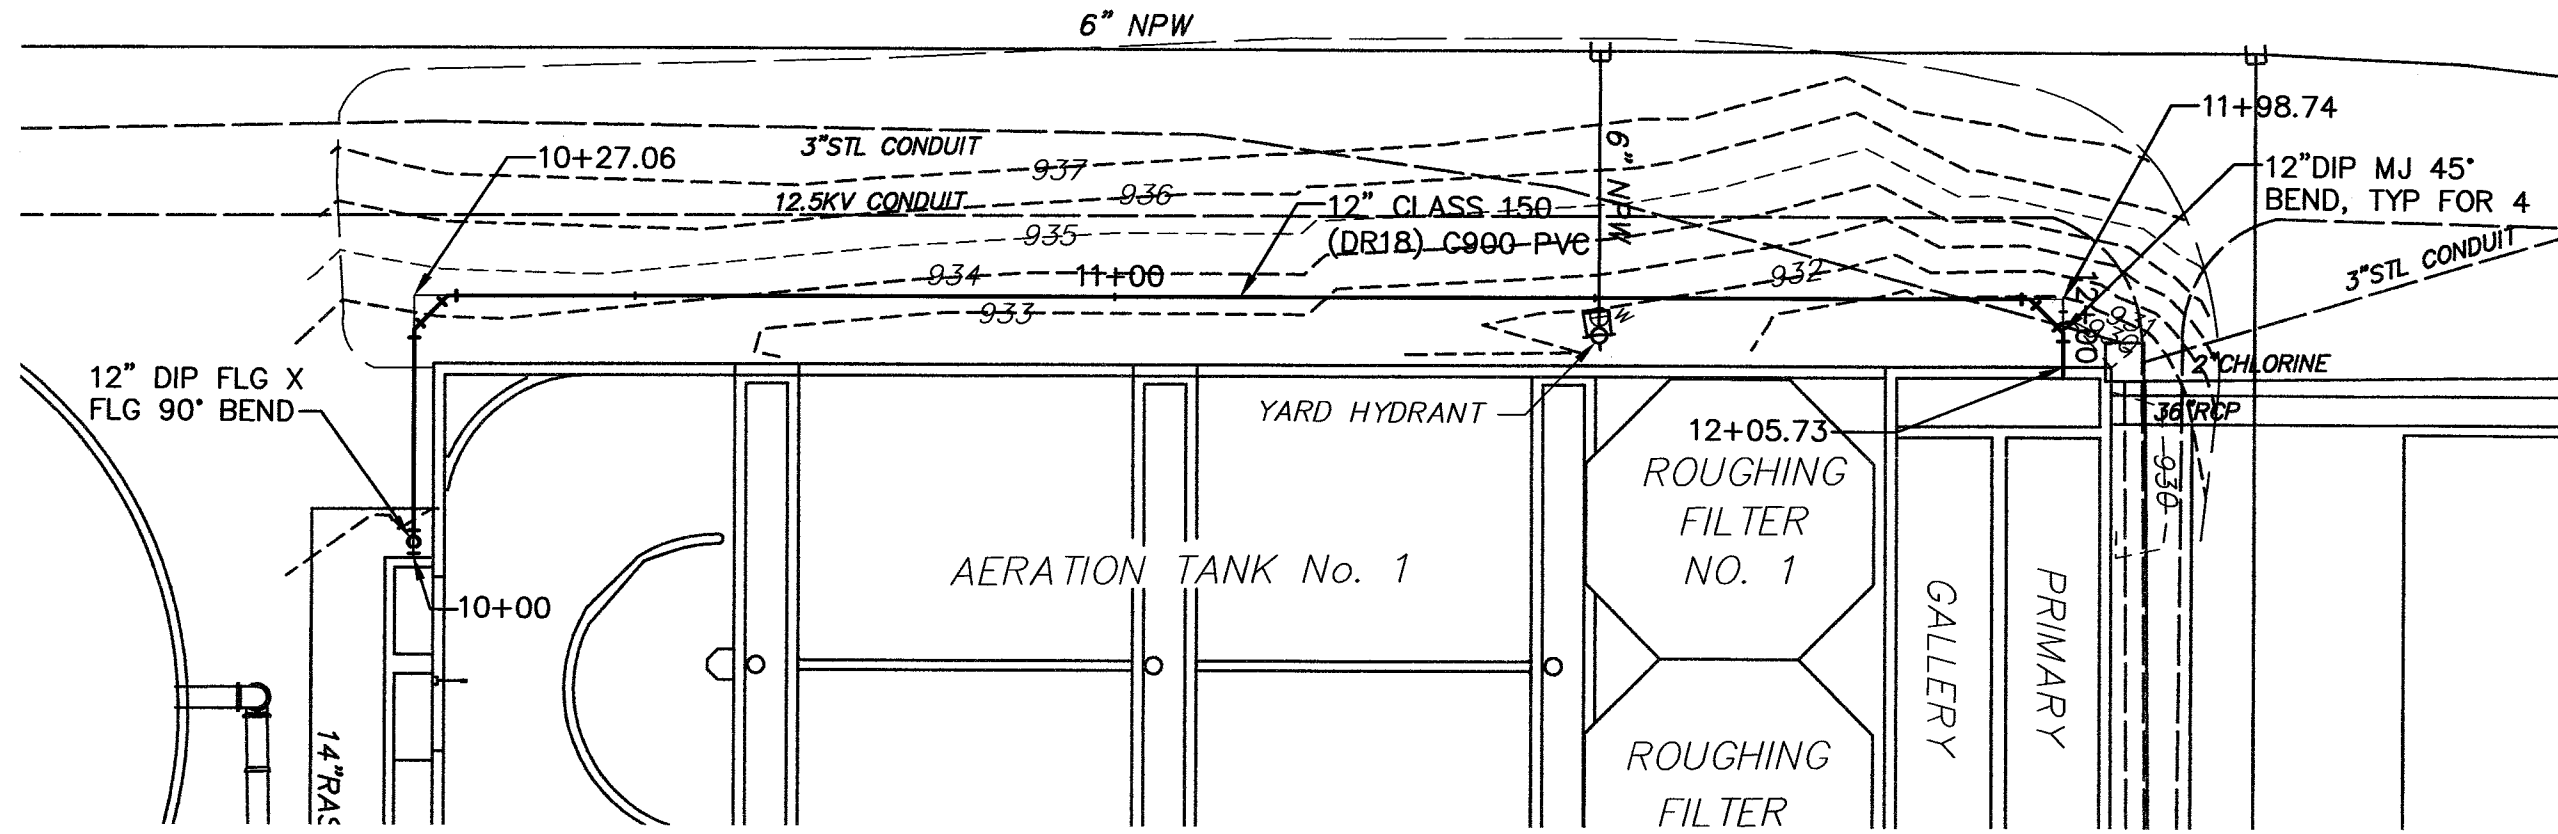

HORIZONTAL SCALE 

VERTICAL SCALE 

 501 CENTRAL PLAZA SUITE 400 BOSTON, MA 02102 338-455-7733 JOB NO. E11004 DATE 2/16/2011 SCALE AS NOTED SHEET NO C3 CITY OF MASSILLON, OHIO WWTP IMPROVEMENTS AERATION TANK RECYCLE PLAN AND PROFILE DESIGNED BY TMK/AJP NO. DESCRIPTIONS DATE BY APP'D						
	DRAWN BY AJP					
	CHECKED BY TMK					
	APPROVED BY RWR					

BY DRAWING AN INSTRUMENT OF SERVICE OWNED BY CITIZENS OF MASSACHUSETTS, THIS DRAWING AND WHICH SHALL RETAIN ALL STATUTORY AND OTHER RIGHTS OF THE ENGINEER OR ARCHITECT. THIS DRAWING SHALL NOT BE REPRODUCED, COPIED, OR TRANSMITTED IN ANY MANNER WITHOUT THE WRITTEN CONSENT OF CITI ENGINEERS, INC. ANY OTHER PURPOSE OR PROJECT FOR WHICH USED FOR ANY OTHER PROJECT OR THAT THE ELECTRONIC COPIES OF THIS DRAWING ARE EXACT REPRODUCTIONS OF THE ORIGINAL DRAWING. IN THE EVENT OF A CONFLICT BETWEEN THE ELECTRONIC COPY AND THE SEALED ORIGINAL, THE SEALED ORIGINAL SHALL GOVERN.

