




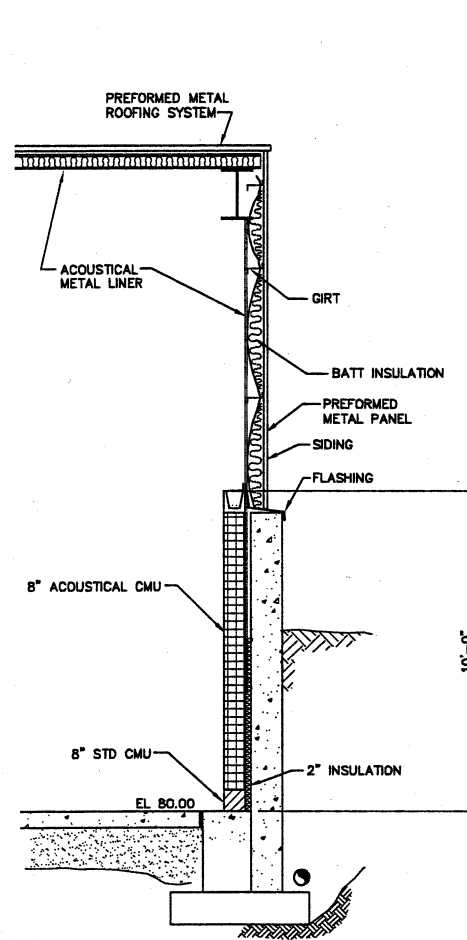

SECTION E
SCALE: 3/8"=1'-0" A9,10,11

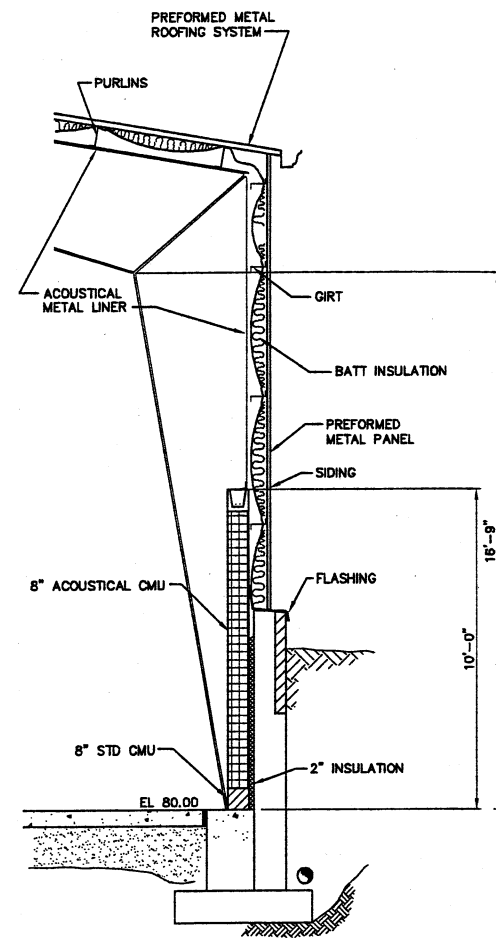

SECTION D
SCALE: 3/8"=1'-0" A9,10,11

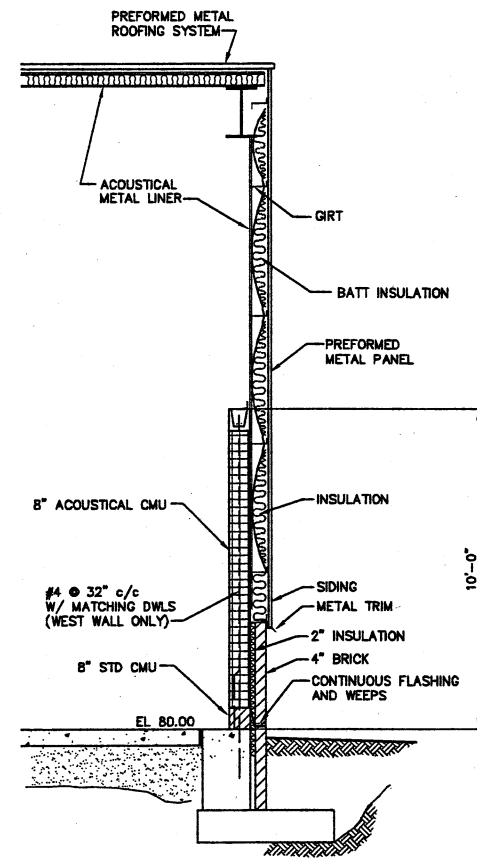

SECTION C
SCALE: 3/8"=1'-0" A9,10,11

ENVIRONMENTAL, INC.
ENGINEERS IN WATER AND EARTH SCIENCES
UNIONTOWN, OHIO

CITY OF MASSILLON, OHIO
WWTP UPGRADE 2000
BLOWER BUILDING WALL SECTIONS

IPS
FINKBEINER, PETTIS & STROUT, INC.
ENGINEERS SINCE 1900
520 SOUTH MAIN STREET
AKRON, OHIO 44324

DESIGNED BY		DRAWN BY		CHECKED BY		APPROVED BY		REVISIONS	
								NO.	DESCRIPTIONS

JOB NO. E9031
DATE 8/13/01
SCALE AS NOTED
SHEET A13