



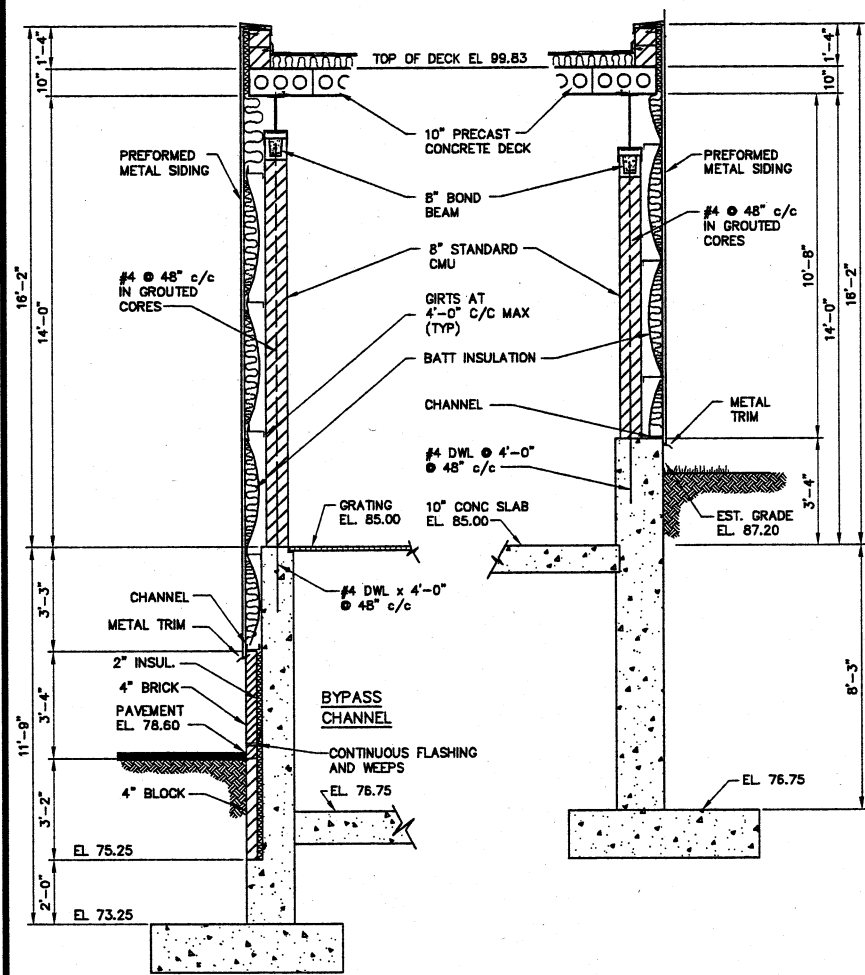


SECTION C
SCALE: 3/8"=1'-0"


SECTION D
SCALE: 3/8"=1'-0"

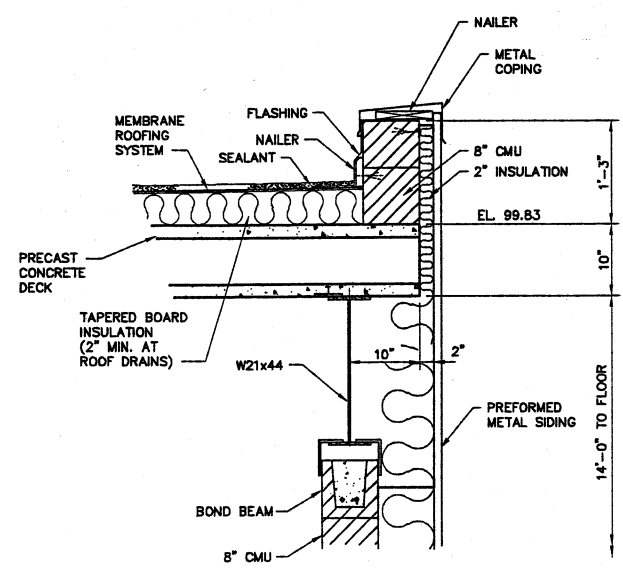


SECTION 1
SCALE: 1"=1'-0"

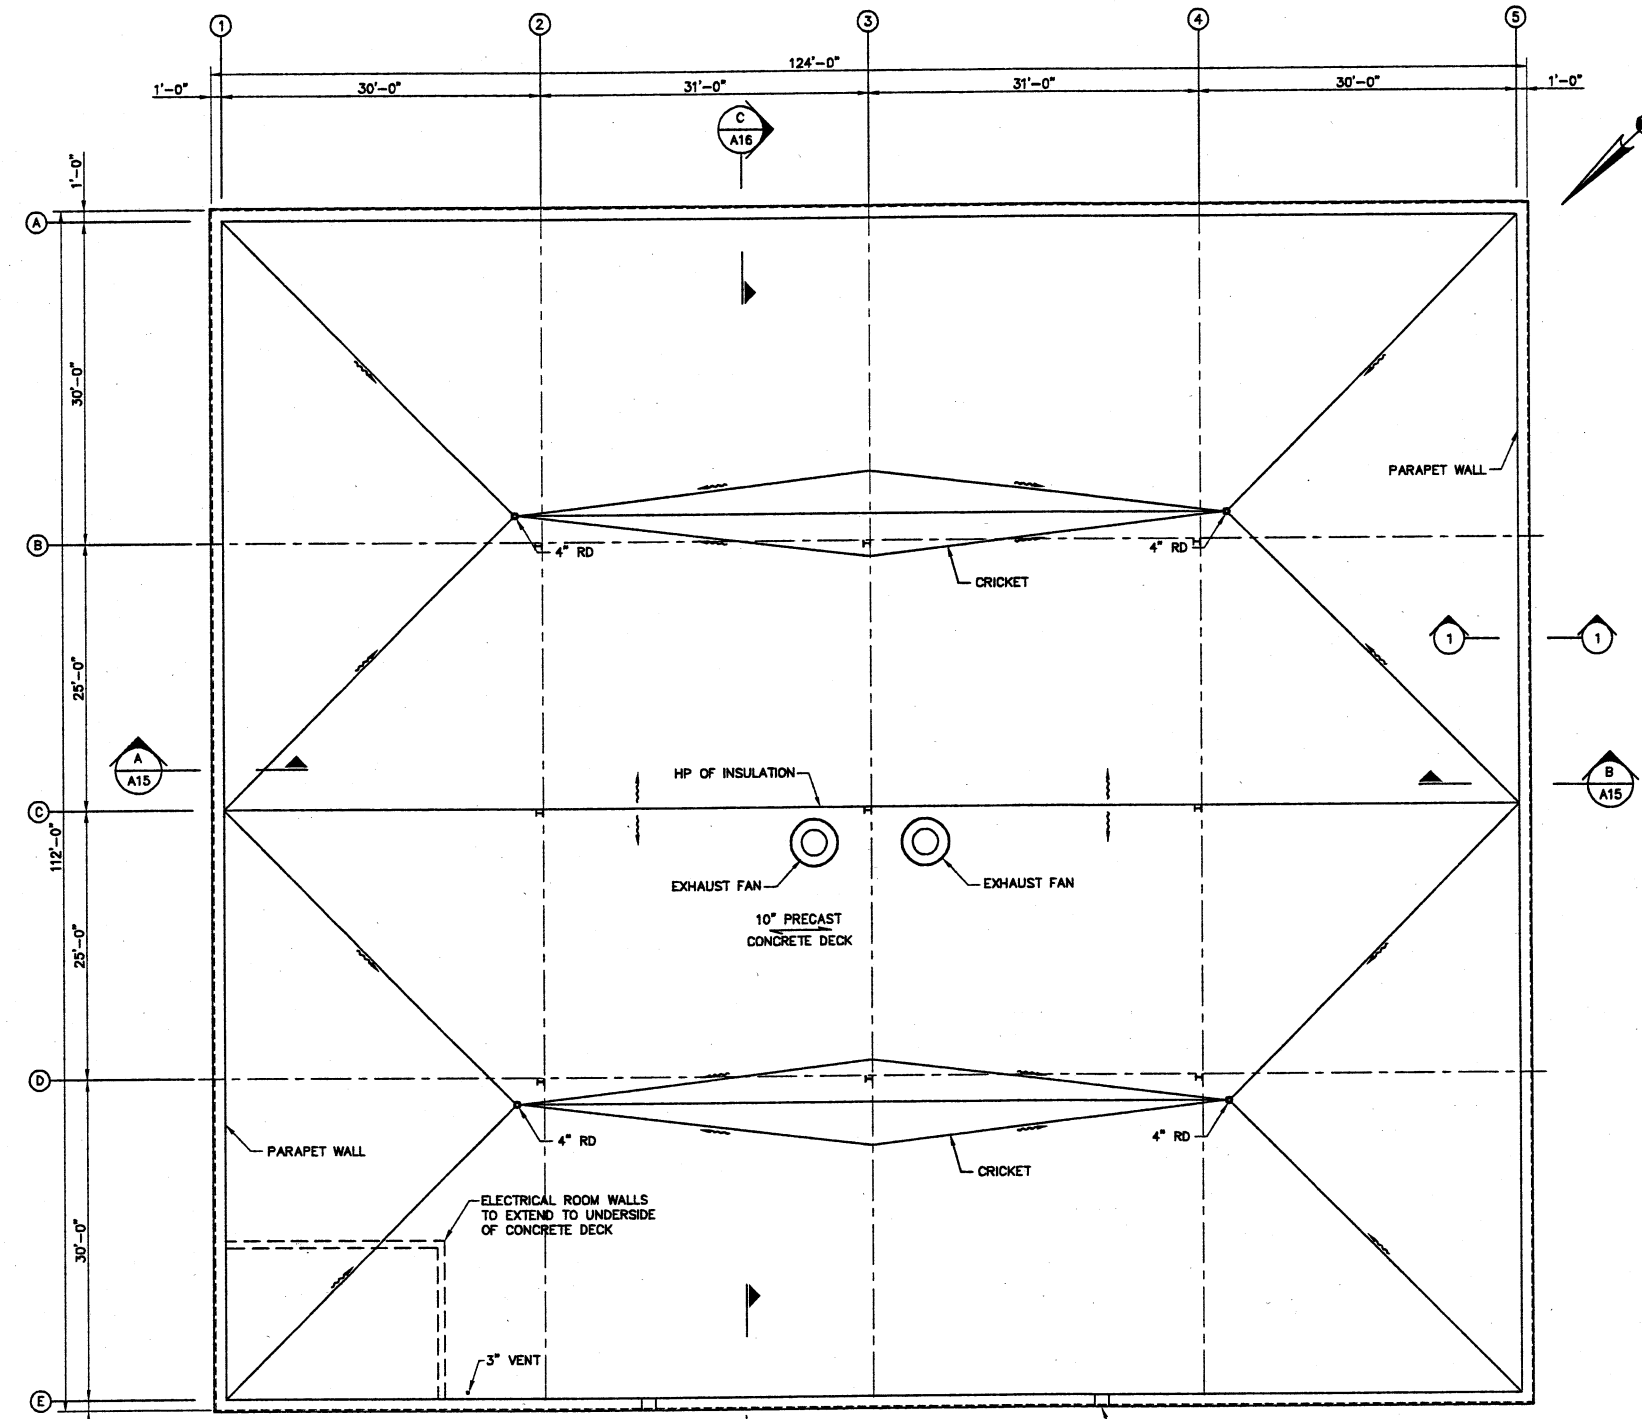

ROOF PLAN
SCALE: 1/8"=1'-0"

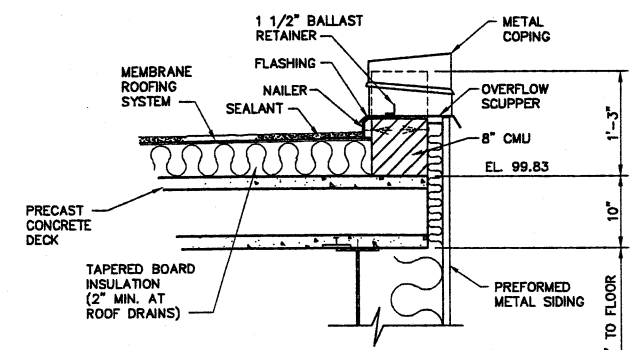

OVERFLOW SCUPPER DETAIL
SCALE: 1"=1'-0"

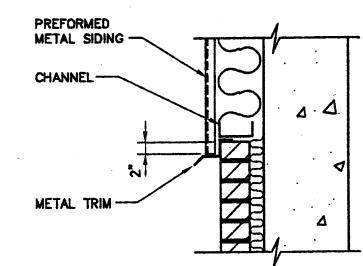

METAL SIDING OVERHANG DETAIL
SCALE: 1"=1'-0"

FPS
FINKBEINER, PETTIS & STROUT, INC.
ENGINEERS SINCE 1900
520 SOUTH MAIN STREET
AKRON, OHIO 44324

NO.	DESCRIPTIONS	DATE	BY	APP'D
DESIGNED BY	GLB			
DRAWN BY	CAS/MNH			
CHECKED BY	JLS			
APPROVED BY	DUK			

CTI ENVIRONMENTAL, INC.
ENGINEERS IN WATER AND EARTH SCIENCES
UNIONTOWN, OHIO
CITY OF MASSILLON, OHIO
WWTP UPGRADE 2000
TERTIARY FILTER AND UV DISINFECTION BUILDING
ROOF PLAN AND WALL SECTIONS

JOB NO.	E9031
DATE	8/13/01
SCALE	AS NOTED
SHEET	A16