


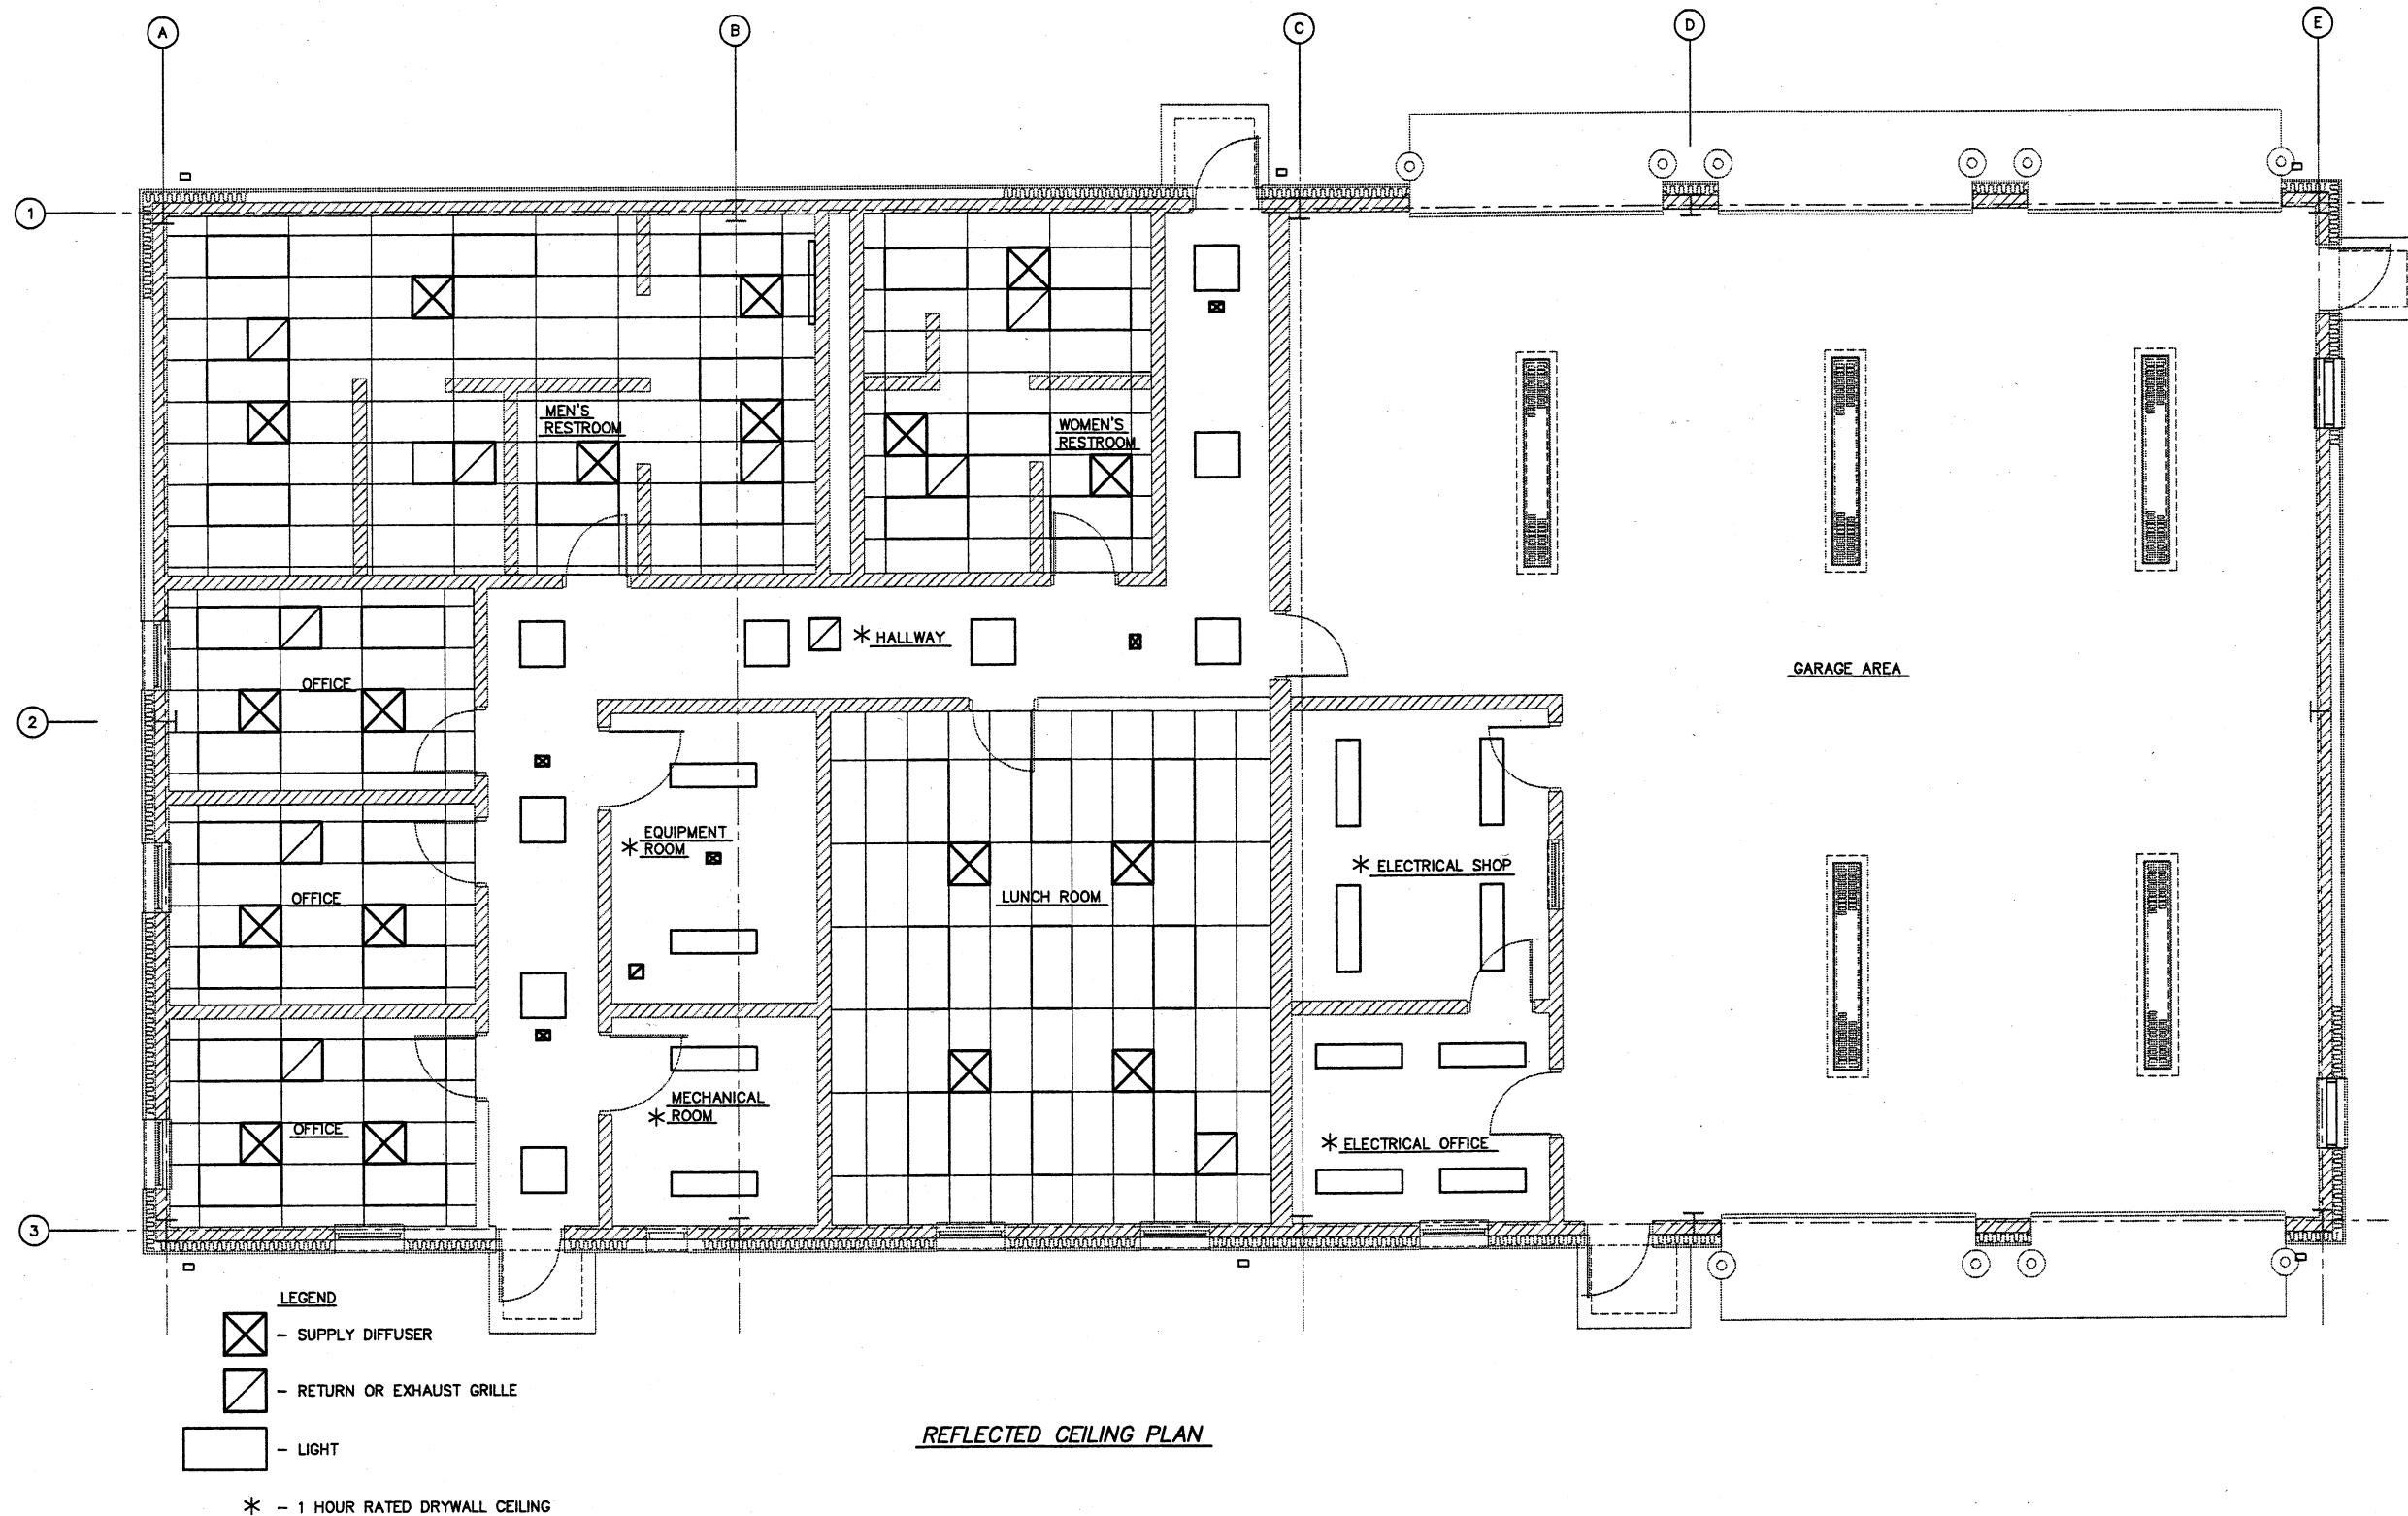

ENVIRONMENTAL, INC.
ENGINEERS IN WATER AND EARTH SCIENCES
UNIONTOWN, OHIO

CITY OF MASSILLON, OHIO
WWTP UPGRADE 2000
MAINTENANCE BUILDING REFLECTED CEILING PLAN

FPS
FINKBEINER, PETTIS & STROUT, INC.
ENGINEERS SINCE 1800
520 SOUTH MAIN STREET
AKRON, OHIO 44324

DESIGNED BY		REVISIONS		DATE	BY	APP'D
		NO.	DESCRIPTIONS			
BDL	DMS					

JOB NO.
E9031

DATE
8/13/01

SCALE
1/4"=1'-0"

SHEET
A7

E9031MBA7.DWG