


MATCH LINE "A" SEE SHEET C22

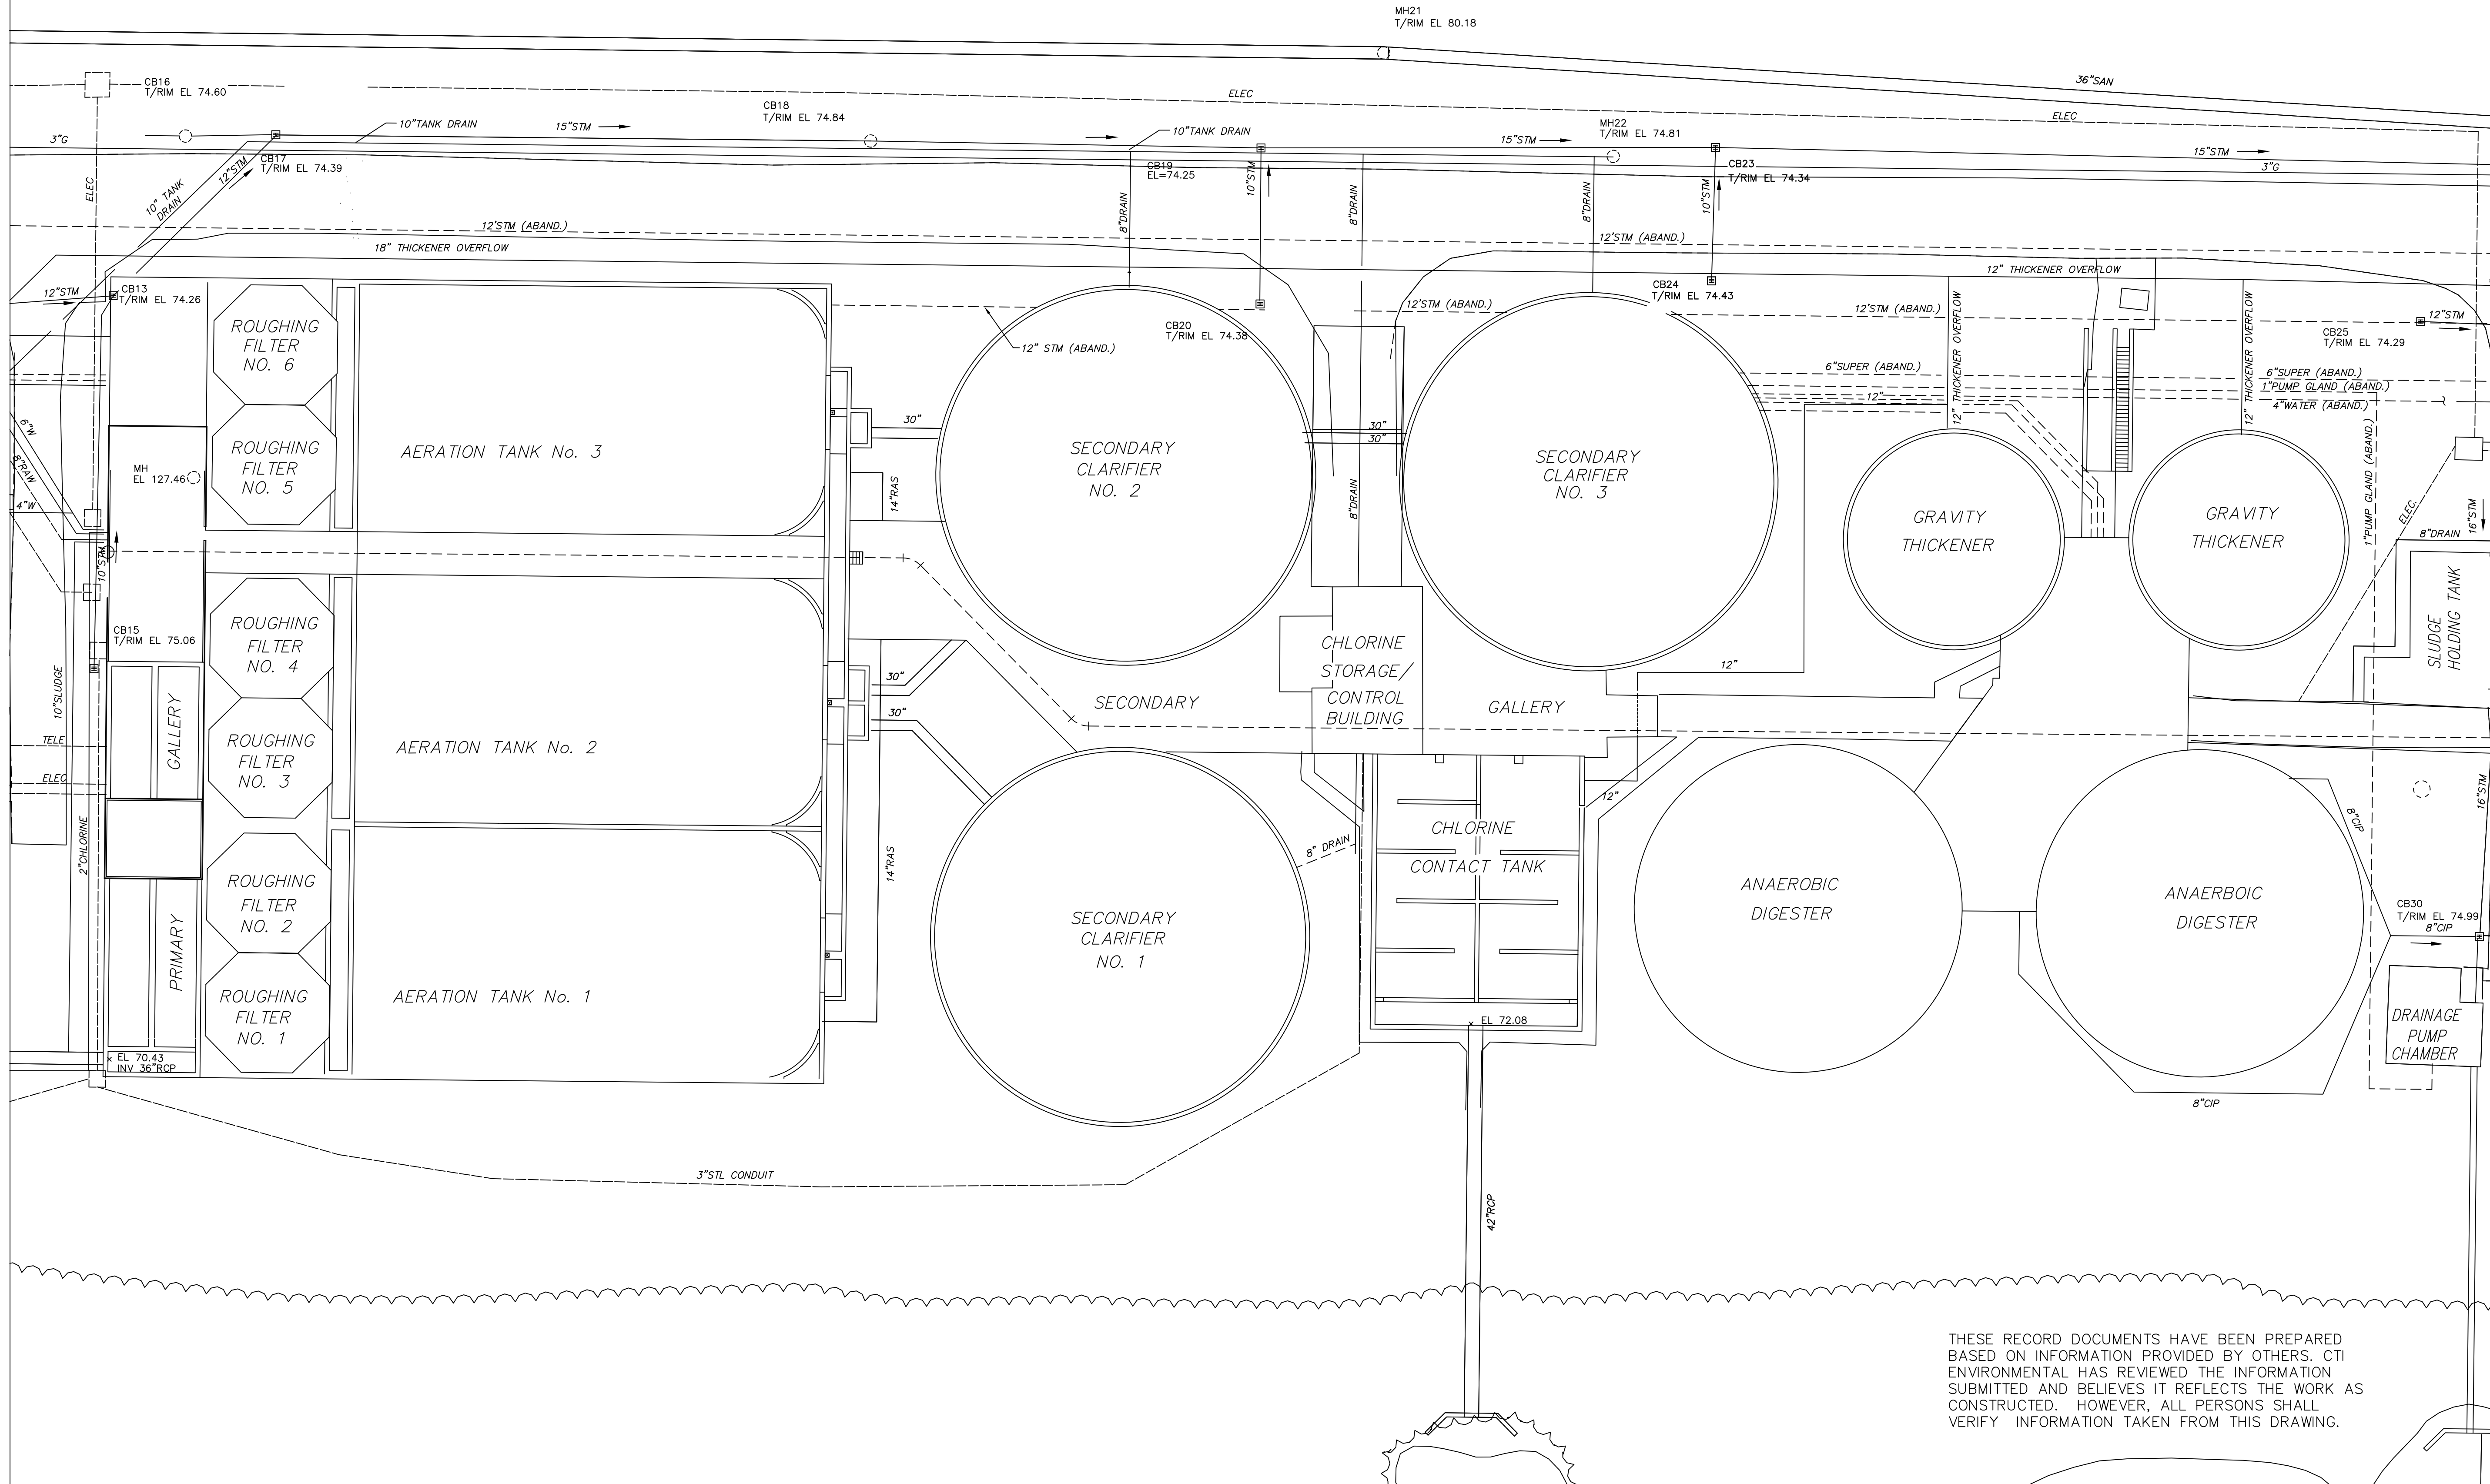

MATCH LINE "B" SEE SHEET C24

THIS DRAWING IS AN INSTRUMENT OF SERVICE OWNED BY CTI ENVIRONMENTAL, INC. WHICH SHALL BE DEEMED THE AUTHOR AND WHICH SHALL RETAIN ALL STATUTORY AND COMMON LAW RIGHTS. THIS DRAWING SHALL NOT BE REPRODUCED, COPIED, OR TRANSMITTED IN ANY FORM OR BY ANY MEANS, WITHOUT THE WRITTEN CONSENT OF CTI ENVIRONMENTAL, INC. THAT ELECTRONIC COPIES OF THIS DRAWING ARE EXACT DUPLICATES OF THE SEALED ORIGINAL. THE SEALED ORIGINAL SHALL GOVERN.

DESIGNED BY		REVISIONS				APP'D	
ELR/AJP		NO.	DESCRIPTIONS	DATE	BY	WAD	
DRAWN BY		1	RECORD DRAWING	12/15	RWR		
ELR/AJP							
CHECKED BY							
WAD							
APPROVED BY							
WAD							

ENVIRONMENTAL, INC.
ENGINEERS IN WATER AND EARTH SCIENCES
UNIONTOWN, OHIO

CITY OF MASSILLON, OHIO
WWTP UPGRADE 2000
EXISTING PIPING PLAN

JOB NO.	E9031
DATE	8/13/01
SCALE	1"=20'
SHEET	C23

THESE RECORD DOCUMENTS HAVE BEEN PREPARED BASED ON INFORMATION PROVIDED BY OTHERS. CTI ENVIRONMENTAL HAS REVIEWED THE INFORMATION SUBMITTED AND BELIEVES IT REFLECTS THE WORK AS CONSTRUCTED. HOWEVER, ALL PERSONS SHALL VERIFY INFORMATION TAKEN FROM THIS DRAWING.