


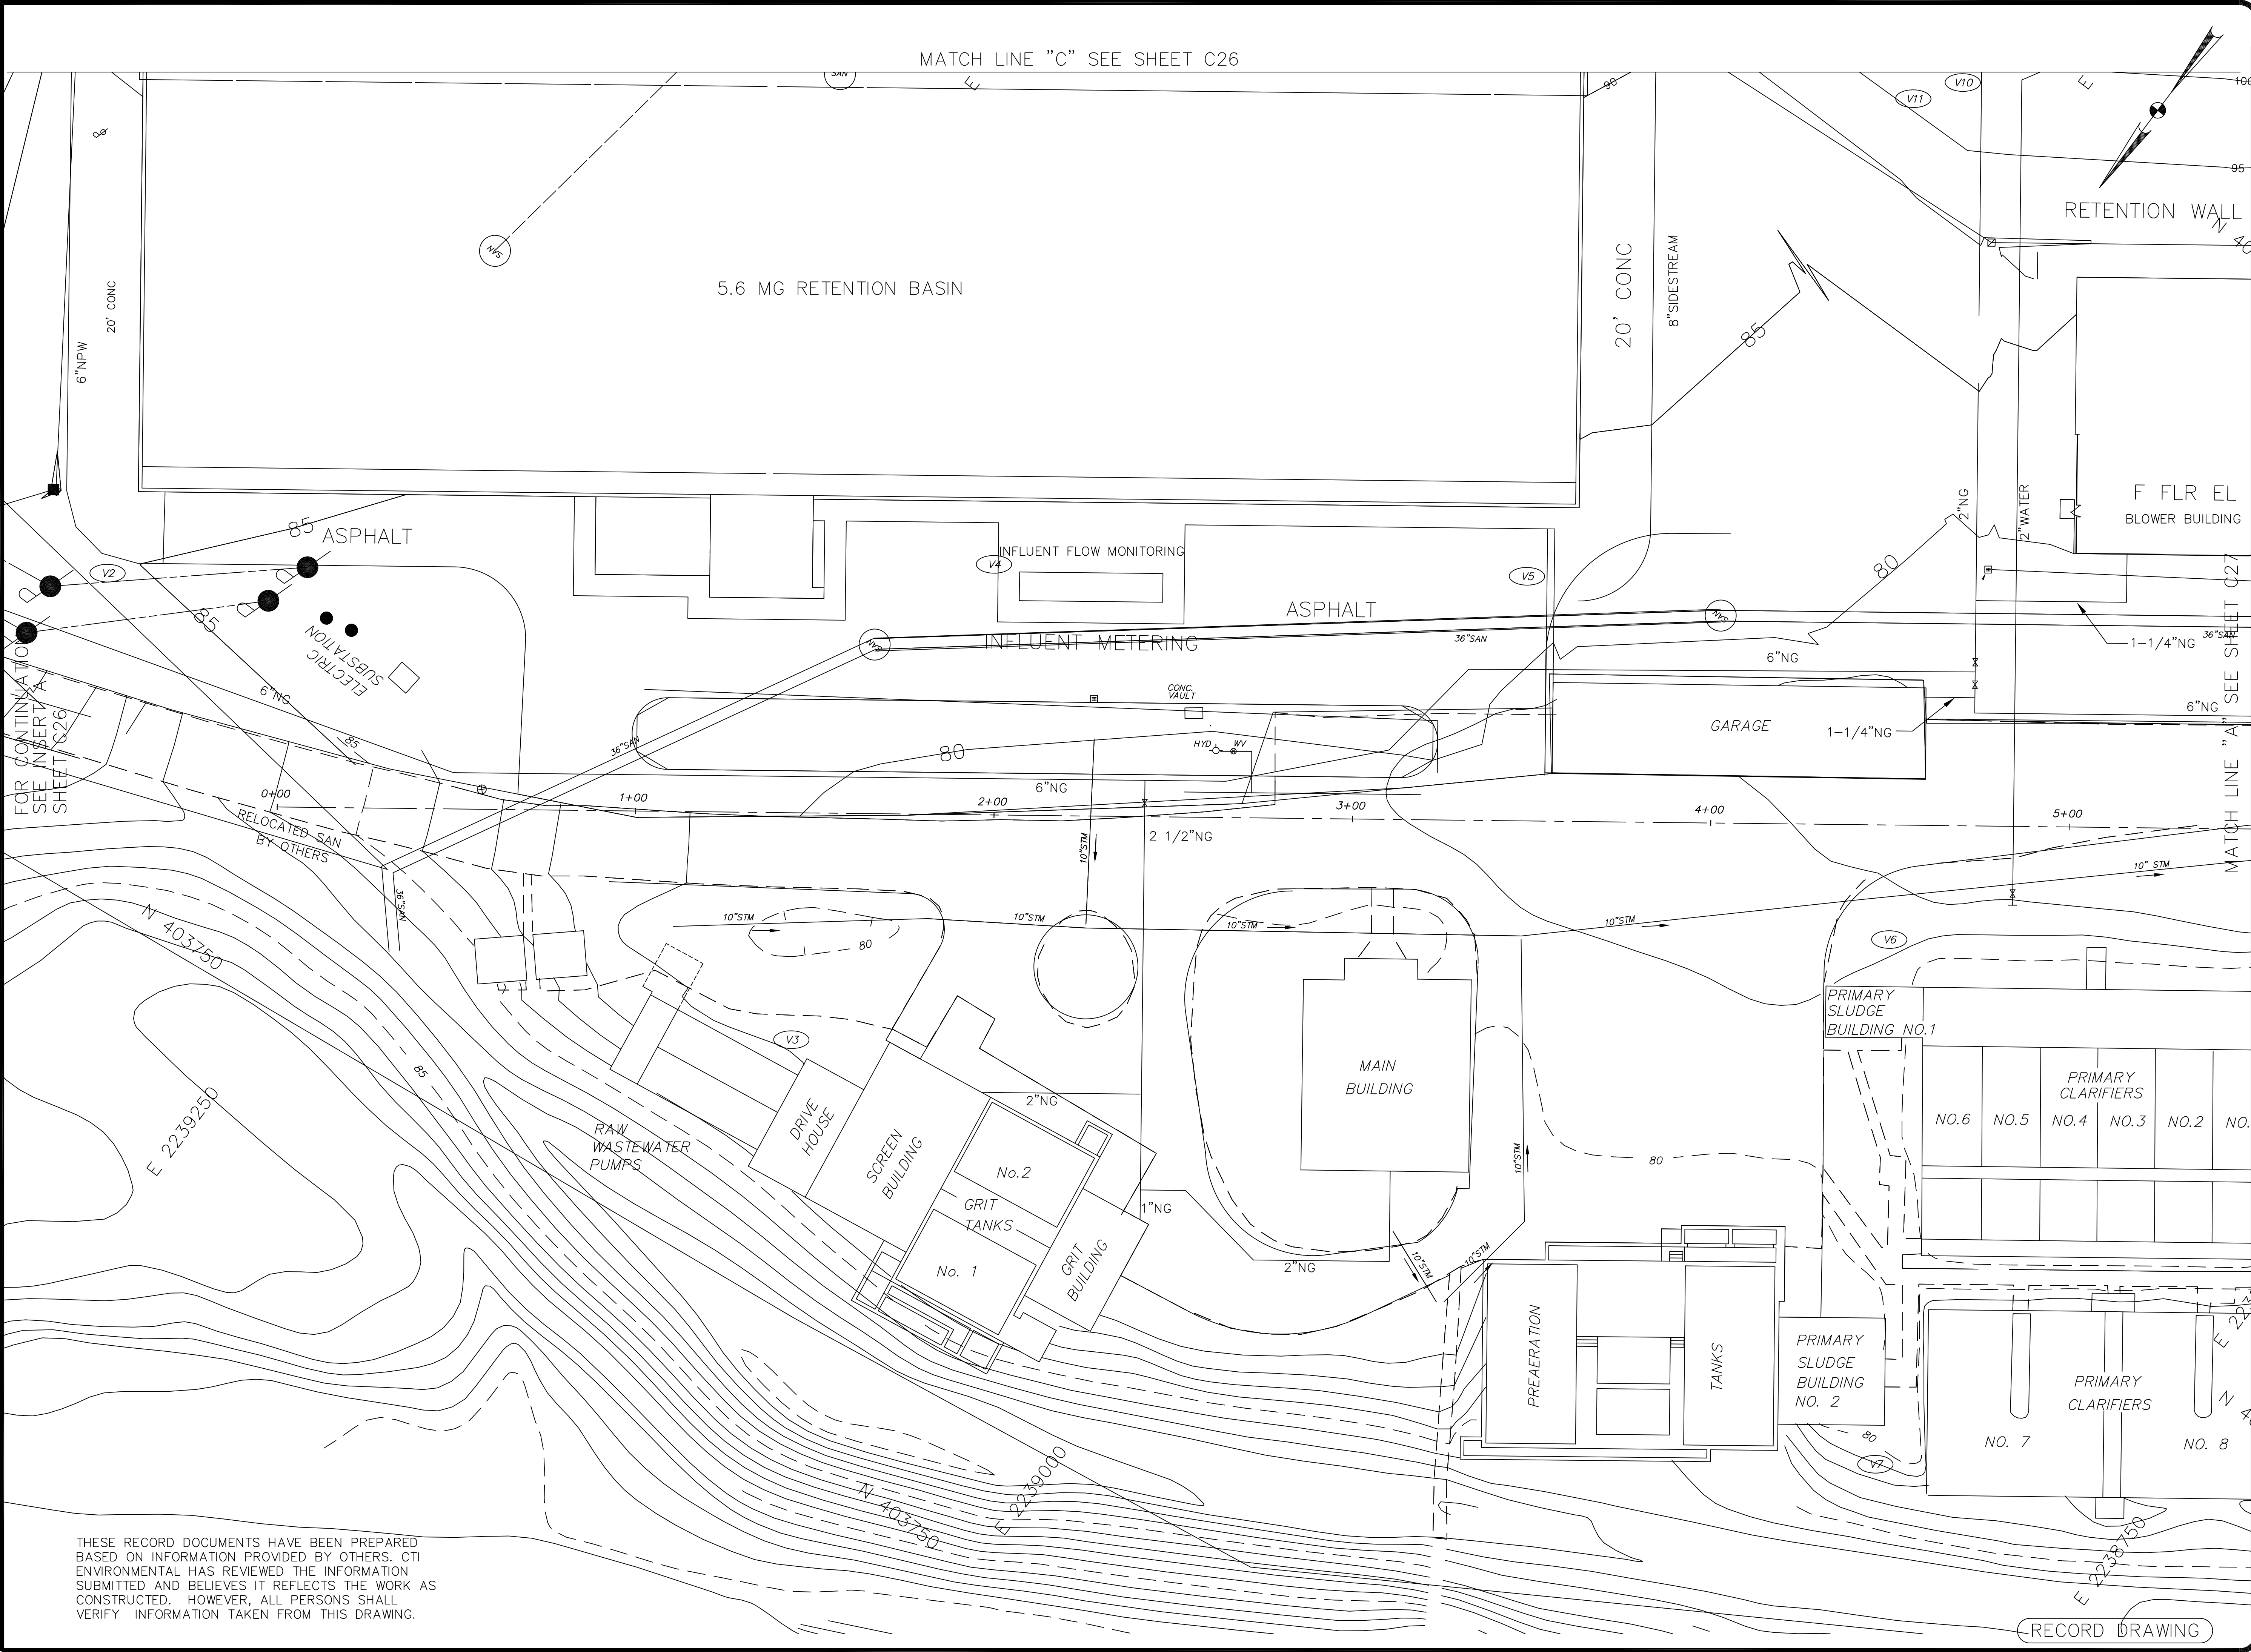


THESE RECORD DOCUMENTS HAVE BEEN PREPARED
BASED ON INFORMATION PROVIDED BY OTHERS. CTI
ENVIRONMENTAL HAS REVIEWED THE INFORMATION
SUBMITTED AND BELIEVES IT REFLECTS THE WORK AS
CONSTRUCTED. HOWEVER, ALL PERSONS SHALL
VERIFY INFORMATION TAKEN FROM THIS DRAWING.

THIS DRAWING IS AN INSTRUMENT OF SERVICE OWNED
BY CTI ENVIRONMENTAL, INC. WHICH SHALL BE DEEMED
THE AUTHOR AND WHICH SHALL RETAIN ALL STATUTORY
RIGHTS. THIS DRAWING SHALL NOT BE REPRODUCED, COPIED, OR
TRANSMITTED IN ANY FORM OR BY ANY MEANS, ELECTRONIC OR
MECHANICAL, INCLUDING PHOTOCOPYING, RECORDING, OR BY
ANY INFORMATION STORAGE AND RETRIEVAL SYSTEM, WITHOUT
THE WRITTEN CONSENT OF CTI ENVIRONMENTAL, INC. THAT
DUPLICATES OF THE SCALED ORIGINAL DRAWING, ELECTRONIC
COPIES OF THE SCALED ORIGINAL DRAWING, OR THE SCALED
ORIGINAL COPY AND THE SCALED ORIGINAL SHALL GOVERN.

NO.	DESCRIPTIONS	DATE	BY	APP'D
1	RECORD DRAWING	12/15	RWR	WAD

DESIGNED BY	DRAWN BY	CHECKED BY	APPROVED BY
MGW/AJP	ELR/AJP	MGW	WAD

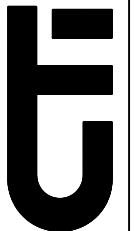

ENVIRONMENTAL, INC.
ENGINEERS IN WATER AND EARTH SCIENCES
UNIONTOWN, OHIO

CITY OF MASSILLON, OHIO
WWTP UPGRADE 2000
PIPING PLAN

JOB NO. E9031
DATE 8/13/01
SCALE 1"=20'
SHEET C25

RECORD DRAWING