


MATCH LINE "A" SEE SHEET C25

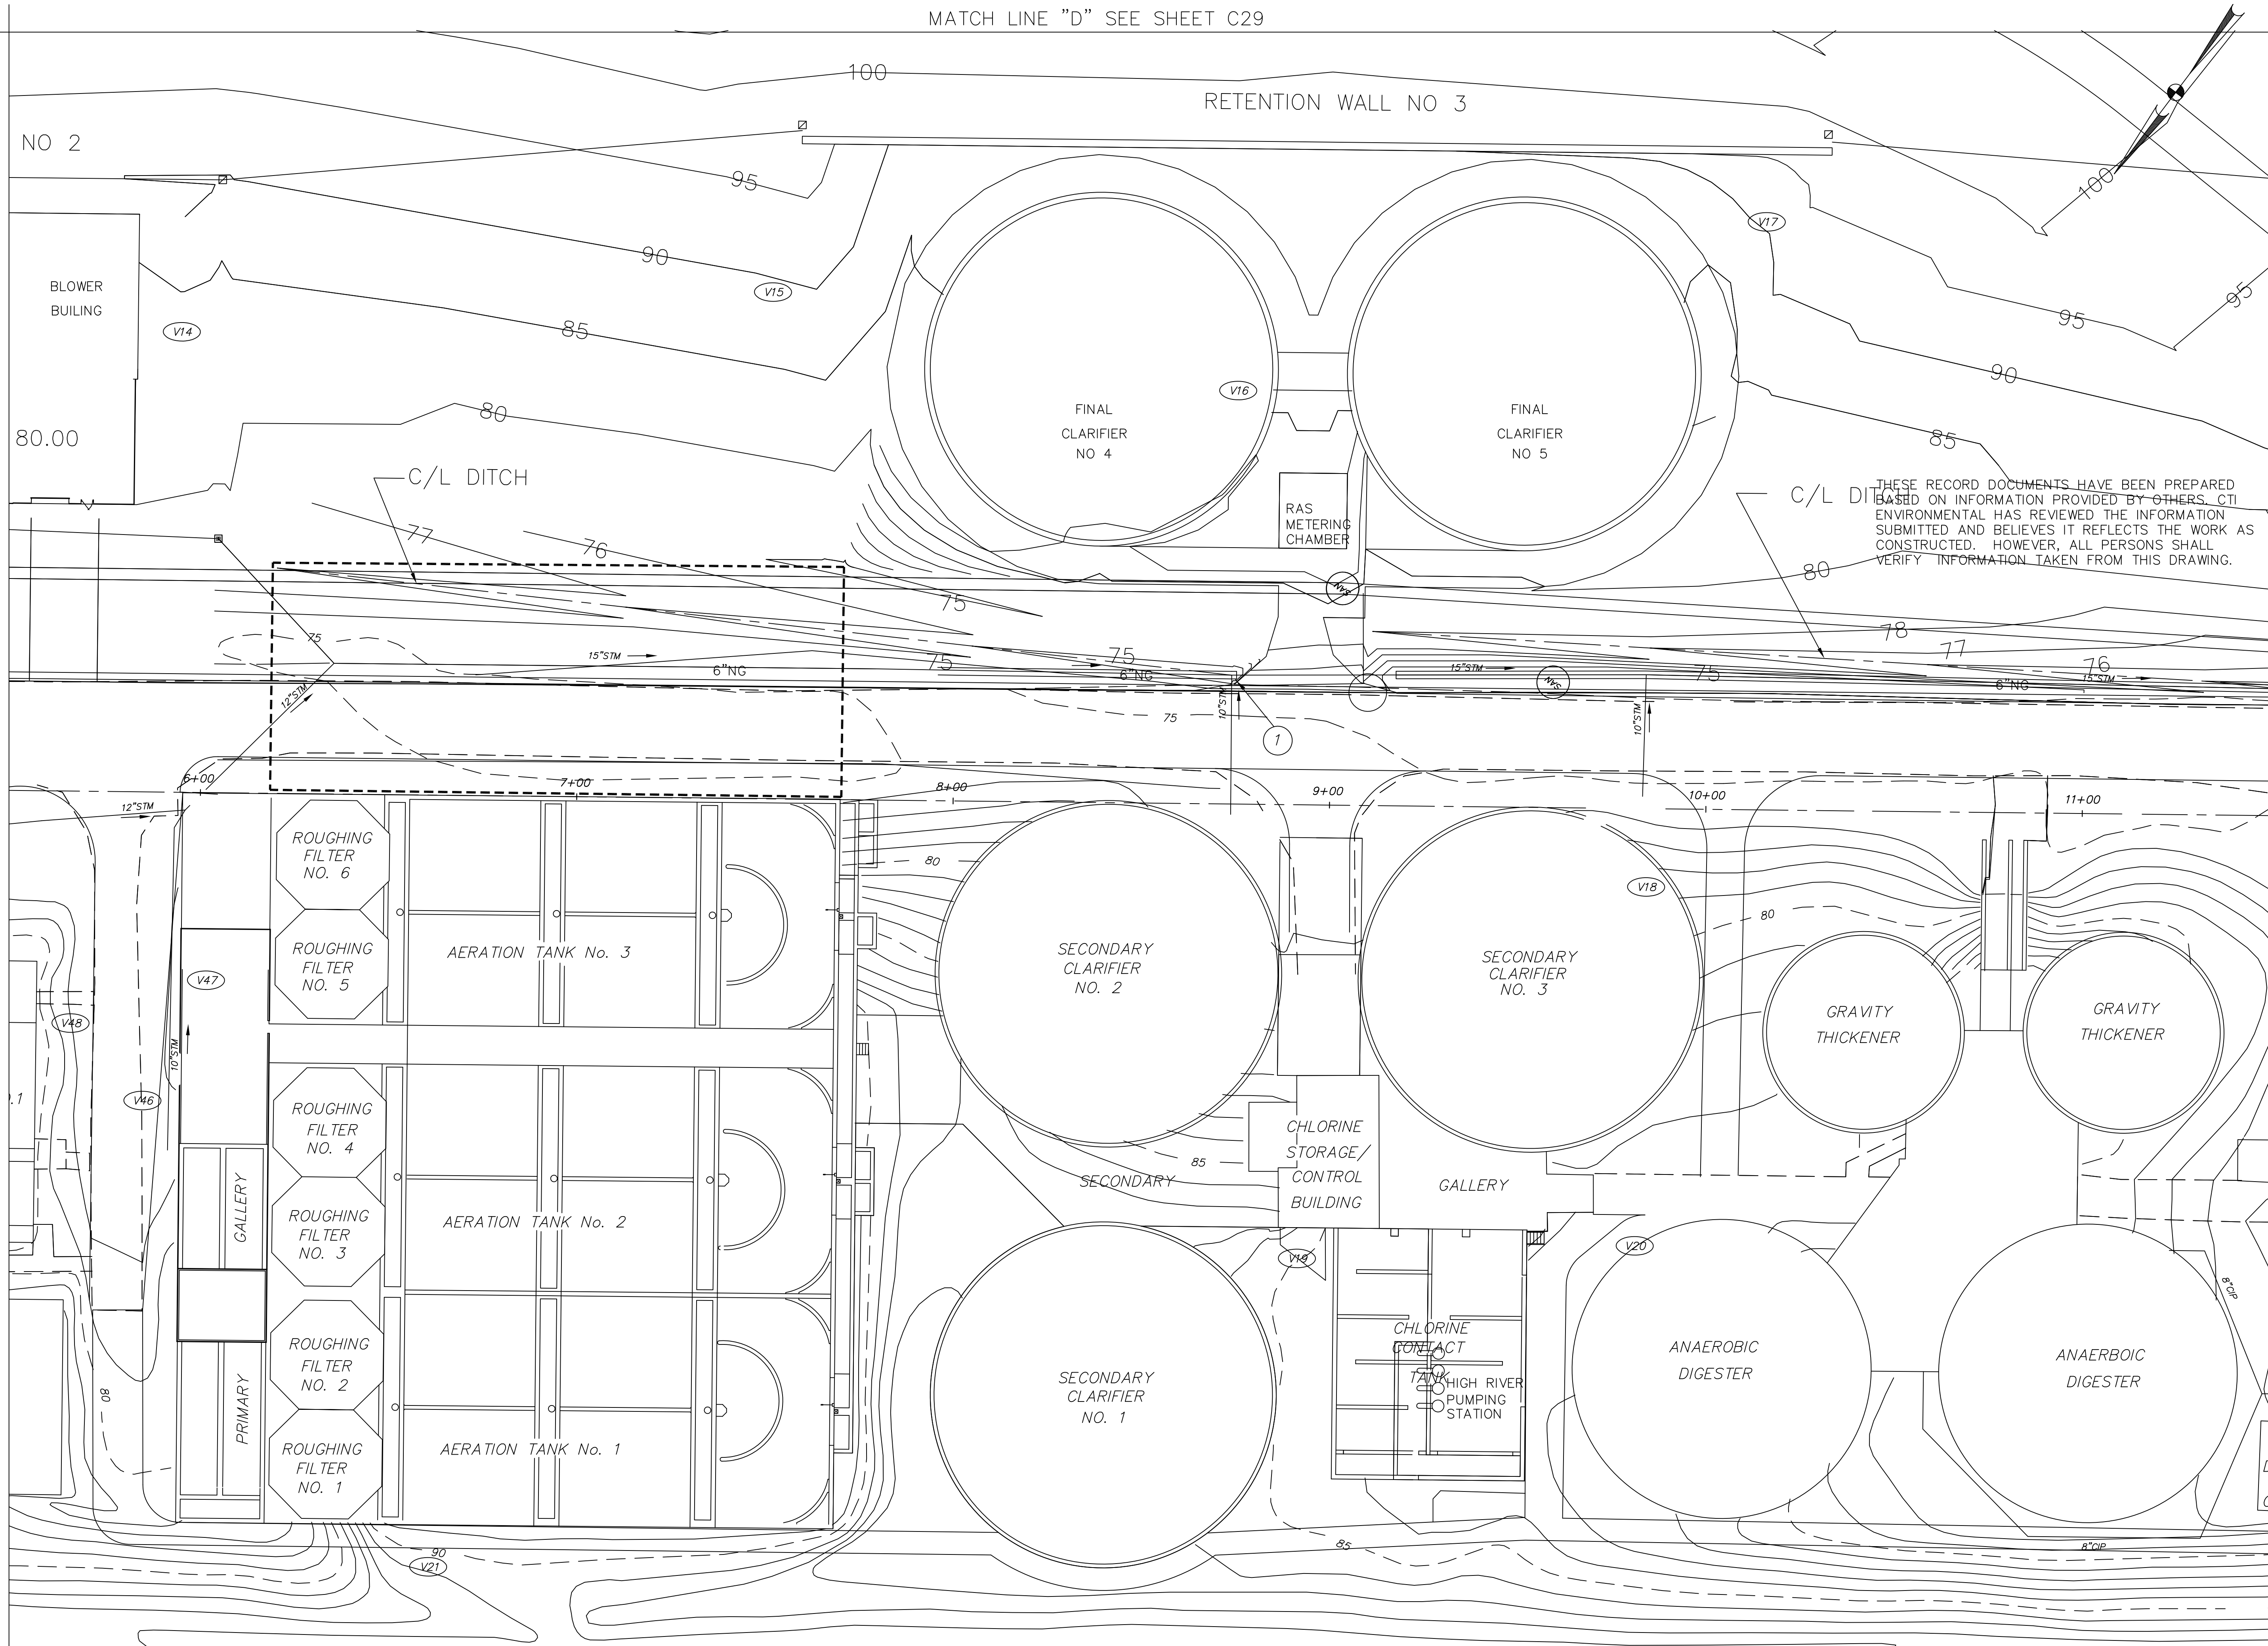

MATCH LINE "B" SEE SHEET C28

THIS DRAWING IS AN INSTRUMENT OF SERVICE OWNED BY CTI ENVIRONMENTAL, INC. WHICH SHALL BE DEEMED BY THE AUTHOR AND WHICH SHALL RETAIN ALL STATUTORY RIGHTS. THIS DRAWING SHALL NOT BE REPRODUCED, COPIED, OR IN ANY MANNER FOR ANY OTHER PURPOSE OR PROJECT WITHOUT THE WRITTEN CONSENT OF CTI ENVIRONMENTAL, INC. THAT ELECTRONIC COPIES OF THIS DRAWING ARE EXACT DUPLICATES OF THE SEALED ORIGINAL. THE SEALED ORIGINAL SHALL GOVERN.

DESIGNED BY
MGW/AJP

DRAWN BY
ELR/AJP

CHECKED BY
MGW

APPROVED BY
WAD

REVISIONS
NO. DESCRIPTIONS

DATE BY APP'D
12/15 RWR WAD

RECORD DRAWING

NO. 1

JOB NO.
E9031
DATE
4/6/04
SCALE
1"=20'
SHEET
C27

ENVIRONMENTAL, INC.
ENGINEERS IN WATER AND EARTH SCIENCES
UNCINTOWN, OHIO

CITY OF MASSILLON, OHIO
WWTP UPGRADE 2000
PIPING PLAN