


MATCH LINE "B" SEE SHEET C27

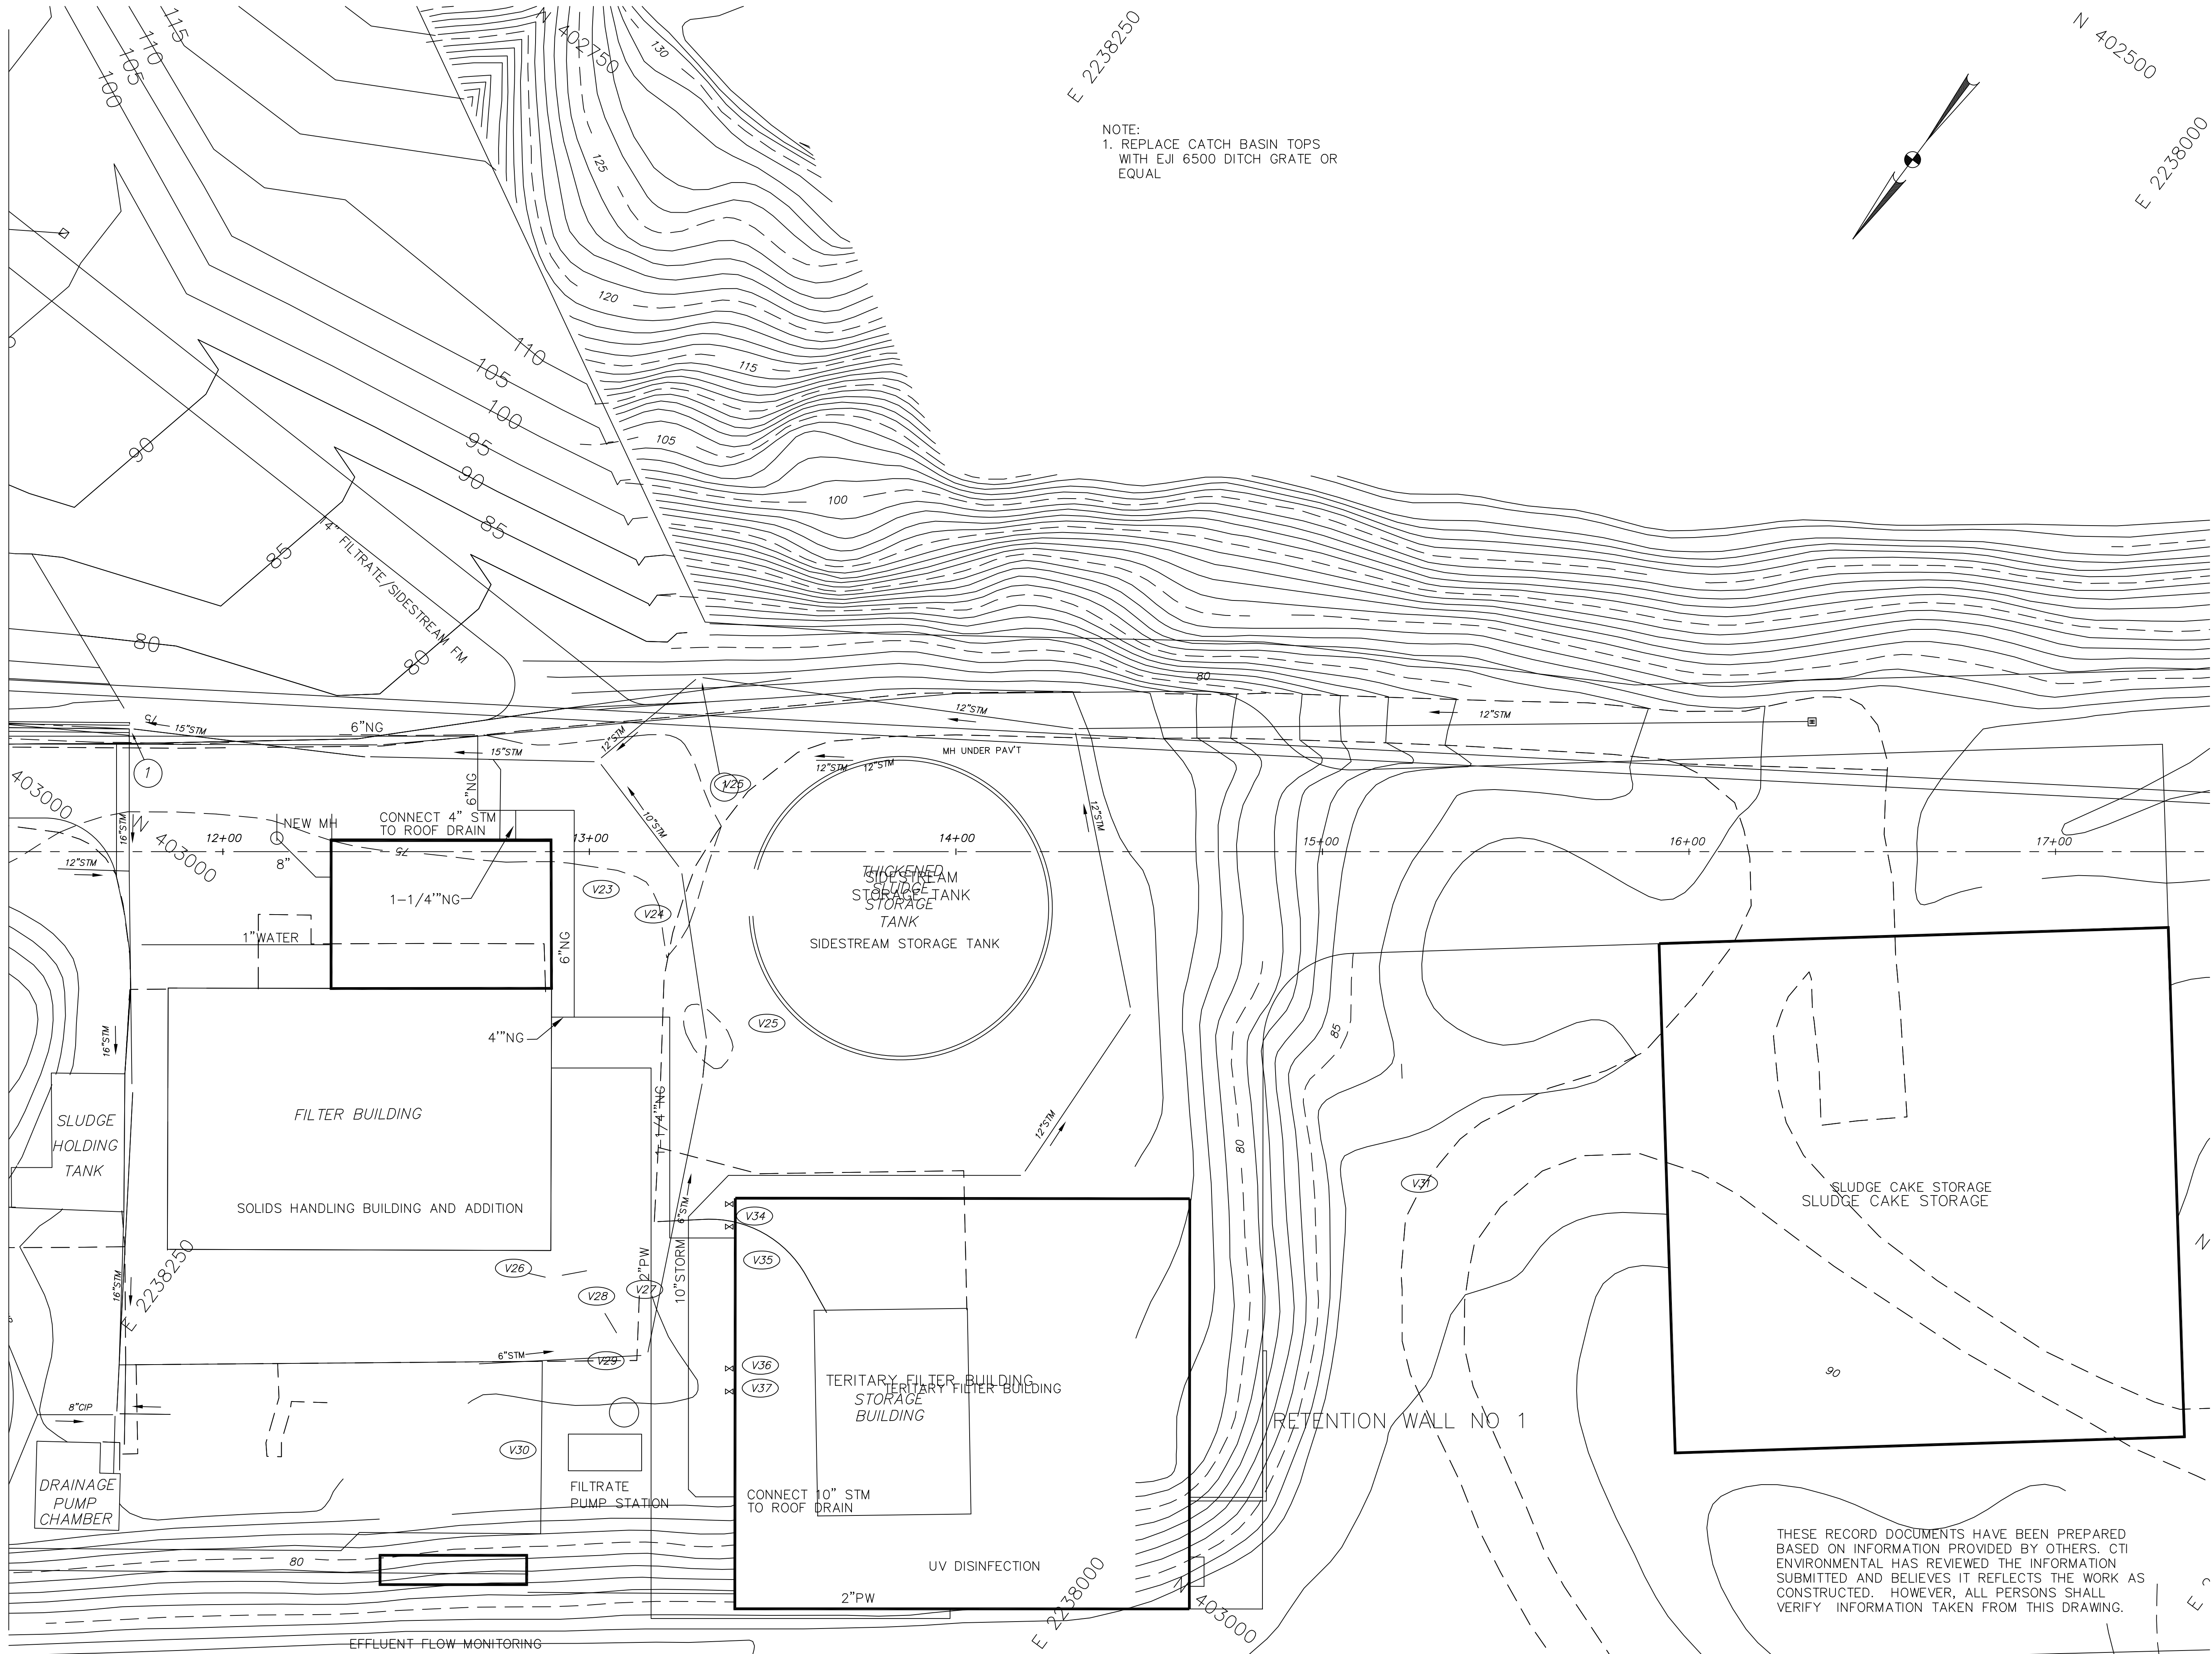

E 2238250

N 402500

E 2238000

E 2238000

403000

E 2

THIS DRAWING IS AN INSTRUMENT OF SERVICE OWNED BY CTI ENVIRONMENTAL, INC. WHICH SHALL BE DEEMED THE AUTHOR AND WHICH SHALL RETAIN ALL STATUTORY AND COMMON LAW RIGHTS. NO PART OF THIS DRAWING SHALL BE REPRODUCED, COPIED, OR TRANSMITTED IN ANY FORM OR BY ANY MEANS, WITHOUT THE WRITTEN CONSENT OF CTI ENVIRONMENTAL, INC. THAT ELECTRONIC COPIES OF THIS DRAWING ARE EXACT DUPLICATES OF THE SEALED ORIGINAL DRAWING. ANY OTHER COPIES OF THIS DRAWING SHALL BE CONSIDERED VOID AND THE SEALED ORIGINAL SHALL GOVERN.

REVISIONS				
NO.	DESCRIPTIONS	DATE	BY	APP'D
1	RECORD DRAWING	12/15	RWR	WAD

DESIGNED BY
MGW/AJP

DRAWN BY
ELR/AJP


CHECKED BY
MGW

APPROVED BY
WAD

ENVIRONMENTAL, INC.
ENGINEERS IN WATER AND EARTH SCIENCES
UNIONTOWN, OHIO


CITY OF MASSILLON, OHIO
WWTP UPGRADE 2000
PIPING PLAN

JOB NO. E9031
DATE 8/13/01
SCALE 1"=20'
SHEET C28

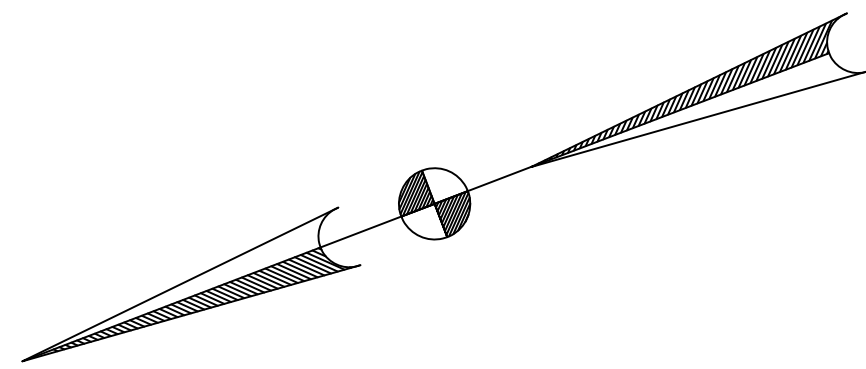

KEY

- ① C/L 14"=71.08
- ② C/L 14"=64.82
- ③ C/L 42"=69.50
- ④ C/L 42"=68.00
- ⑤ C/L 18"-90° BEND=68.00

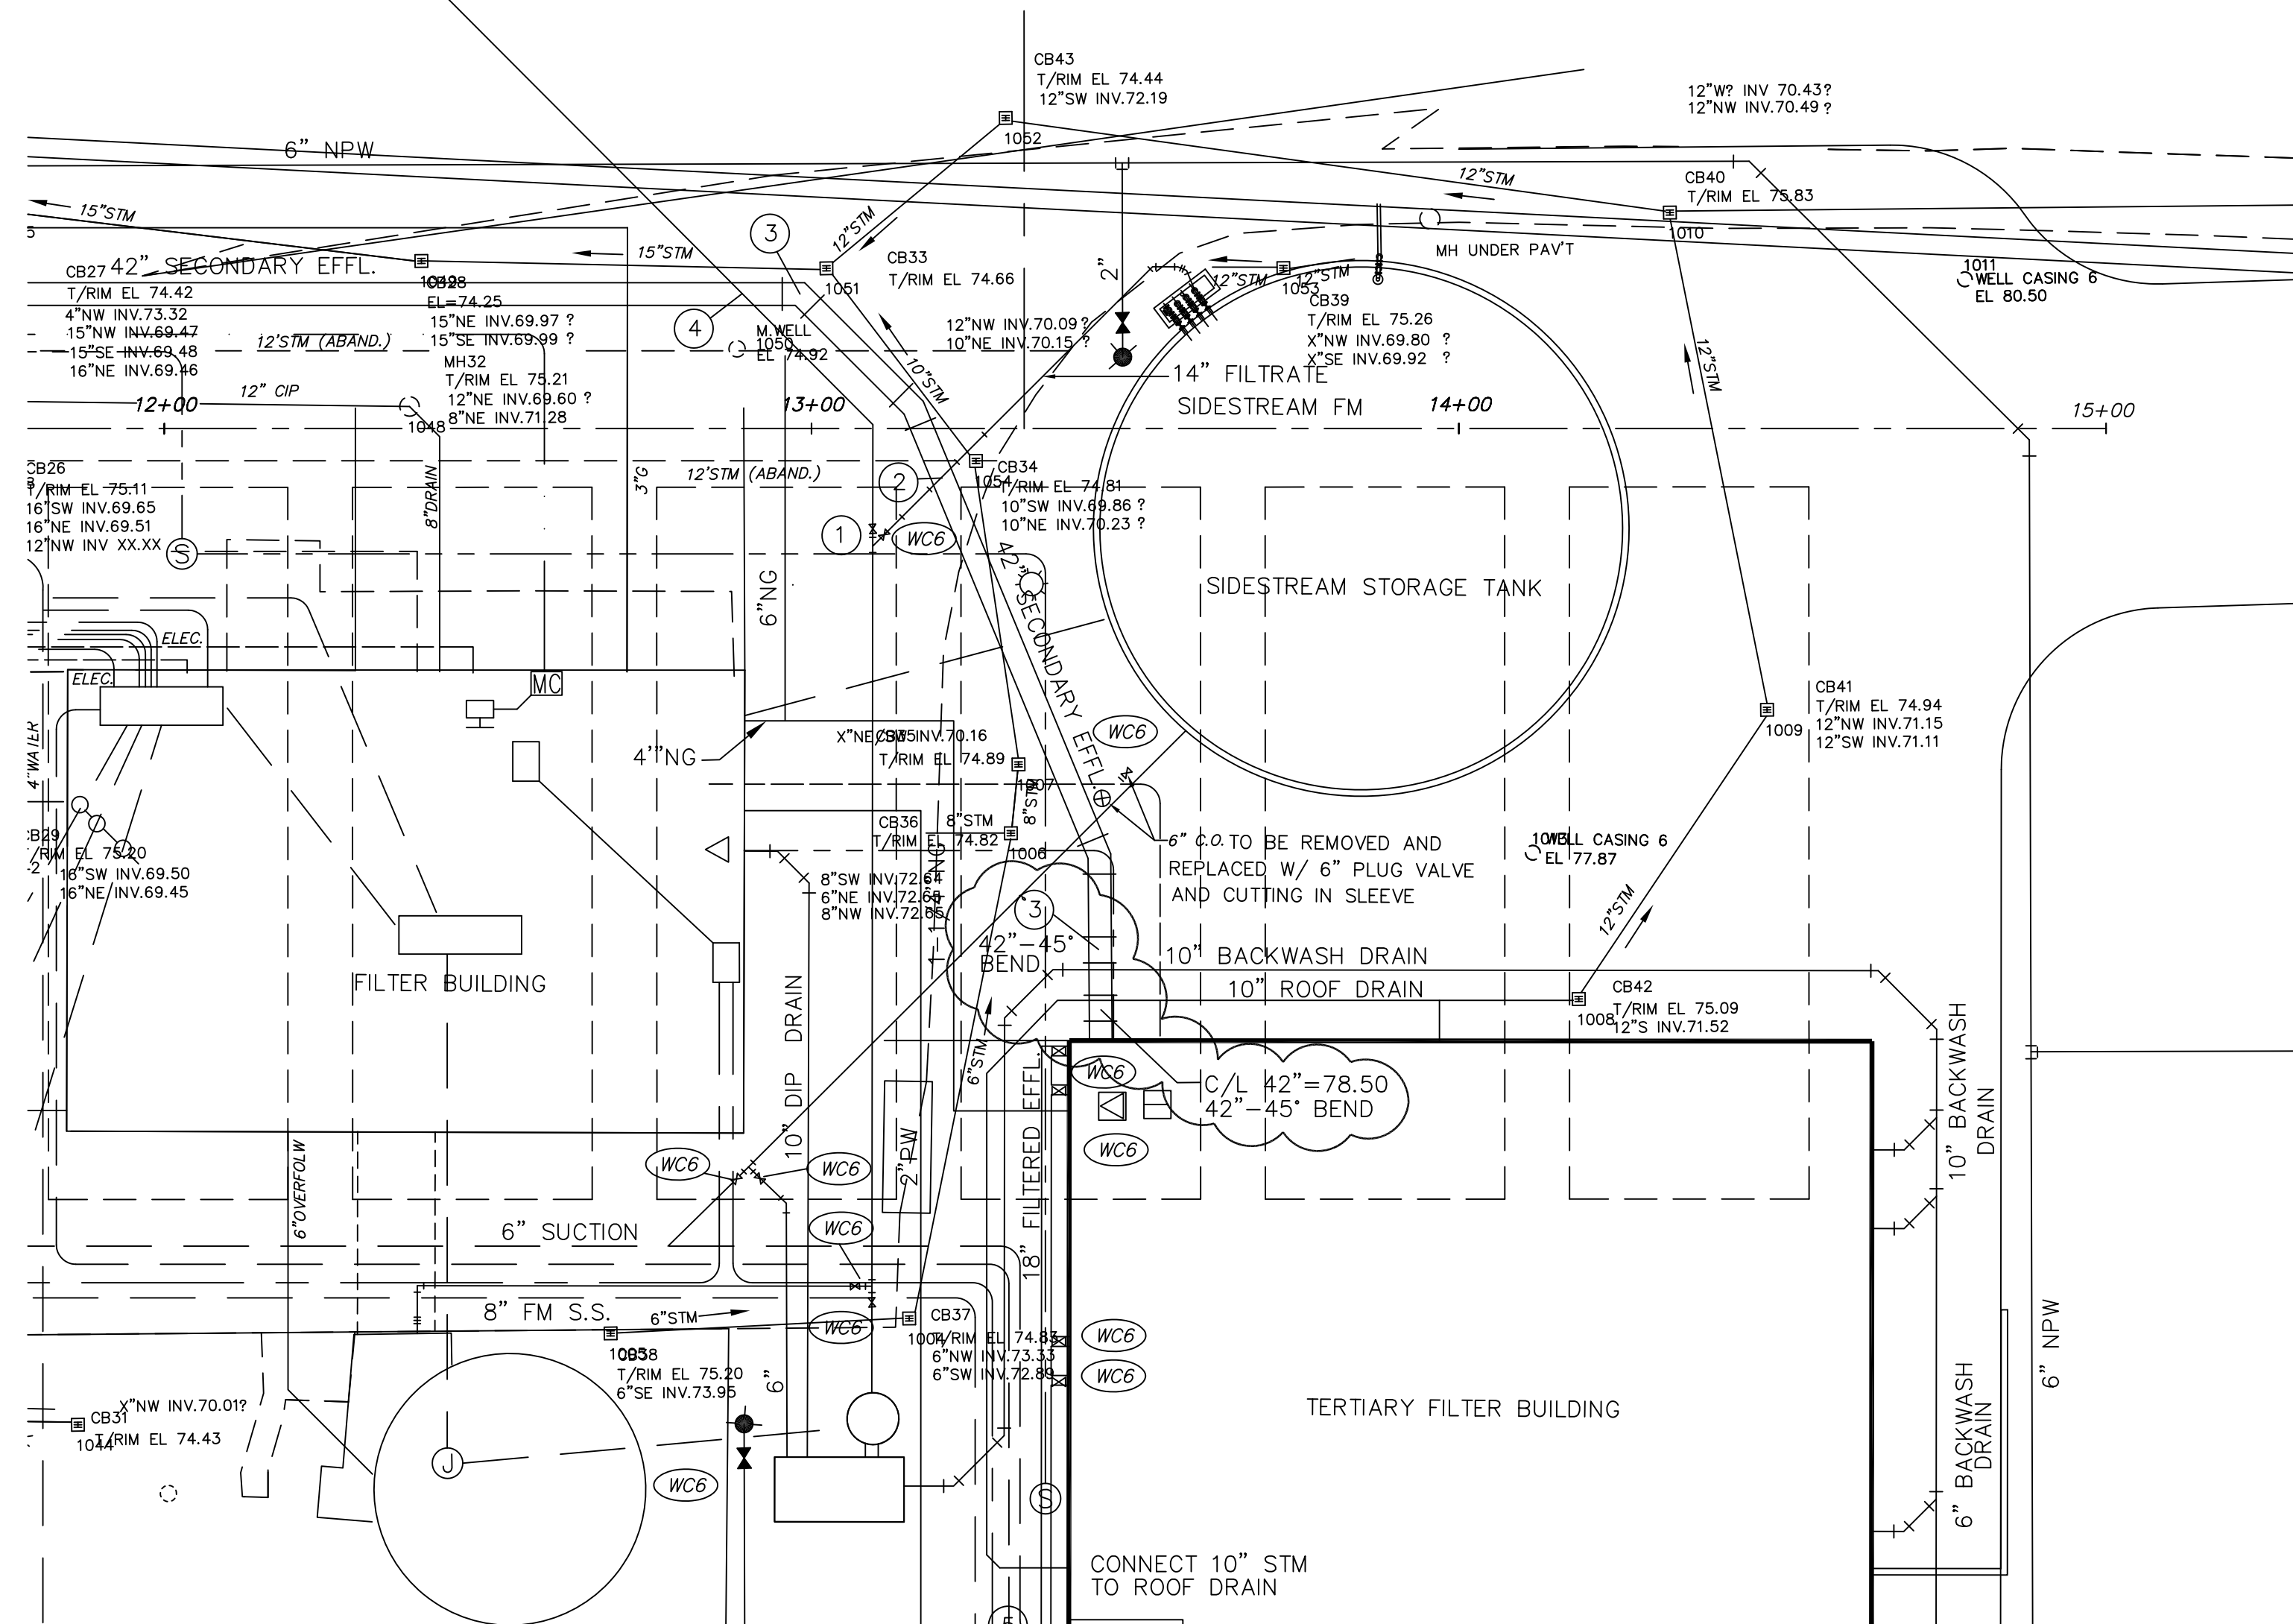

ADDENDUM NO. 3

CITY OF MASSILLON, OHIO
WWTP UPGRADE 2000
TERTIARY FILTERS



SK-C28-001