


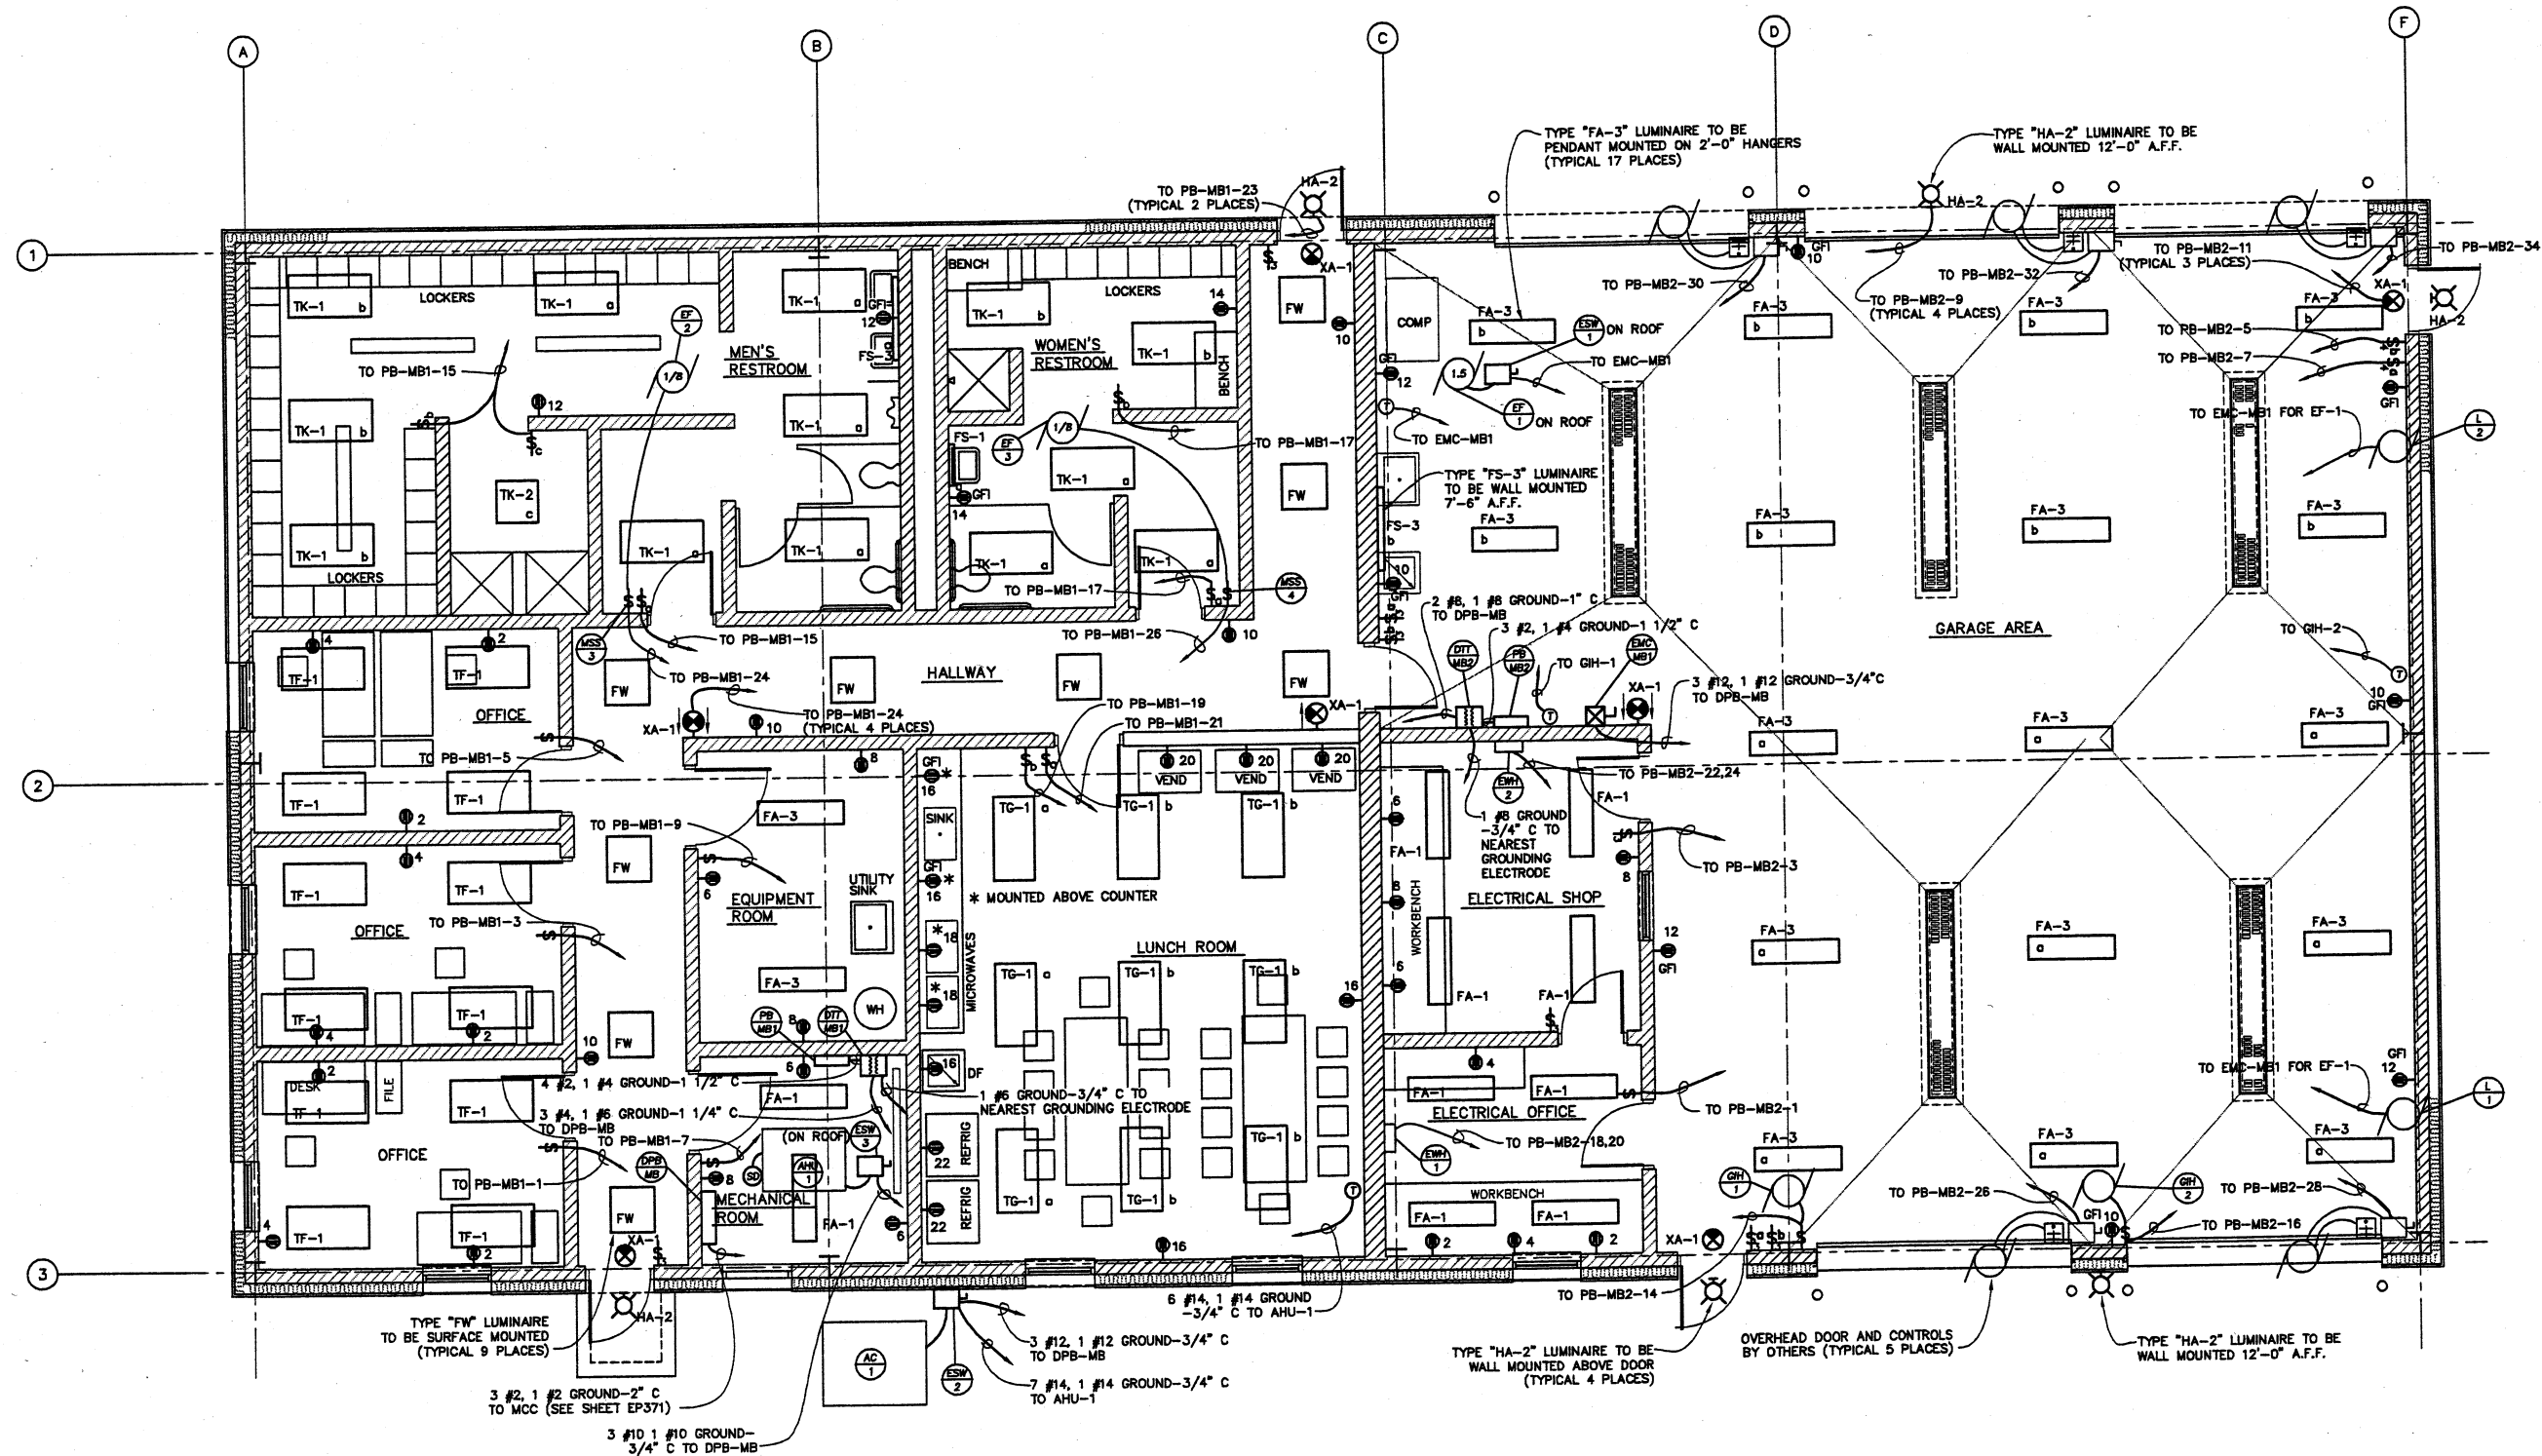

FPS
 FINKBEINER, PETTIS & STROUT, INC.
 ENGINEERS SINCE 1900
 520 SOUTH MAIN STREET
 AKRON, OHIO 44324

DESIGNED BY	DATE	BY	APPROVED
AEP			
DRAWN BY	DATE	BY	APPROVED
AEP			
CHECKED BY	DATE	BY	APPROVED
DMO			
APPROVED BY	DATE	BY	APPROVED
DMO			

CTI
 ENVIRONMENTAL, INC.
 ENGINEERS IN WATER AND EARTH SCIENCES
 UNIONTOWN, OHIO

CITY OF MASSILLON, OHIO
WTP UPGRADE 2000
MAINTENANCE BUILDING - LIGHTING/ POWER PLAN

JOB NO.	E9031
DATE	8/13/01
SCALE	1/4"=1'-0"
SHEET	EB2