
 


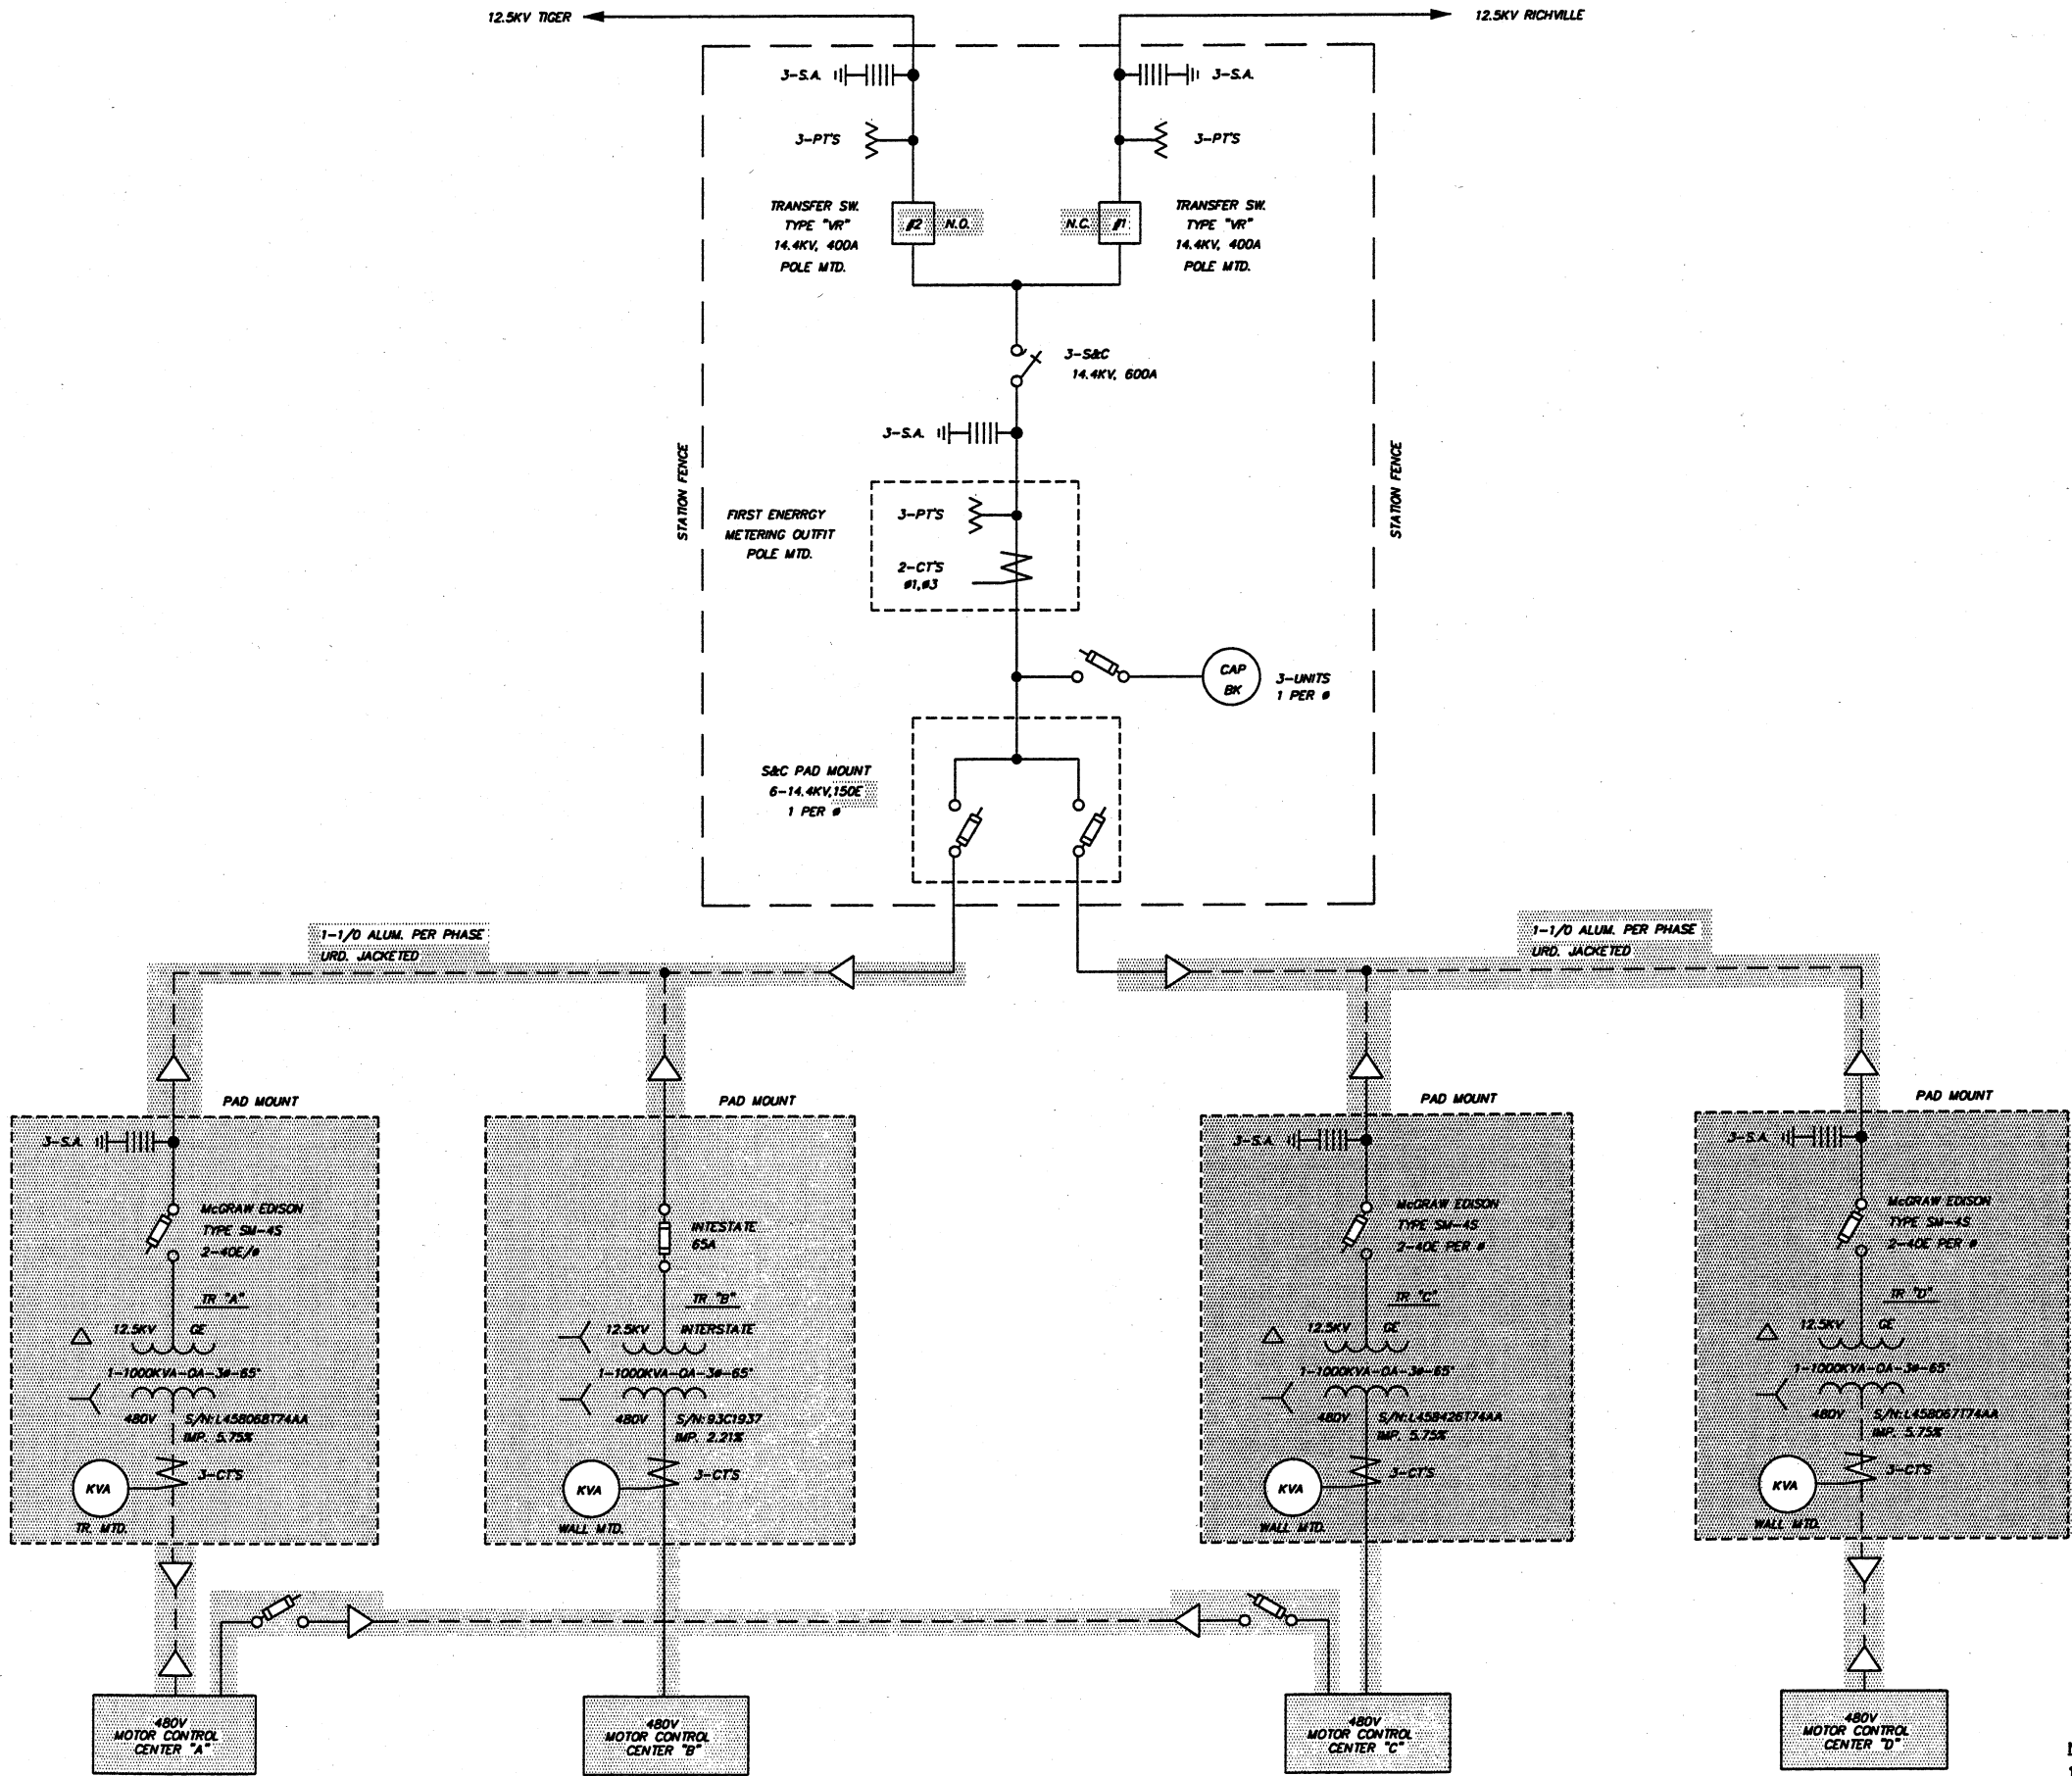

NOTE
1. ITEMS FOR DEMOLITION



DESIGNED BY	STI/TSS	NO.	REVISIONS	DATE	BY	APPROD
DRAWN BY	STI/TSS		DESCRIPTIONS			
CHECKED BY	STI/TSS					
APPROVED BY	STI/R/J					

ENVIRONMENTAL, INC.
ENGINEERS IN WATER AND EARTH SCIENCES
UNIONTOWN, OHIO

CITY OF MASSILLON, OHIO
WWTP UPGRADE 2000
ONE LINE DIAGRAM DEMOLITION PLAN

JOB NO.	E9031
DATE	2/14/01
SCALE	N/A
SHEET	EP2-D