

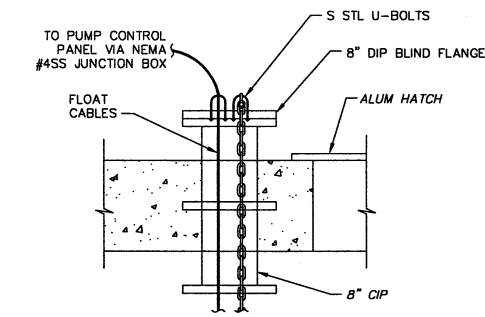


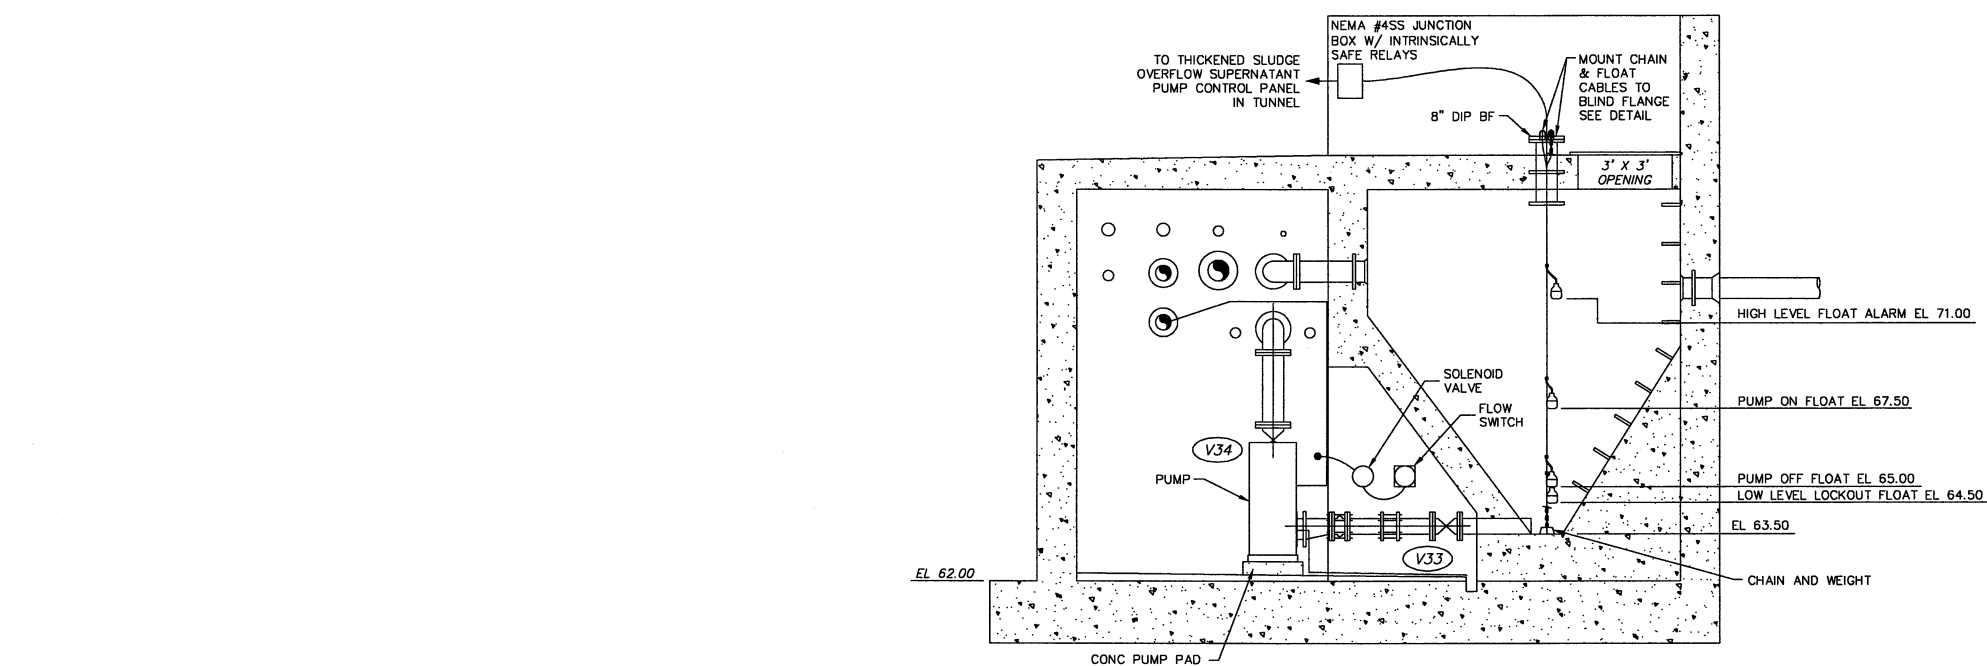

SECTION
SCALE : 3/8"=1'-0" (B)

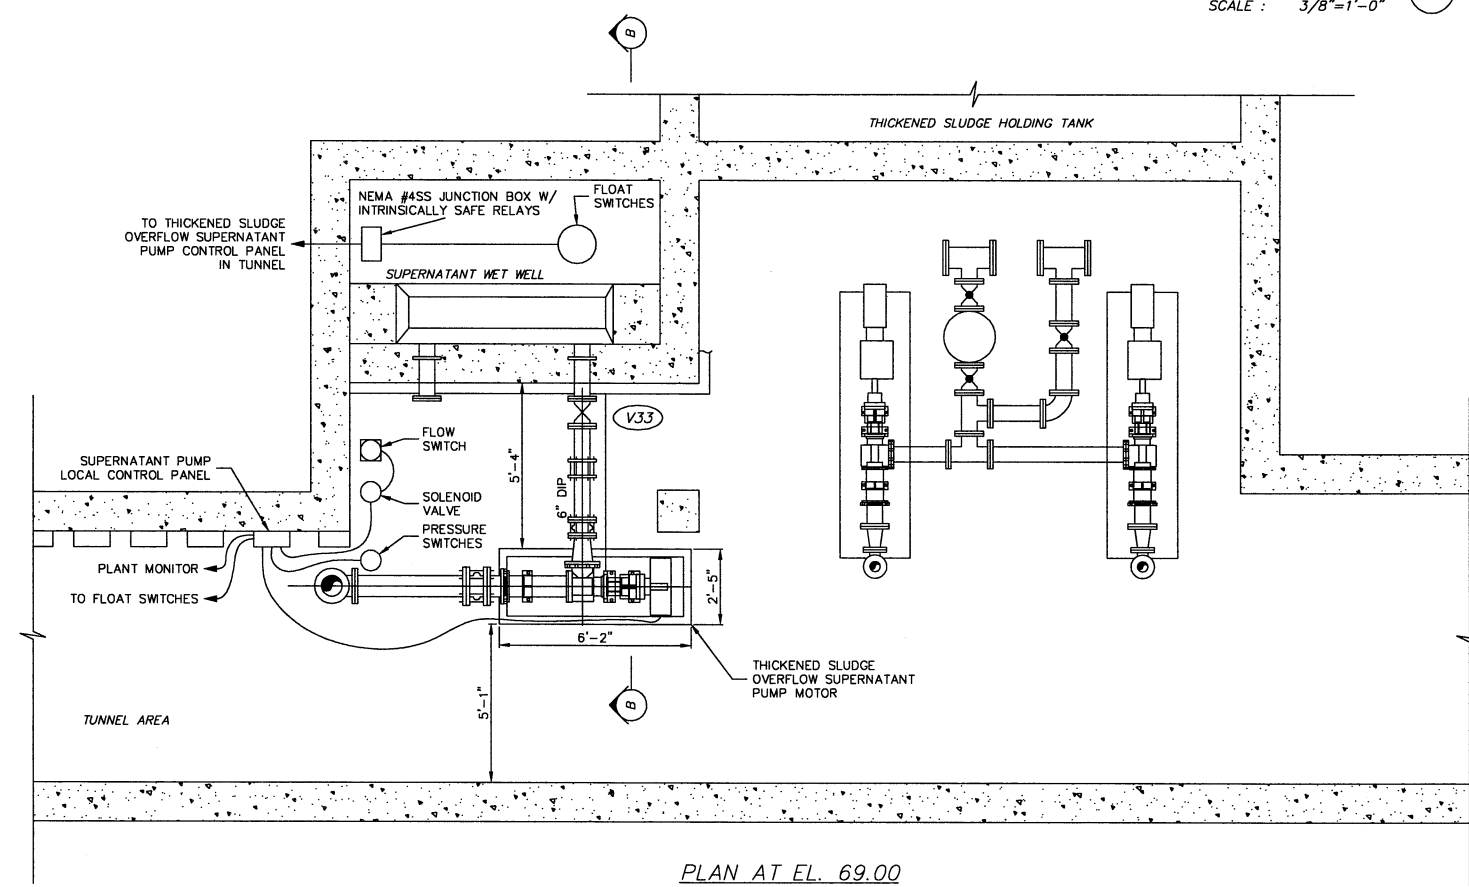

PLAN AT FL. 69.00
SCALE: 3/8"=1'-0"

NOTES:
1. CONDUIT & WIRE SCHEDULE, SEE EP270
2. ELEVATION DETAILS, SEE EP270 & EP271

SEIBERT TECHNOLOGIES, INC.
MASSILLON, OHIO
JOB NO. 7780 RJS/RJL

DESIGNED BY	NO.	REVISIONS	DATE	BY
RJL		DESCRIPTIONS		APPD
DRAWN BY				
GCD				
CHECKED BY				
RJL				
APPROVED BY				
RJL				

ENVIRONMENTAL, INC.
ENGINEERS IN WATER AND EARTH SCIENCES
UNIONTOWN, OHIO

CITY OF MASSILLON, OHIO
TRANSFORMER "DI" WWTP UPGRADE 2000
SUPERNATANT PUMP ELECTRICAL PLAN

JOB NO.	E02008
DATE	5/16/03
SCALE	AS NOTED
SHEET	EP274