




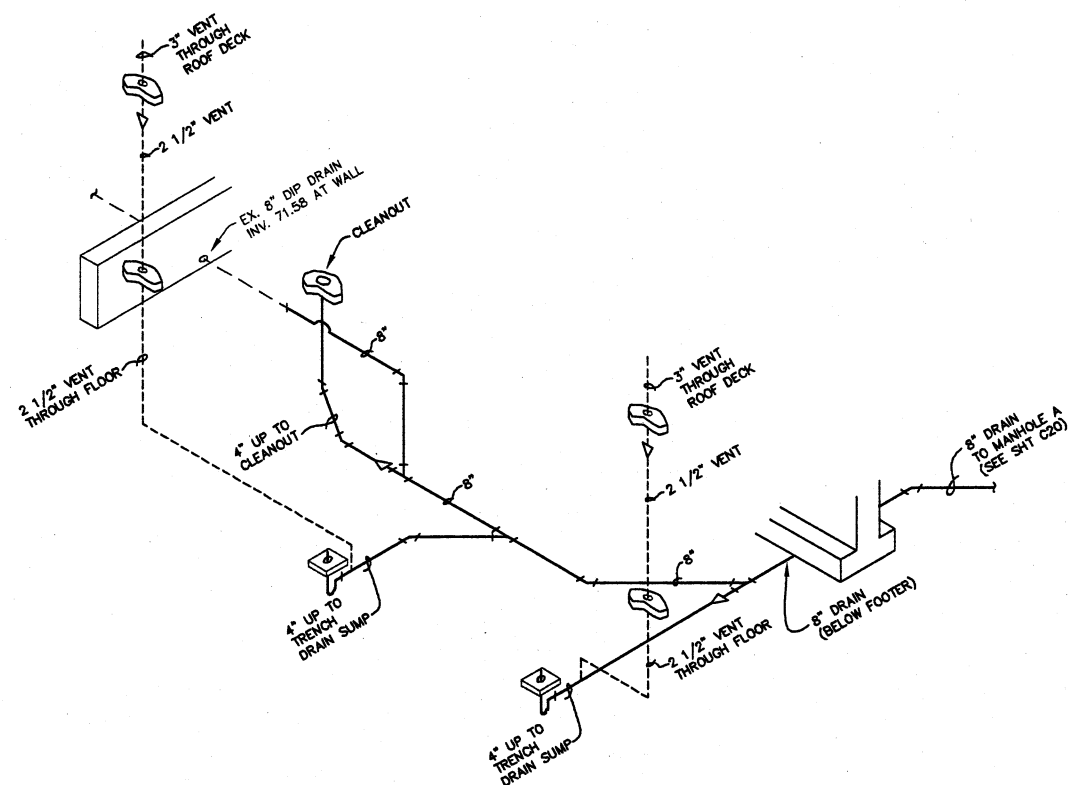

SANITARY SCHEMATIC
SCALE: NONE

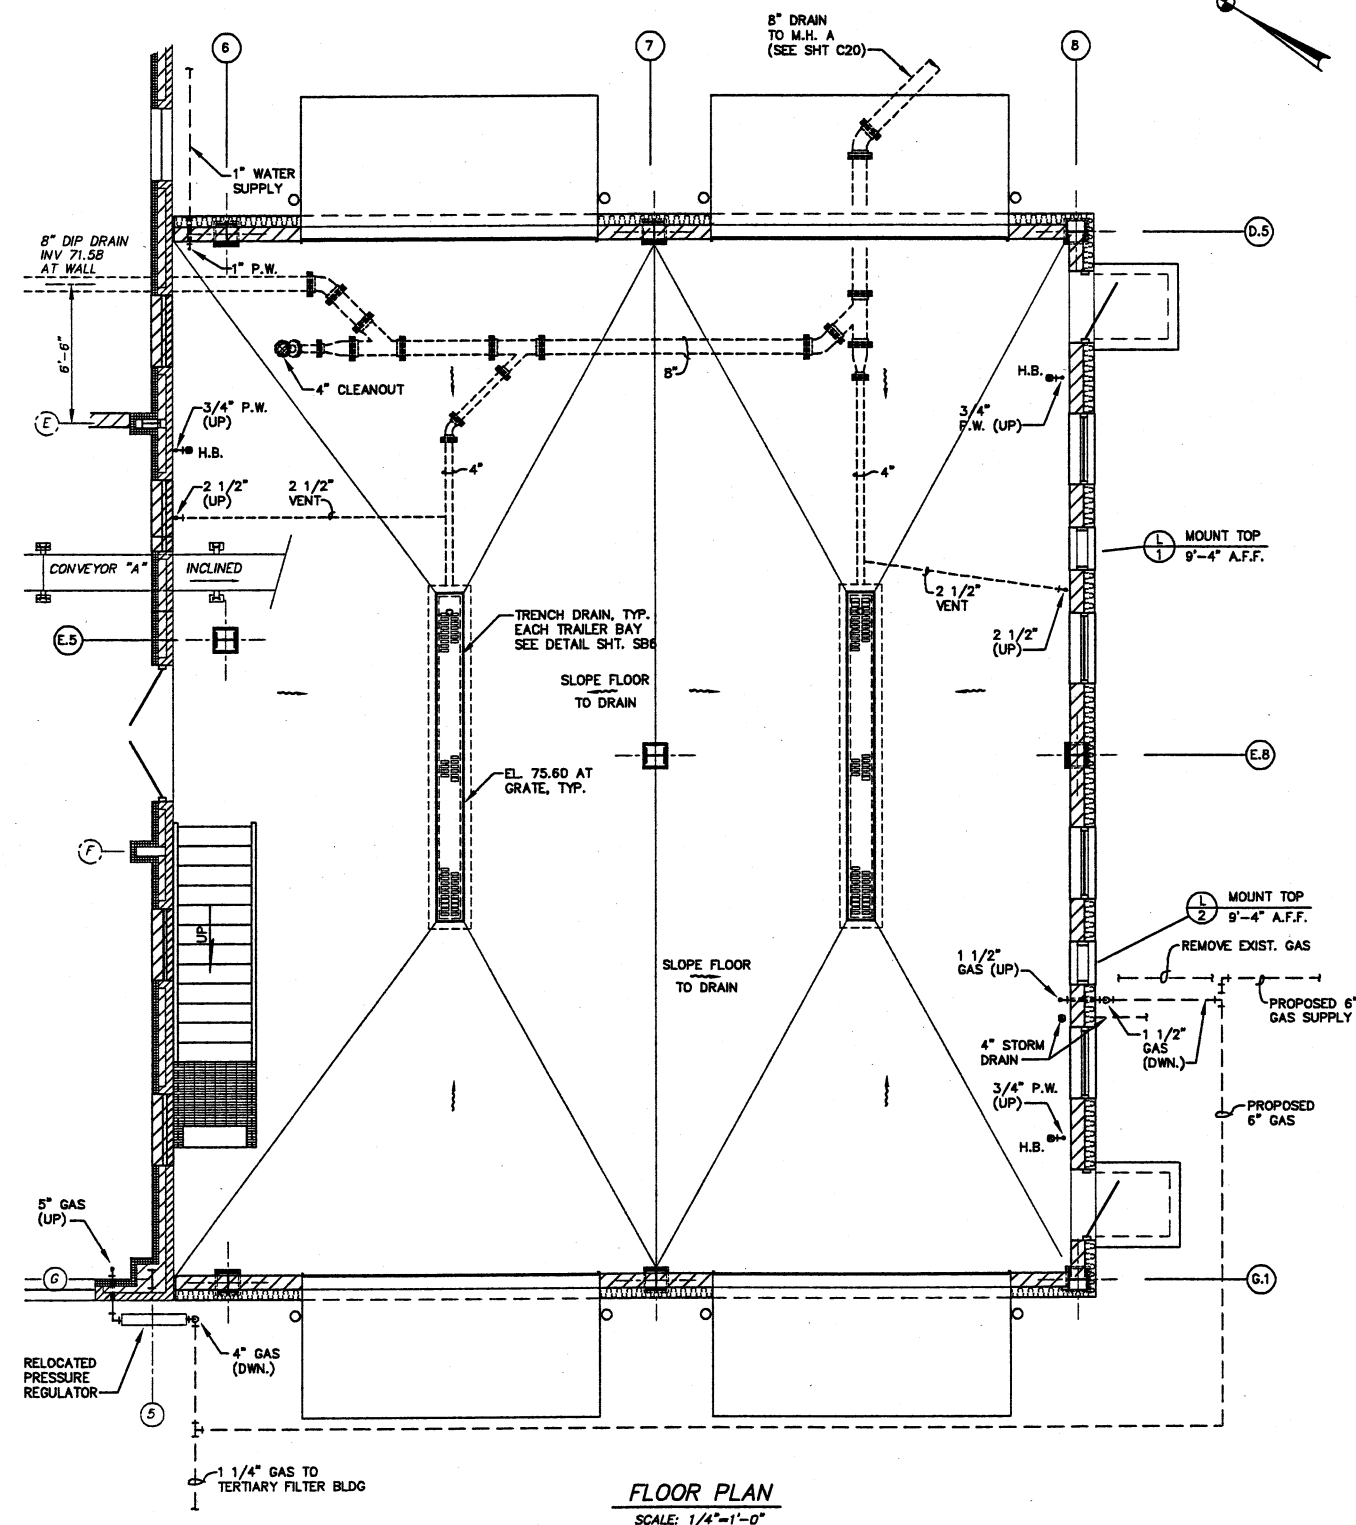

FLOOR PLAN
SCALE: 1/4\"=1'-0"

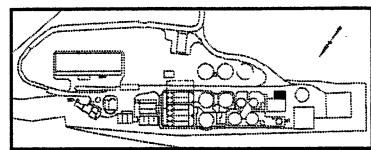

KEY PLAN

FPS
FINKBEINER, PETTIS & STROUT, INC.
ENGINEERS SINCE 1900
520 SOUTH MAIN STREET
ARROW, OHIO 44224

NO.	DESCRIPTIONS	DATE	BY	APP'D
1	DESIGNED BY		BOL	
2	DRAWN BY		CAS	
3	CHECKED BY		JLS	
4	APPROVED BY		DJK	

ENVIRONMENTAL, INC.
ENGINEERING, WATER AND EARTH SCIENCES
UNIONTOWN, OHIO

CITY OF MASSILLON, OHIO
WWTP UPGRADE 2000
SOLIDS HANDLING FACILITIES ADDITION
PLUMBING FLOOR PLAN AND SCHEMATICS

JOB NO.	E9031
DATE	8/13/01
SCALE	AS NOTED
SHEET	M12