


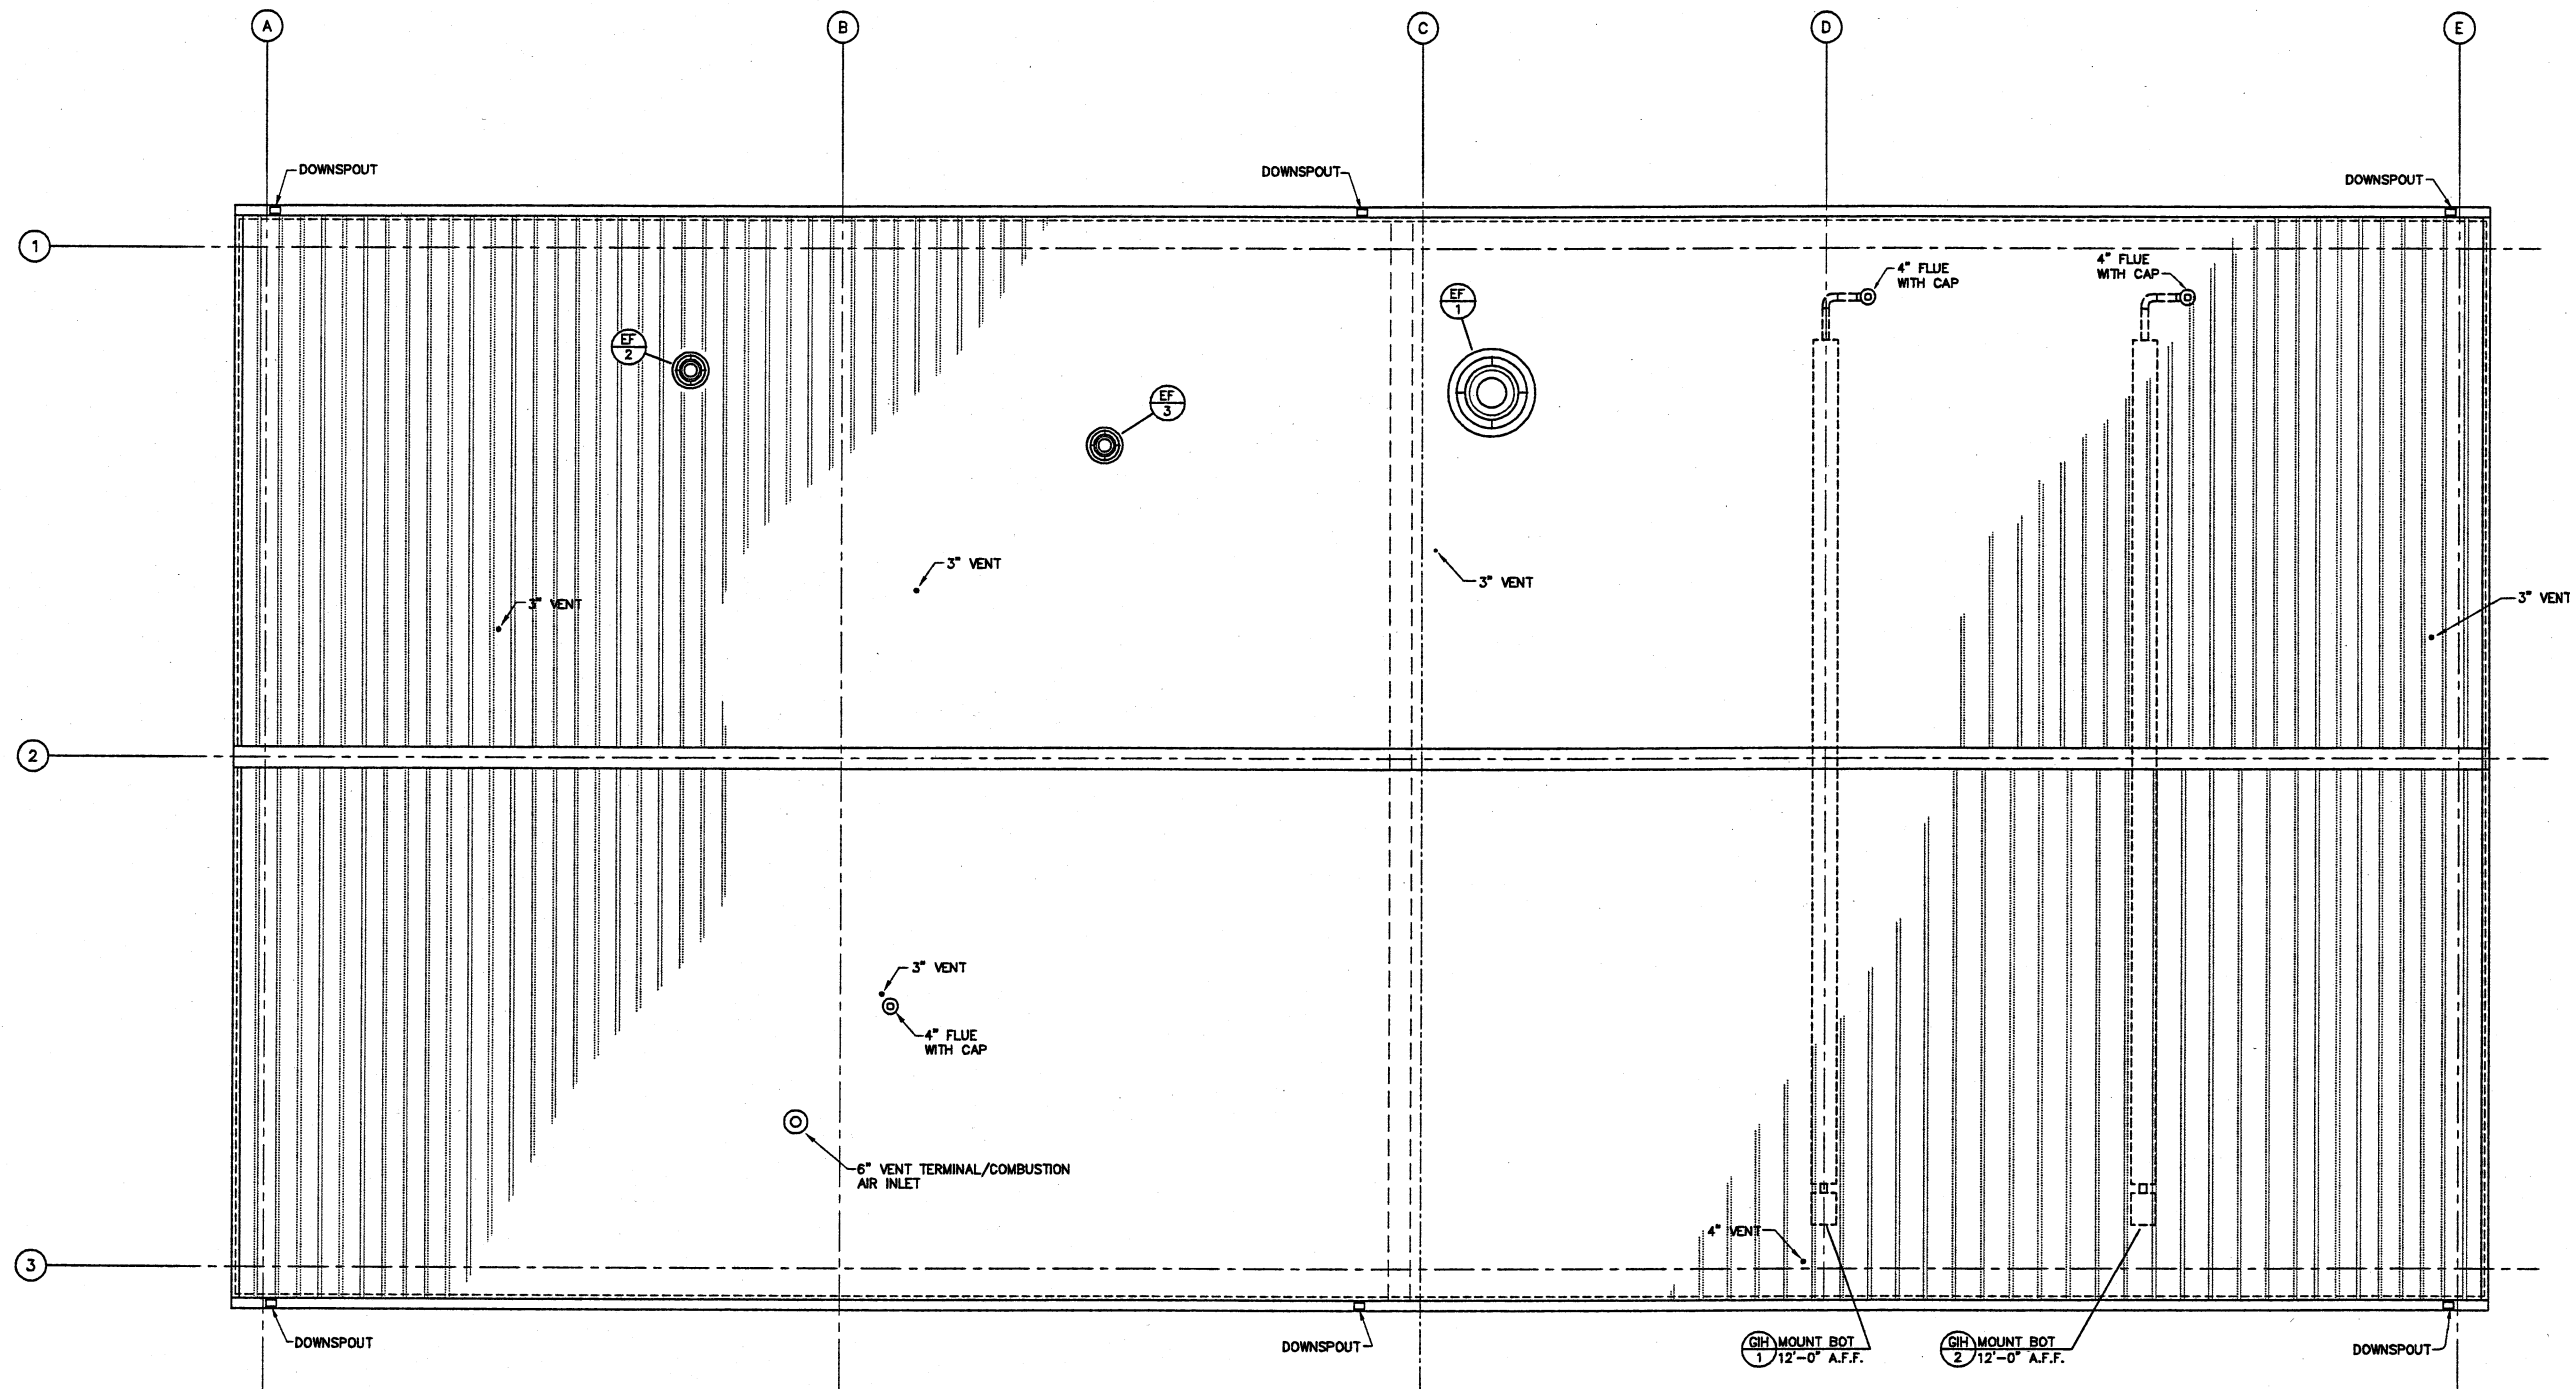

HVAC ROOF PLAN

PS
 FINKBEINER, PETTIS & STROUT, INC.
 ENGINEERS SINCE 1900
 520 SOUTH MAIN STREET
 ARRON, OHIO 44224

DESIGNED BY		DRAWN BY		CHECKED BY		APPROVED BY	
BDL		DMS		JLS		D.K.	
REVISIONS		DATE		BY		APP'D	
NO.	DESCRIPTIONS						

ENVIRONMENTAL, INC.
 ENGINEERS IN WATER AND EARTH SCIENCES
 UNIONTOWN, OHIO



CITY OF MASSILLON, OHIO
 WWTP UPGRADE 2000
 MAINTENANCE BUILDING HVAC ROOF PLAN

JOB NO.	E9031
DATE	8/13/01
SCALE	1/4"=1'-0"
SHEET	M4