


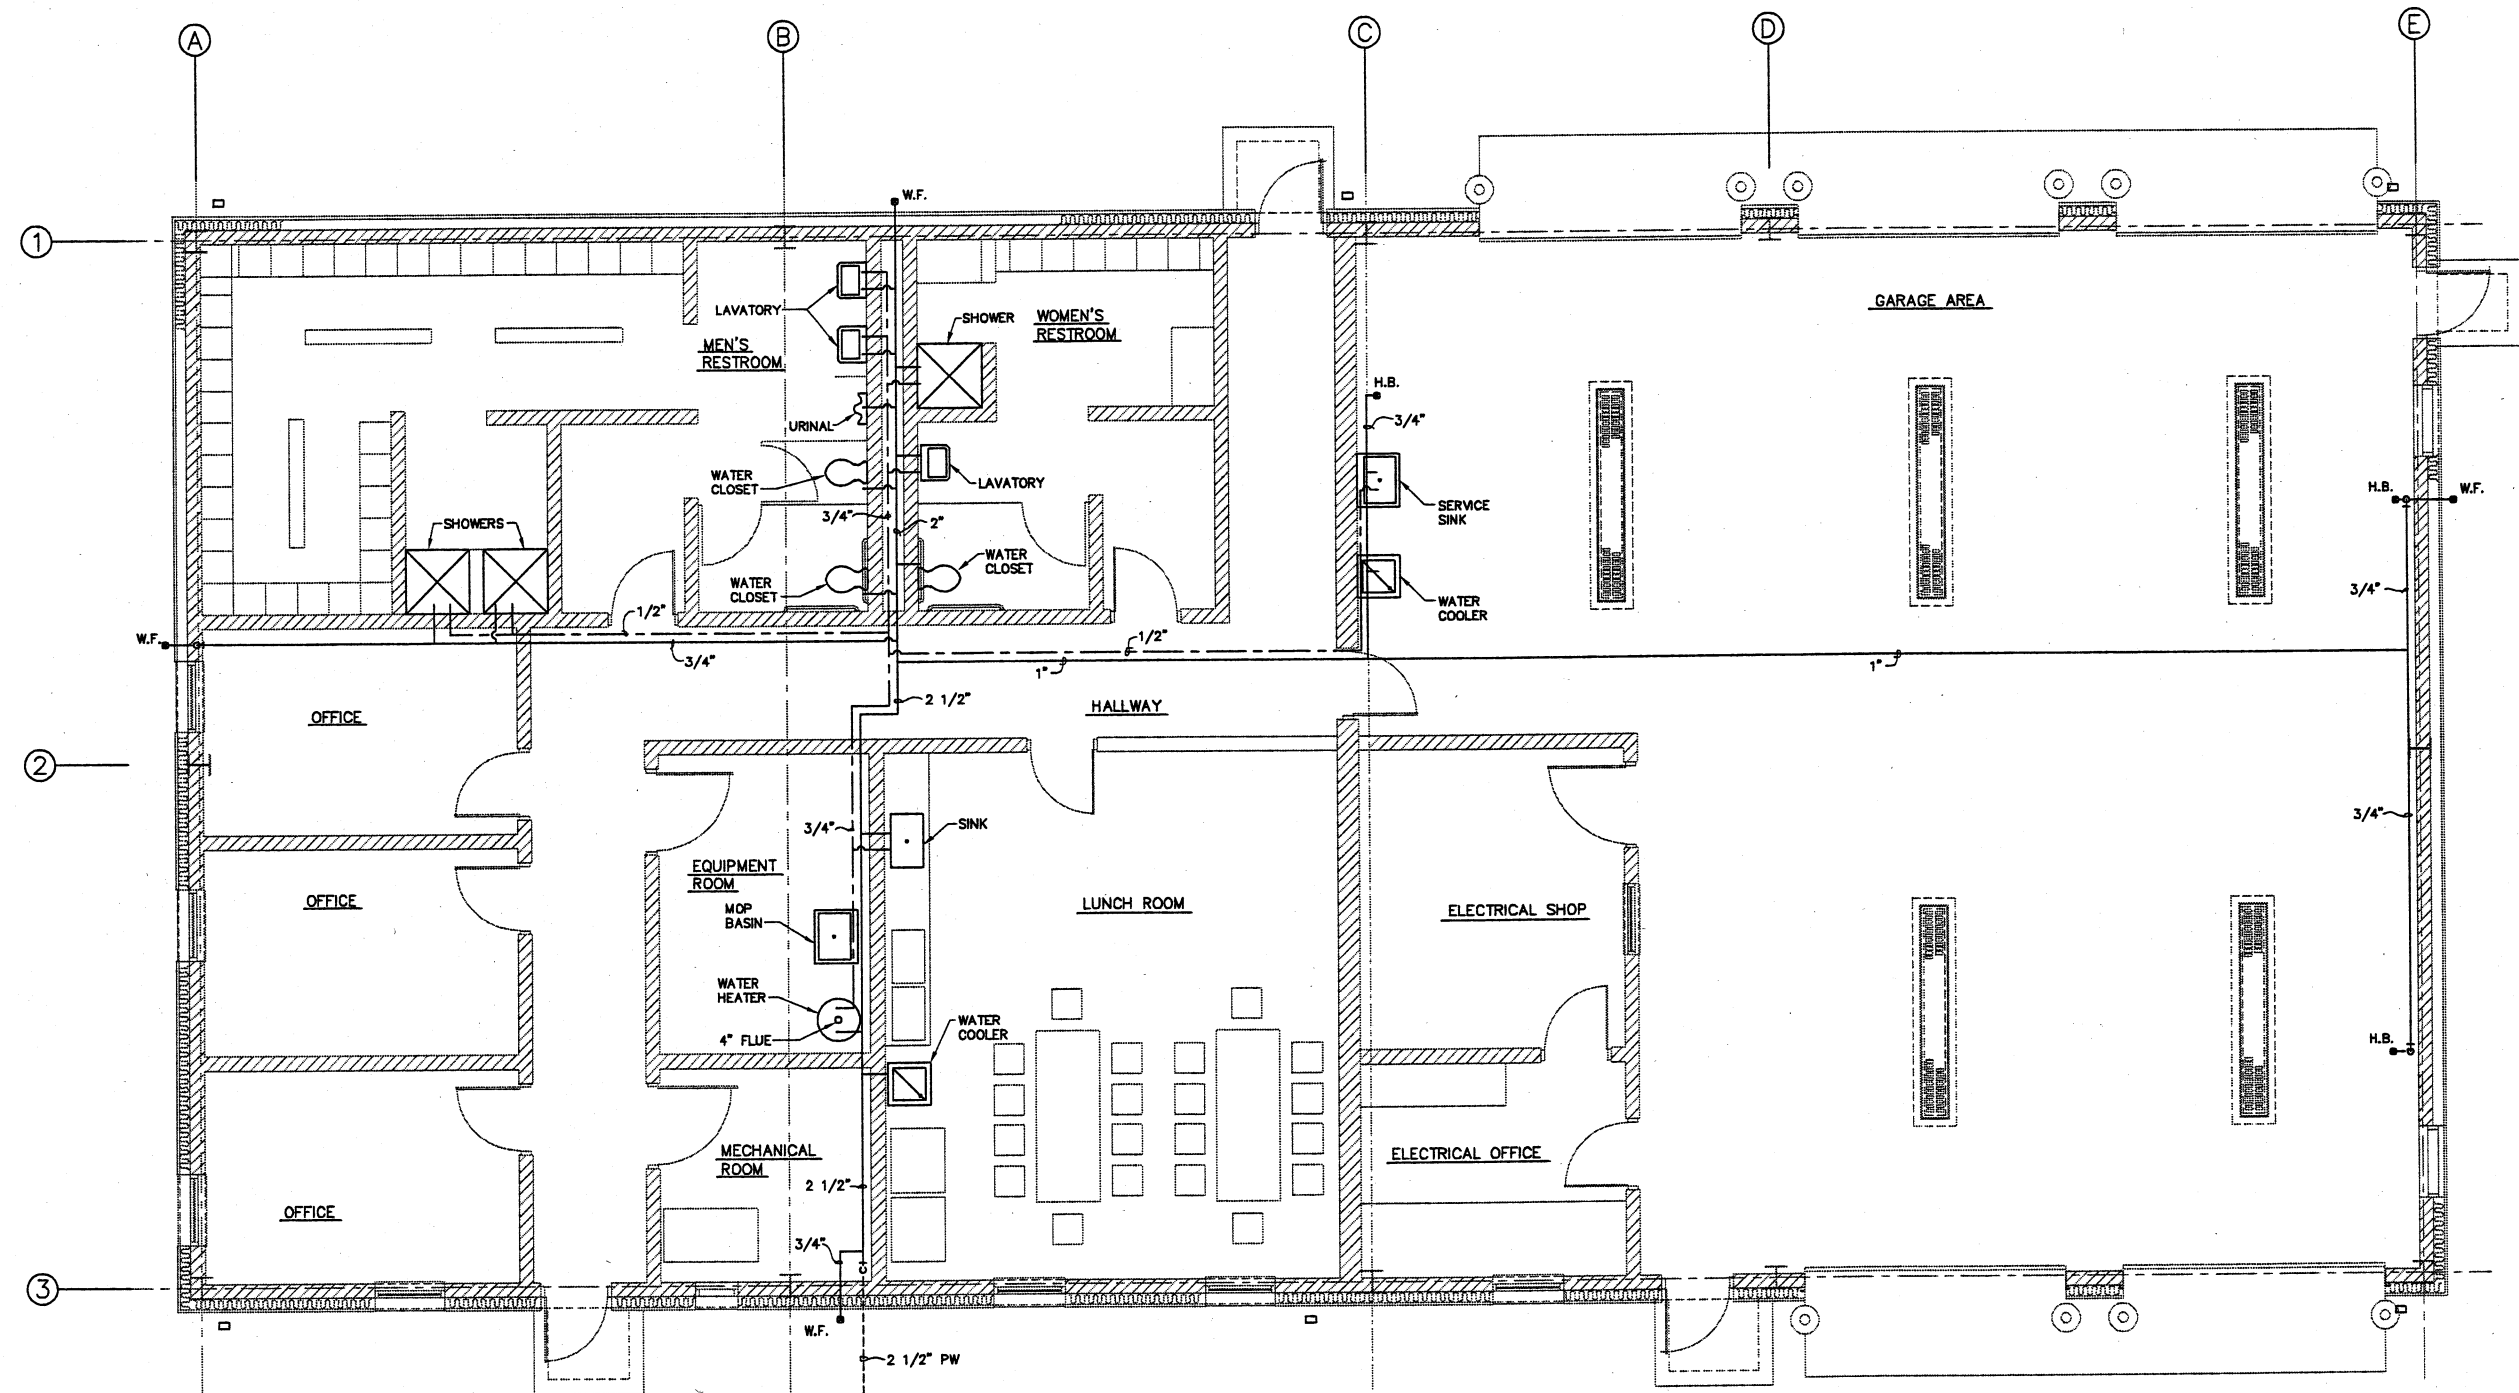

PLUMBING PLAN

FPS
 FINKBEINER, PETTIS & STROUT, INC.
 ENGINEERS SINCE 1800
 520 SOUTH MAIN STREET
 AKRON, OHIO 44324

REVISIONS			
NO.	DESCRIPTIONS	DATE	BY

CTI
 ENVIRONMENTAL, INC.
 ENGINEERS IN WATER AND EARTH SCIENCES
 UNIONTOWN, OHIO

CITY OF MASSILLON, OHIO
 WWTP UPGRADE 2000
 MAINTENANCE BUILDING PLUMBING FLOOR PLAN

JOB NO. E9031
DATE 8/13/01
SCALE 1/4"=1'-0"
SHEET M5