


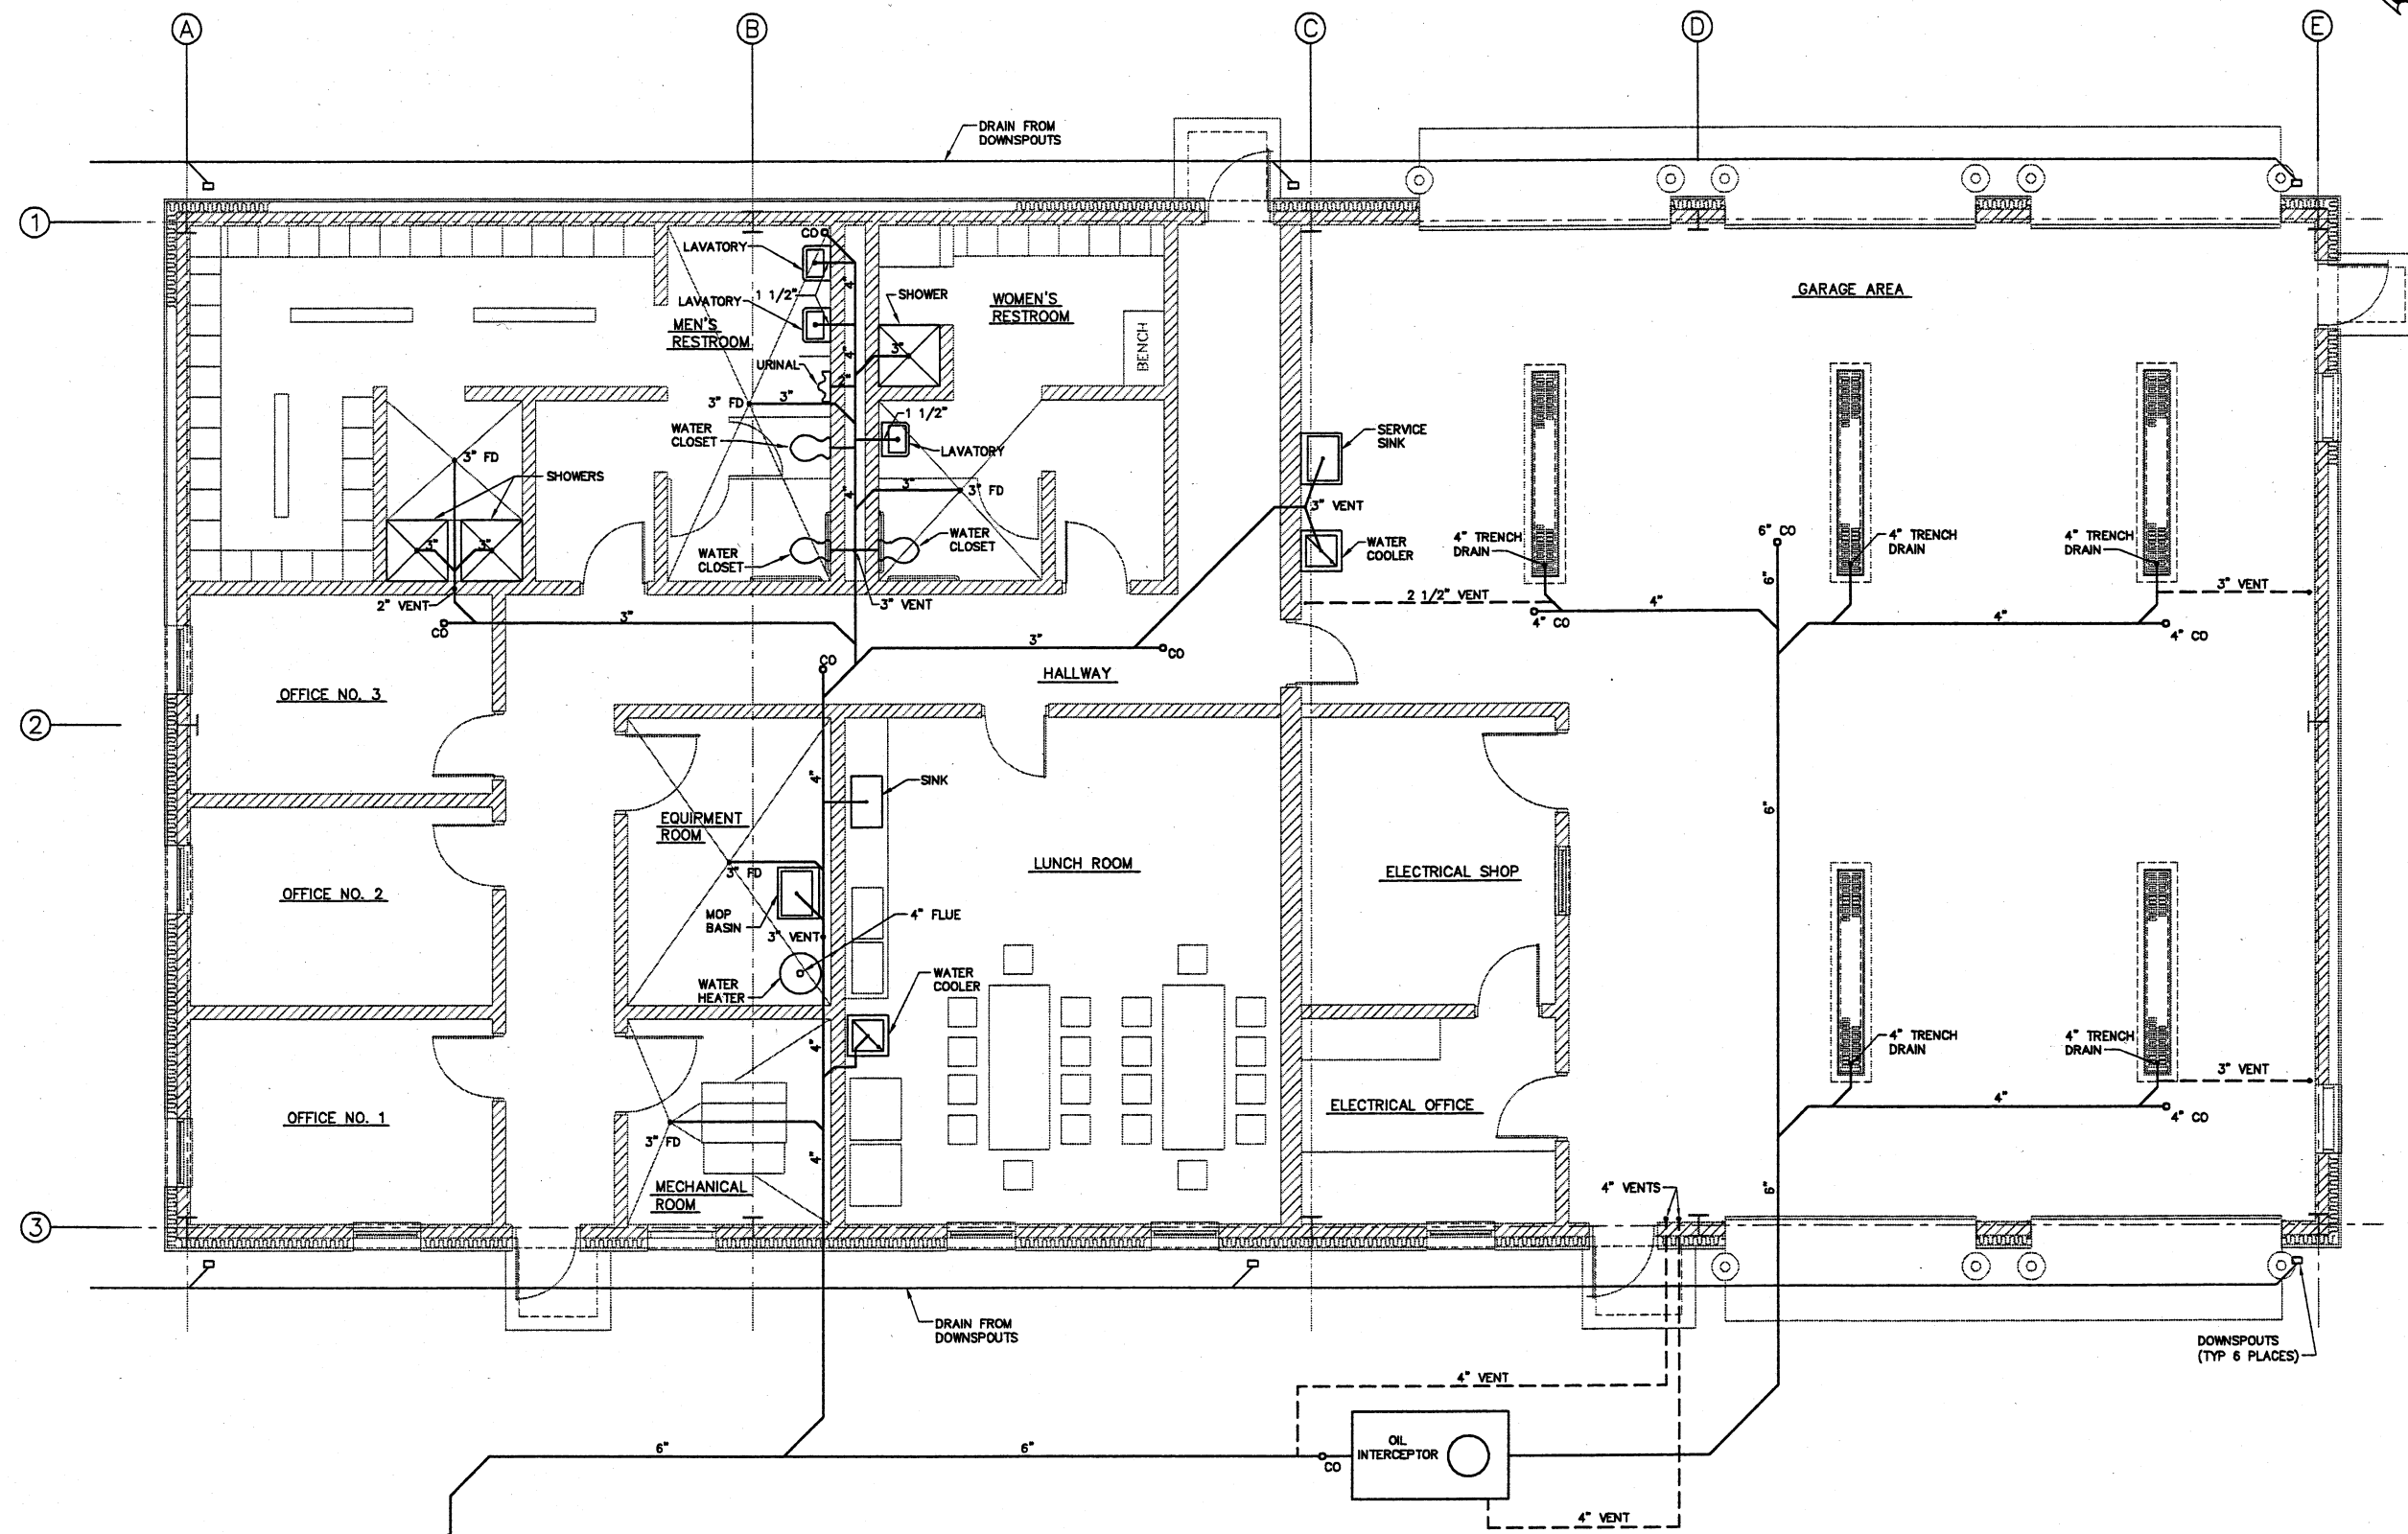

FRS
 FINKBEINER, PETTIS & STROUT, INC.
 ENGINEERS SINCE 1900
 520 SOUTH MAIN STREET
 AKRON, OHIO 44324

DESIGNED BY	NO.	DATE	BY	APP'D
BDL				
DMS				
JLS				
DJK				

CEI
 ENVIRONMENTAL, INC.
 WATER AND EARTH SCIENCES
 CLEVELAND, OHIO

**CITY OF MASSILLON, OHIO
 WWP UPGRADE 2000
 MAINTENANCE BUILDING SANITARY FLOOR PLAN**

JOB NO. E9031
DATE 8/13/01
SCALE 1/4"=1'-0"
SHEET M6