




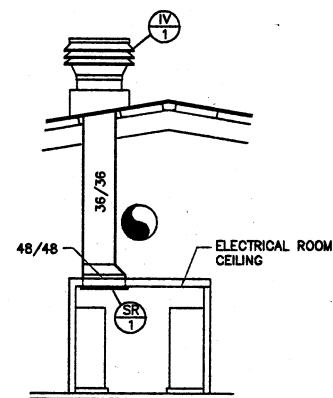


SECTION
SCALE: 1/8"=1'-0" B
M9

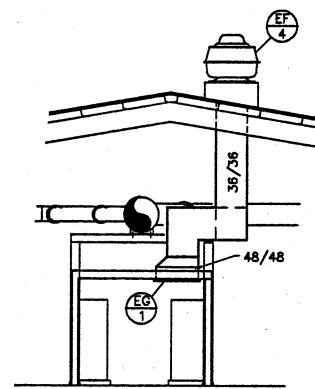

SECTION
SCALE: 1/8"=1'-0" A
M9

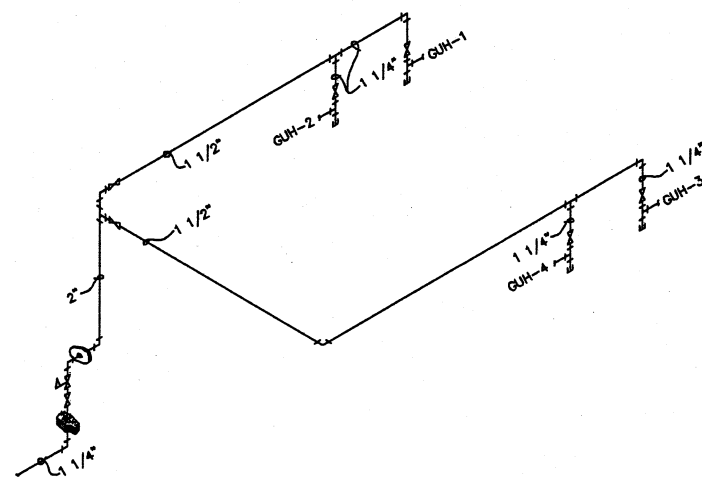

GAS SCHEMATIC
SCALE: NONE

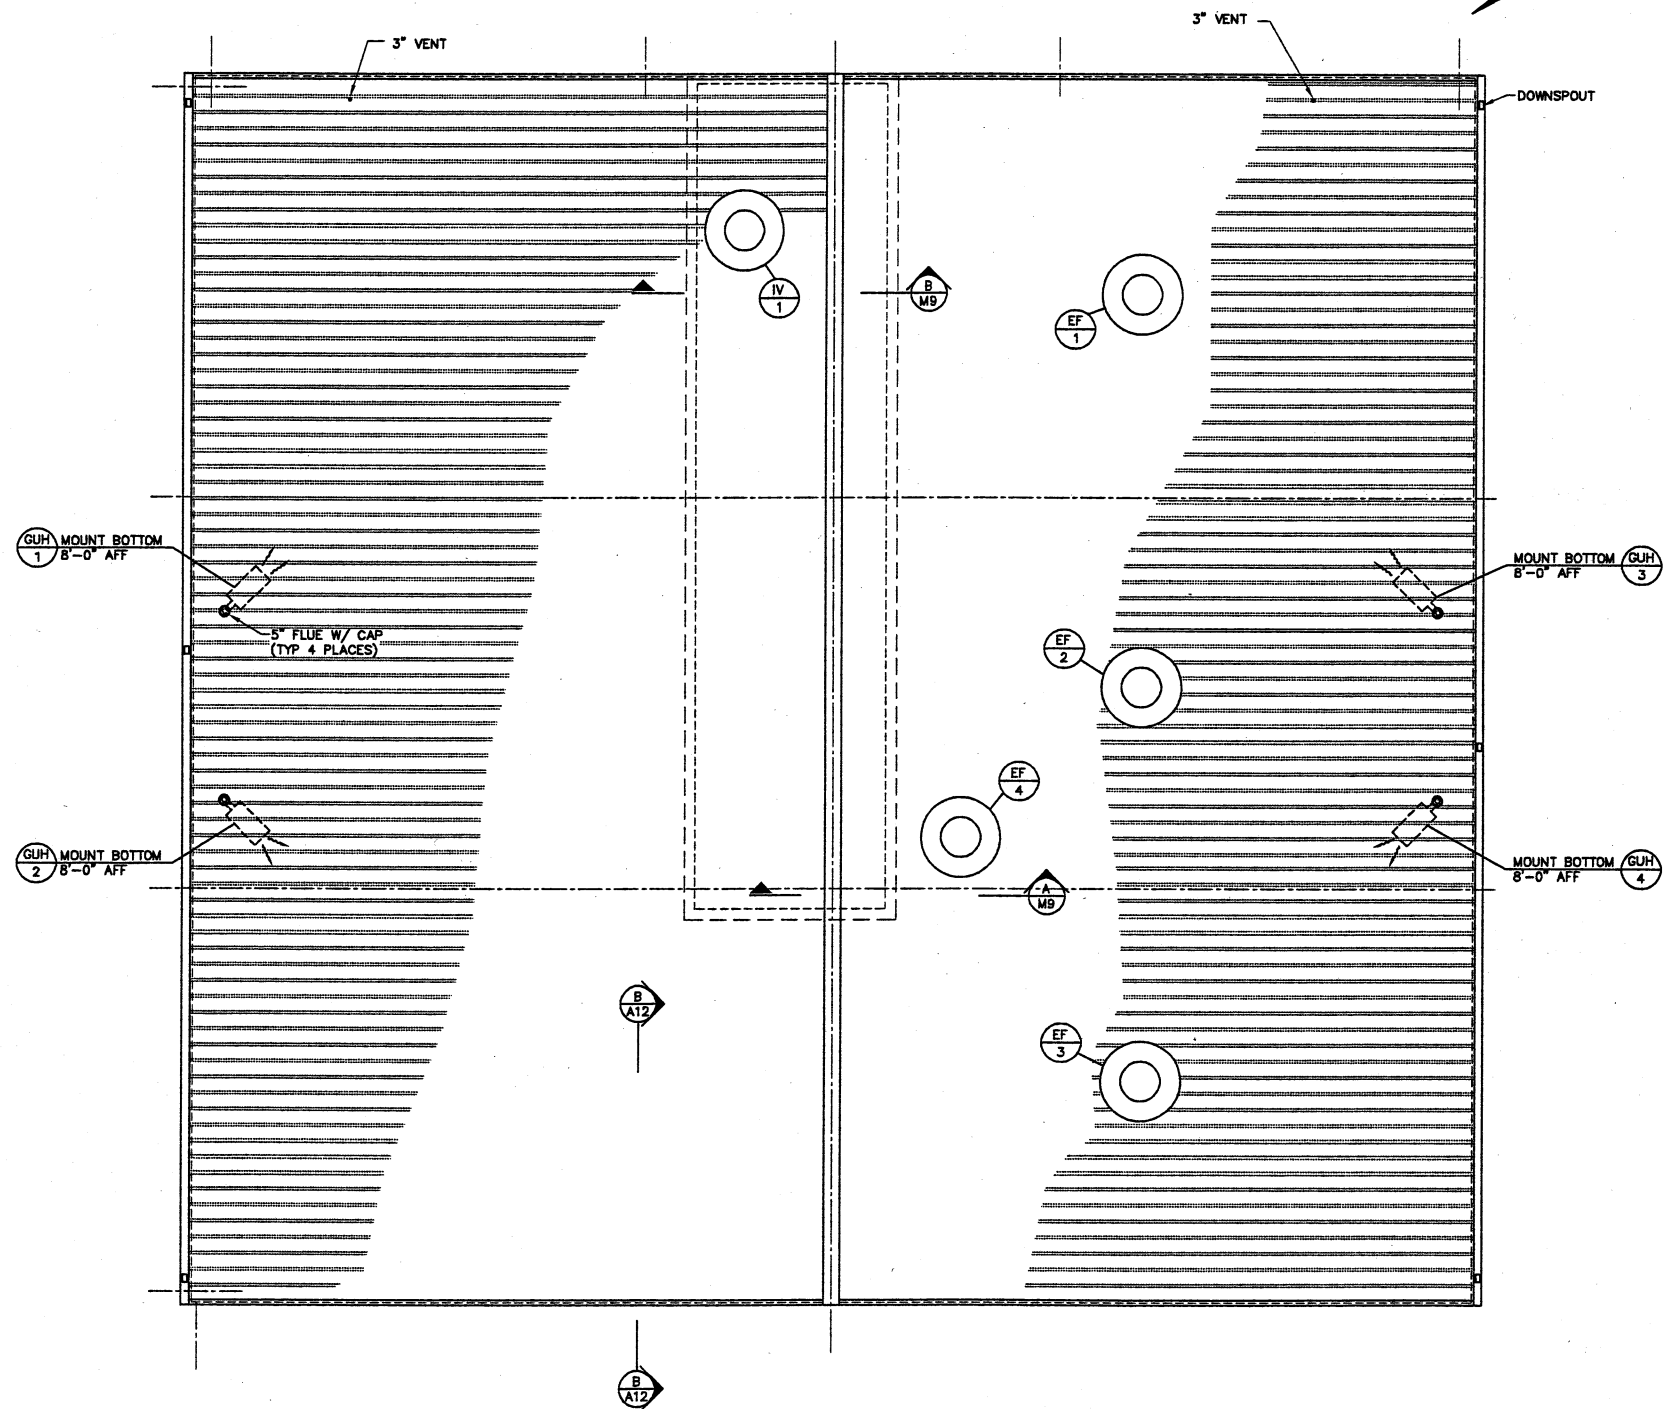

ROOF PLAN
SCALE: 3/16"=1'-0"

FPS
FINKBEINER, PETTIS & STROUT, INC.
ENGINEERS SINCE 1900
520 SOUTH MAIN STREET
AGRON, OHIO 44224

DESIGNED BY	GLB	DATE	BY	APP'D
DRAWN BY	MWH			
CHECKED BY	JLS			
APPROVED BY	DUK			

CHI ENVIRONMENTAL, INC.
WATER AND EARTH SCIENCES
UNIONTOWN, OHIO
CITY OF MASSILLON, OHIO
WWTP UPGRADE 2000
BLOWER BUILDING HVAC ROOF PLAN

JOB NO.	E9031
DATE	8/13/01
SCALE	AS NOTED
SHEET	M9