


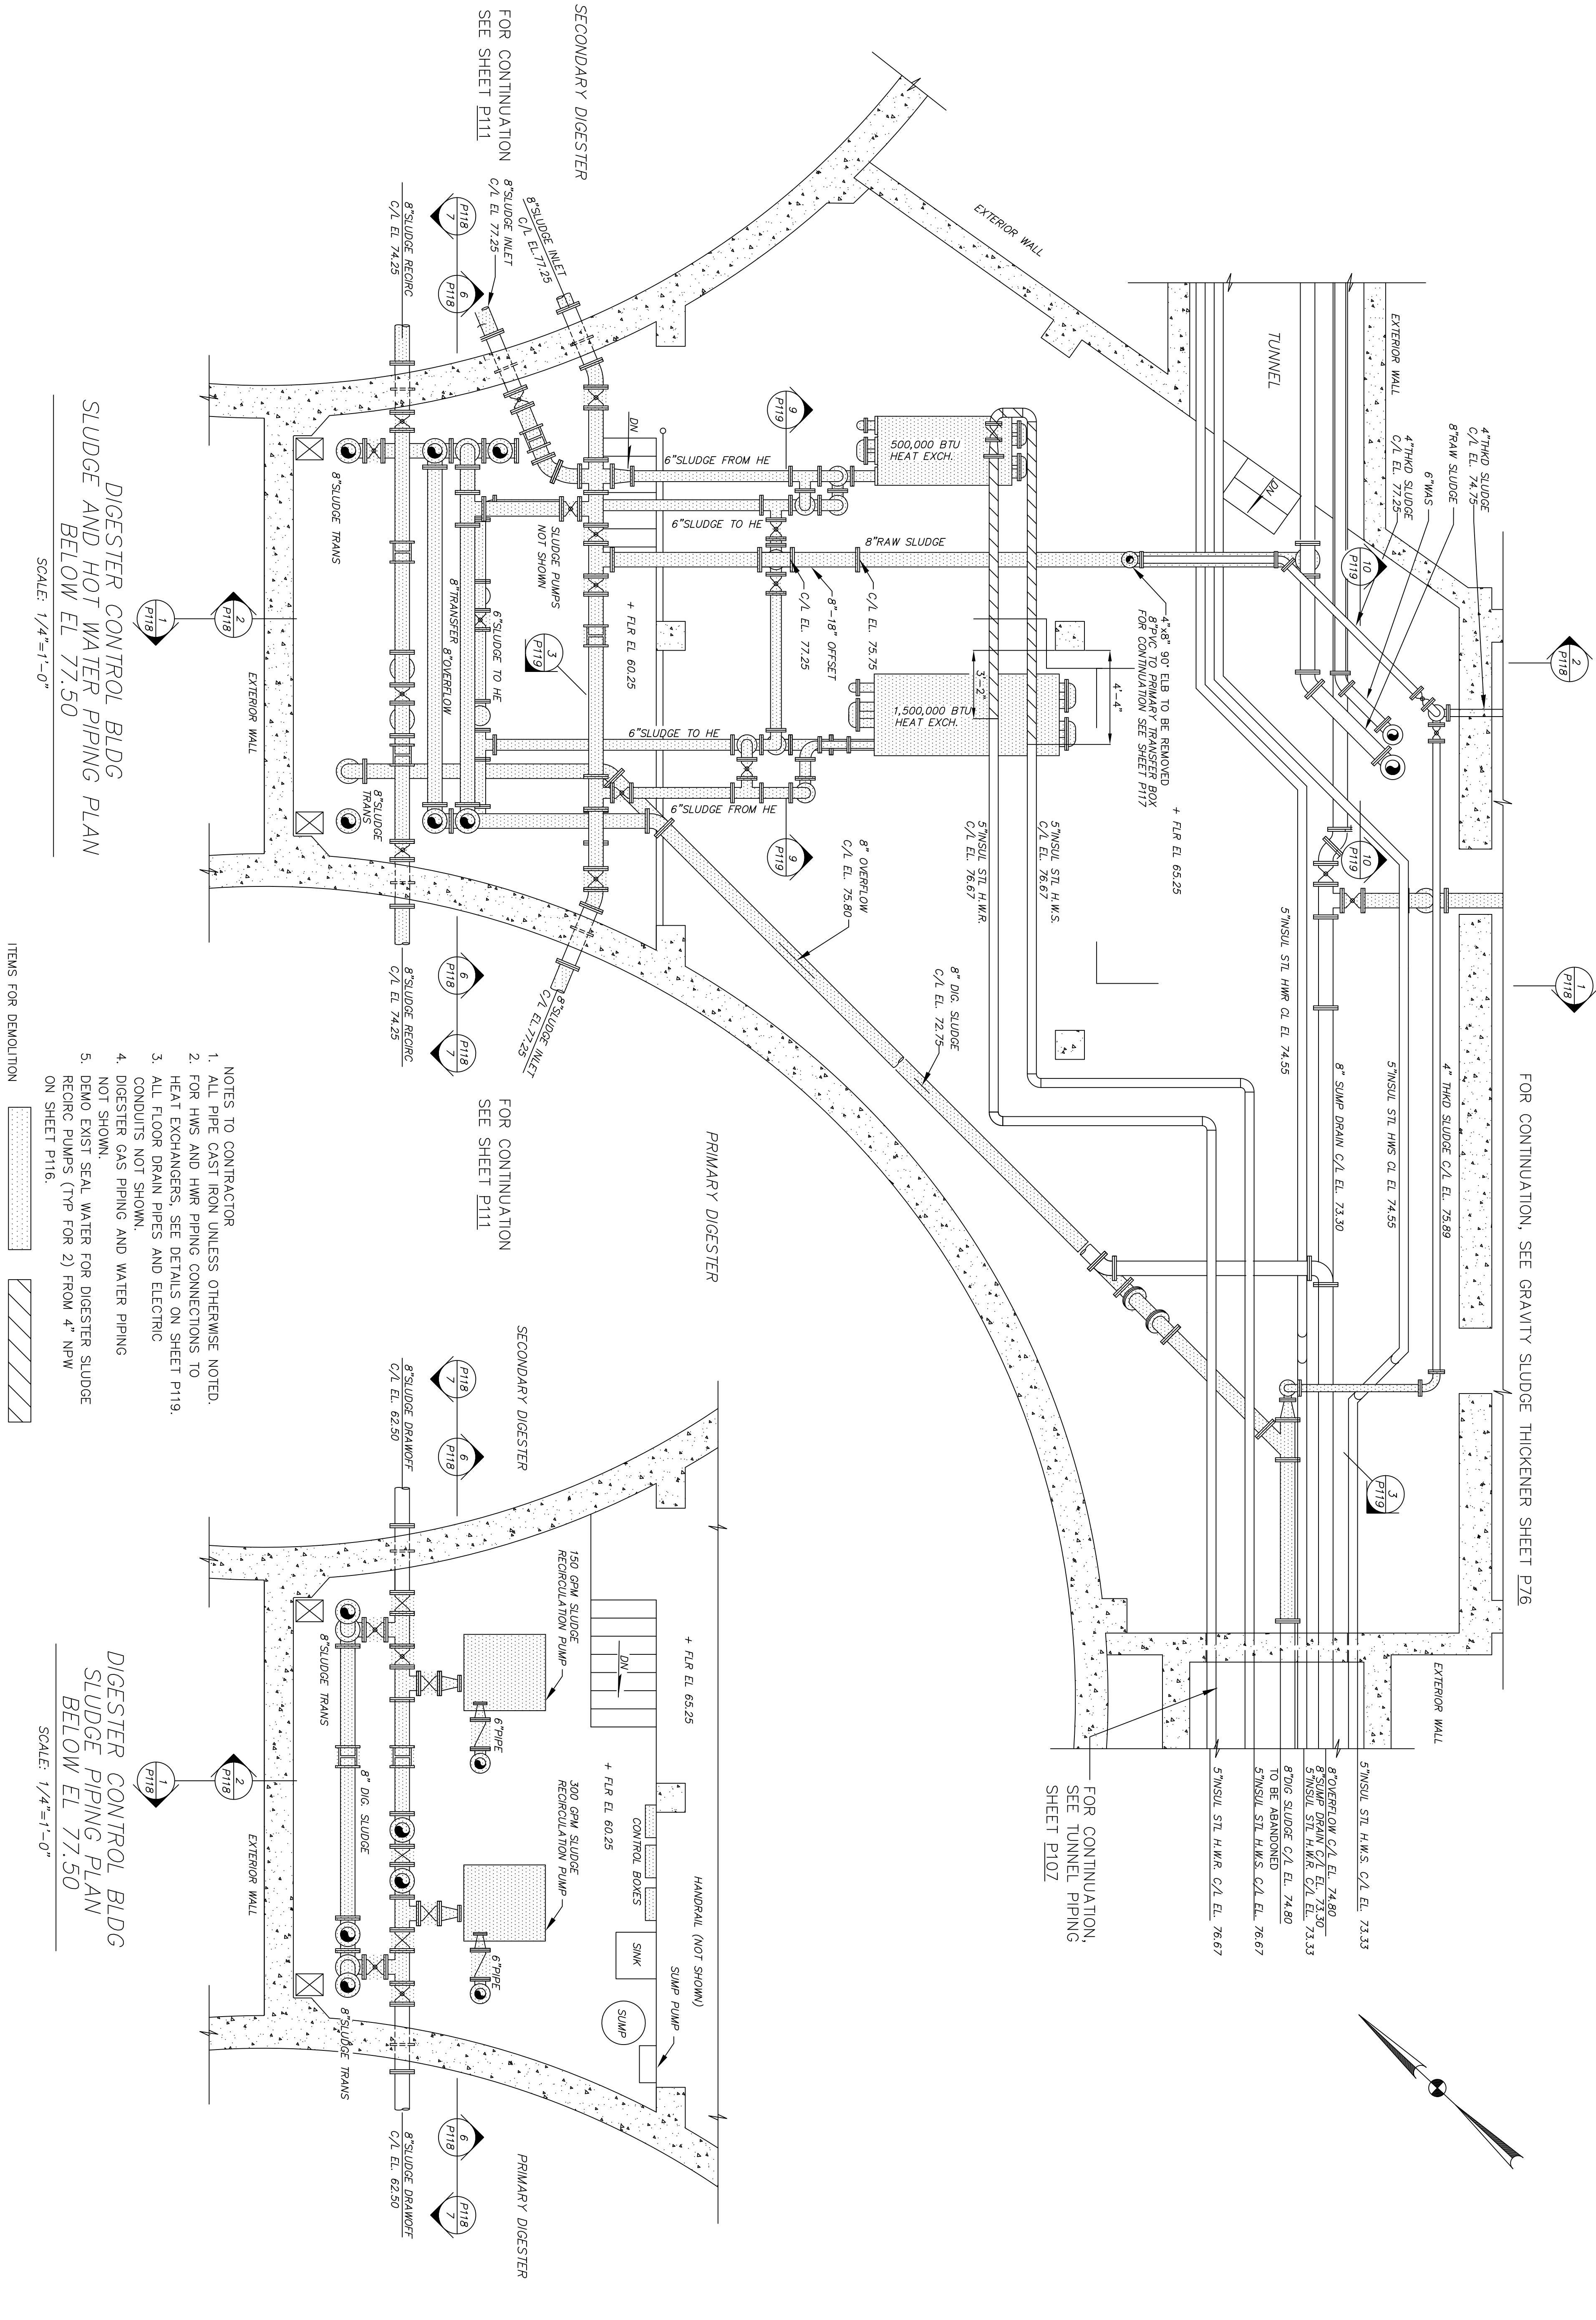

DIGESTER CONTROL BLDG
SLUDGE AND HOT WATER PIPING PLAN
BELOW EL 77.50

SCALE: 1/4"=1'-0"

- ITEMS FOR DEMOLITION
- ALL PIPE CAST IRON UNLESS OTHERWISE NOTED.
 - FOR HWS AND HWR PIPING CONNECTIONS TO HEAT EXCHANGERS, SEE DETAILS ON SHEET P119.
 - ALL FLOOR DRAIN PIPES AND ELECTRIC CONDUITS NOT SHOWN.
 - DIGESTER GAS PIPING AND WATER PIPING NOT SHOWN.
 - DEMO EXIST SEAL WATER FOR DIGESTER SLUDGE RECIRC PUMPS (TYP FOR 2) FROM 4" NW ON SHEET P116.

DIGESTER CONTROL BLDG
SLUDGE PIPING PLAN
BELOW EL 77.50

SCALE: 1/4"=1'-0"




ENVIRONMENTAL, INC.
ENGINEERS IN WATER AND EARTH SCIENCES
UNIONTOWN, OHIO

CITY OF MASSILLON, OHIO
WWTP UPGRADE 2000
DIGESTER CONTROL BUILDING LOWER PLAN-DEMOLITION

DESIGNED BY PMK/AJP	REVISIONS				
	NO.	DESCRIPTIONS	DATE	BY	APP'D
DRAWN BY AJP	1	RECORD DRAWING	5/05	MGW	WAD
CHECKED BY RWR					
APPROVED BY WAD					

THIS DRAWING IS AN INSTRUMENT OF SERVICE OWNED BY CTI ENVIRONMENTAL, INC. WHICH SHALL BE DEEMED THE AUTHOR AND WHICH SHALL RETAIN ALL STATUTORY AND COMMON LAW RIGHTS, INCLUDING COPYRIGHTS. THIS DRAWING SHALL NOT BE SCANNED, COPIED, OR DISTRIBUTED TO OTHERS IN ANY FORM OR USED FOR ANY OTHER PURPOSE OR PROJECT WITHOUT PRIOR WRITTEN CONSENT OF CTI ENVIRONMENTAL, INC. CTI ENVIRONMENTAL, INC. CANNOT GUARANTEE THAT ELECTRONIC COPIES OF THIS DRAWING ARE EXACT DUPLICATES OF THE SEALED ORIGINAL DRAWING. IN THE EVENT OF A CONFLICT BETWEEN AN ELECTRONIC COPY AND THE SEALED ORIGINAL, THE SEALED ORIGINAL SHALL GOVERN.

KEY PLAN

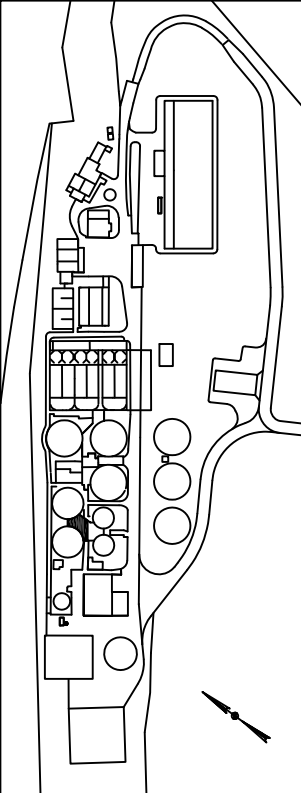

DWG NO. E9031
DATE 08/13/01
SCALE 1/4"=1'-0"
SHEET P115