




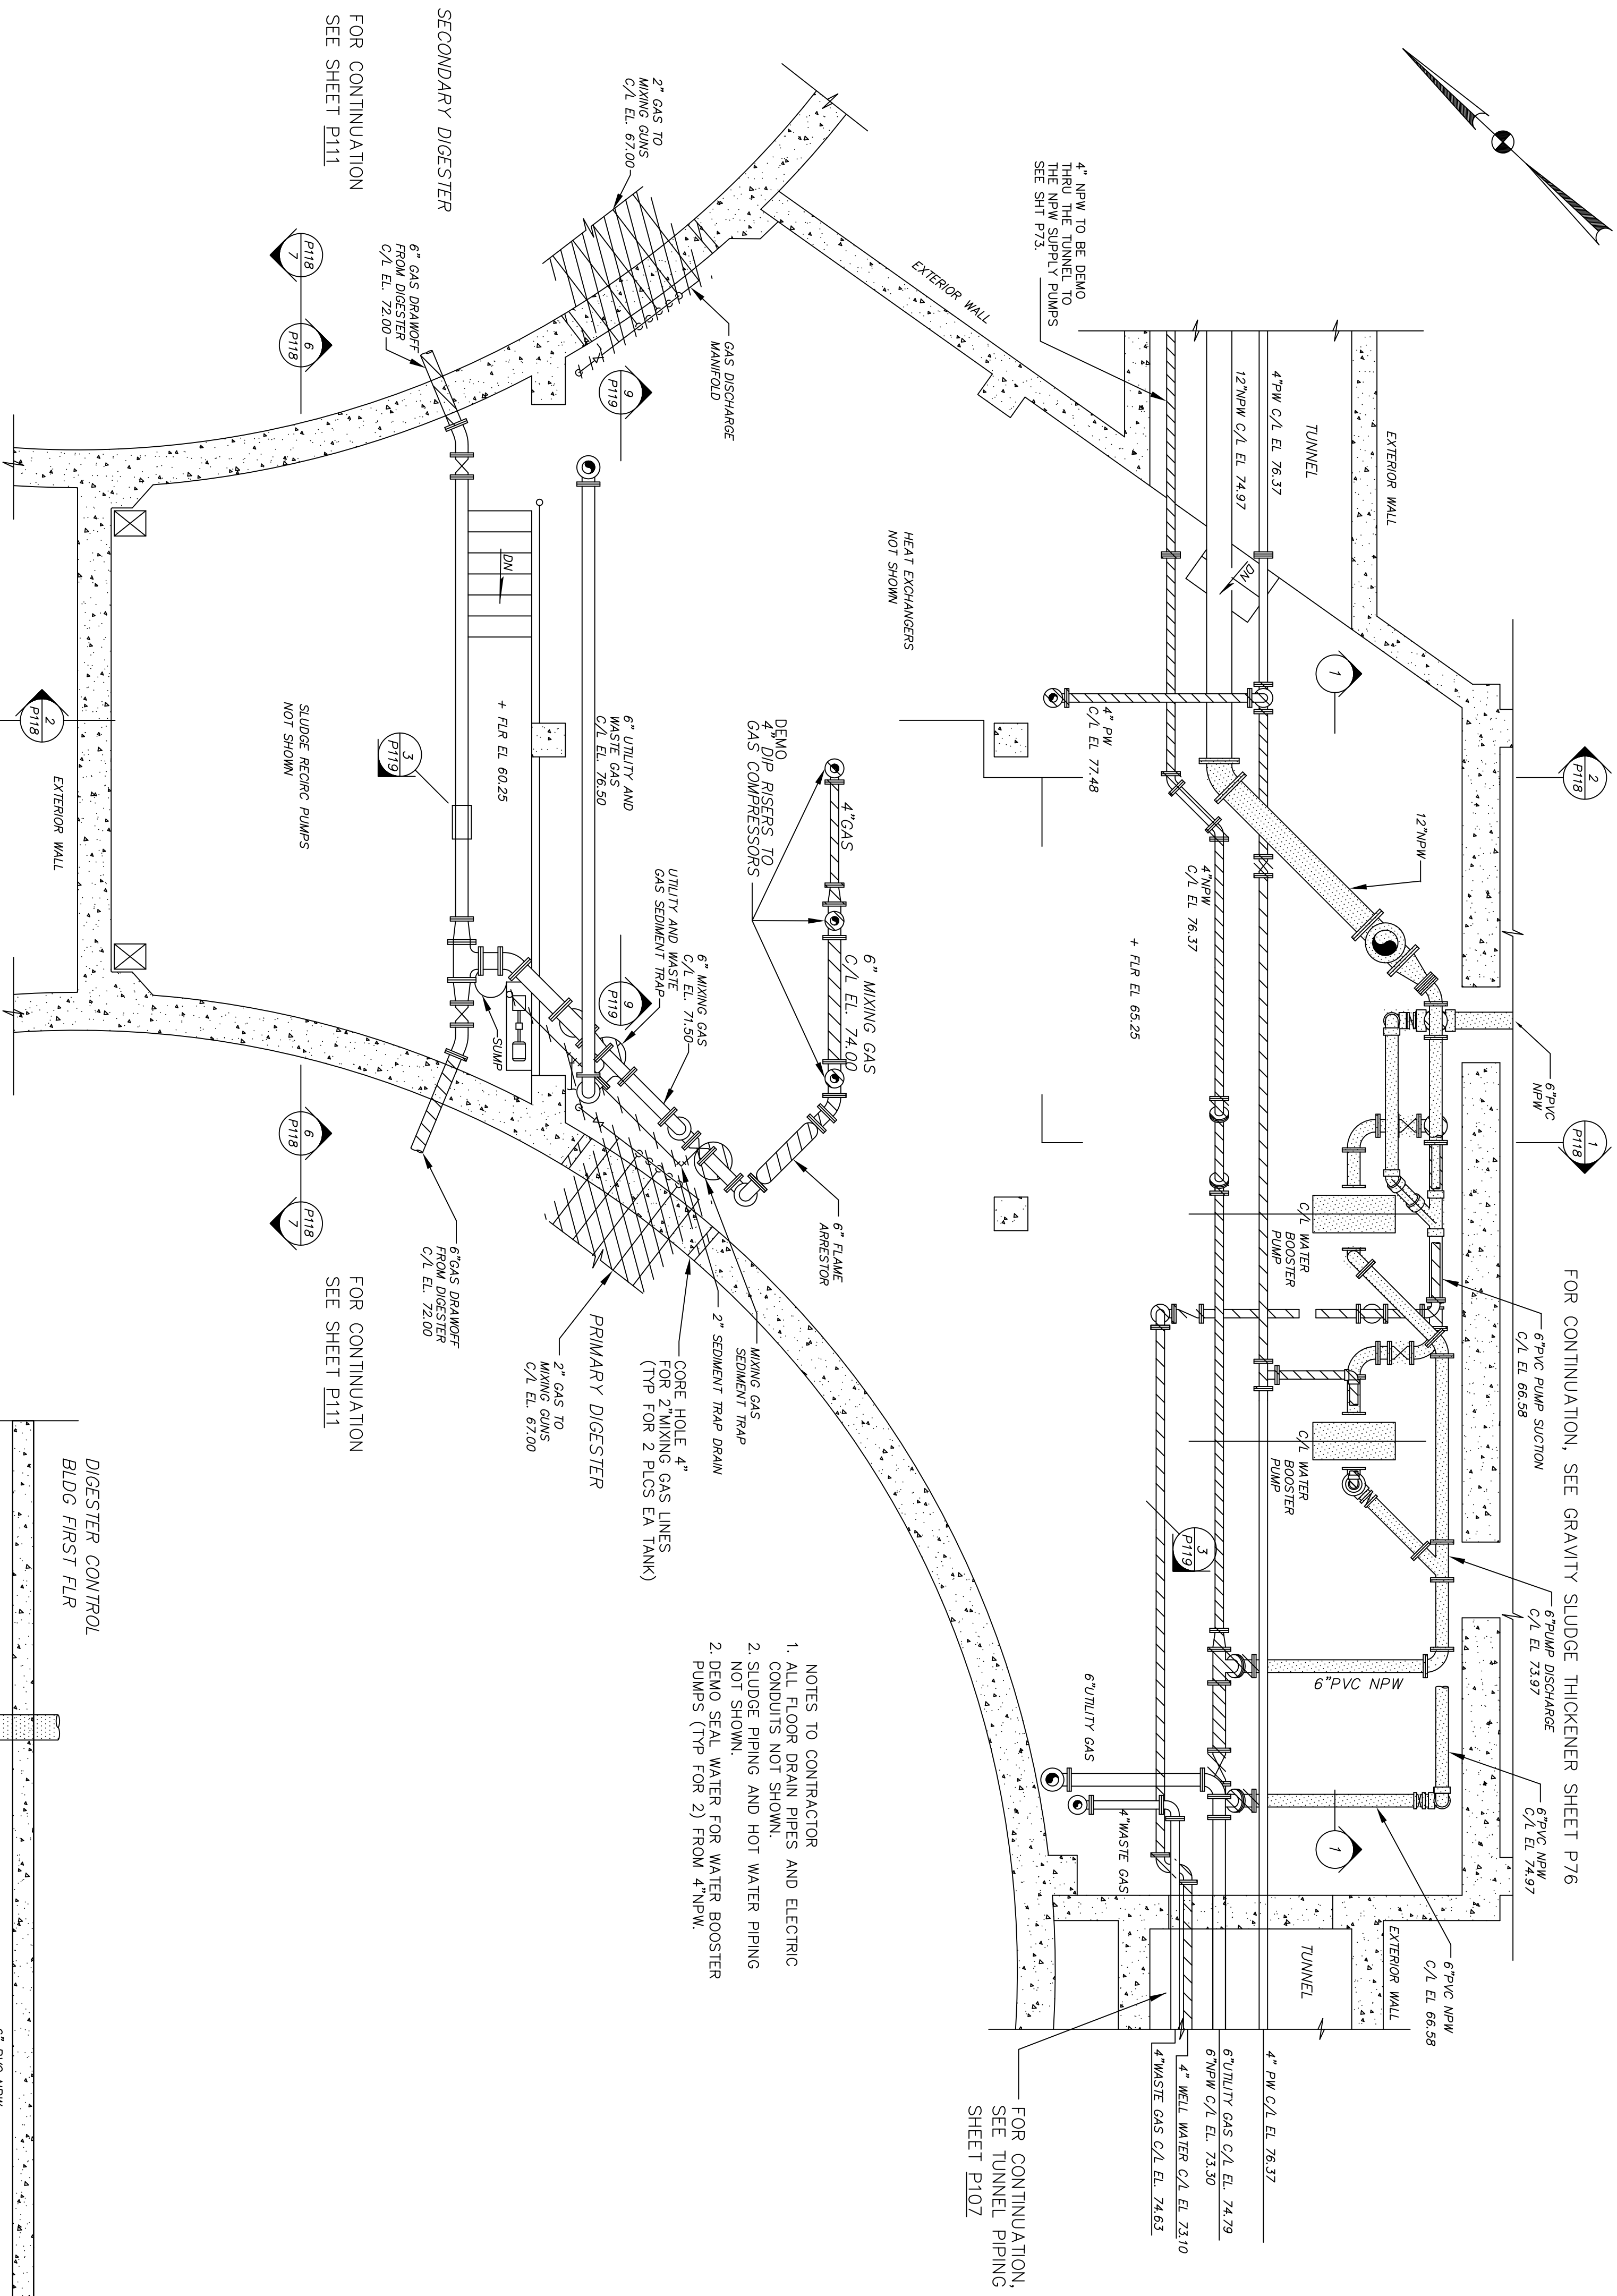


DIGESTER CONTROL BLDG
GAS AND WATER PIPING PLAN
BELOW EL 77.50
SCALE: 1/4"=1'-0"

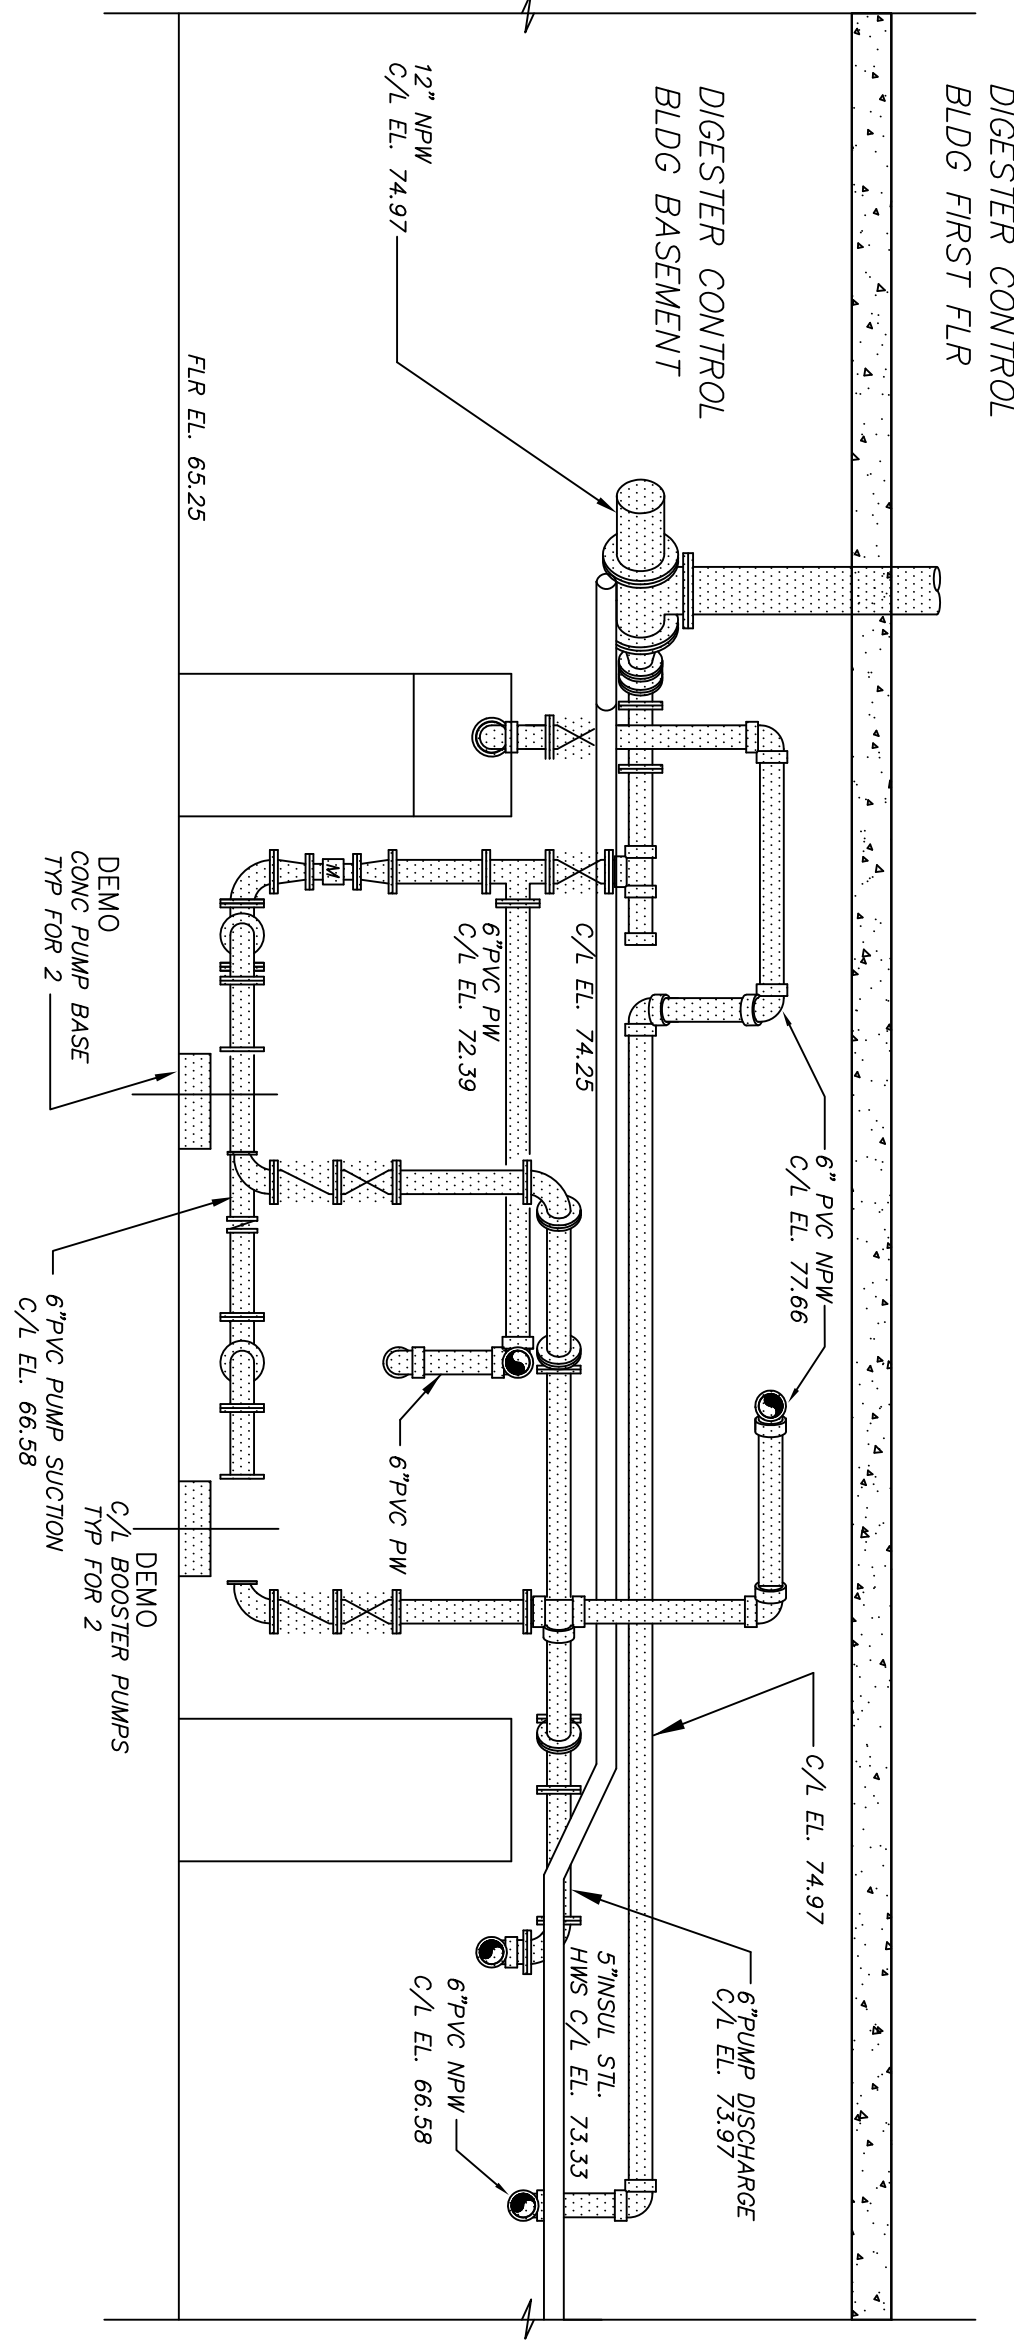

SECTION
SCALE: 1/4"=1'-0"

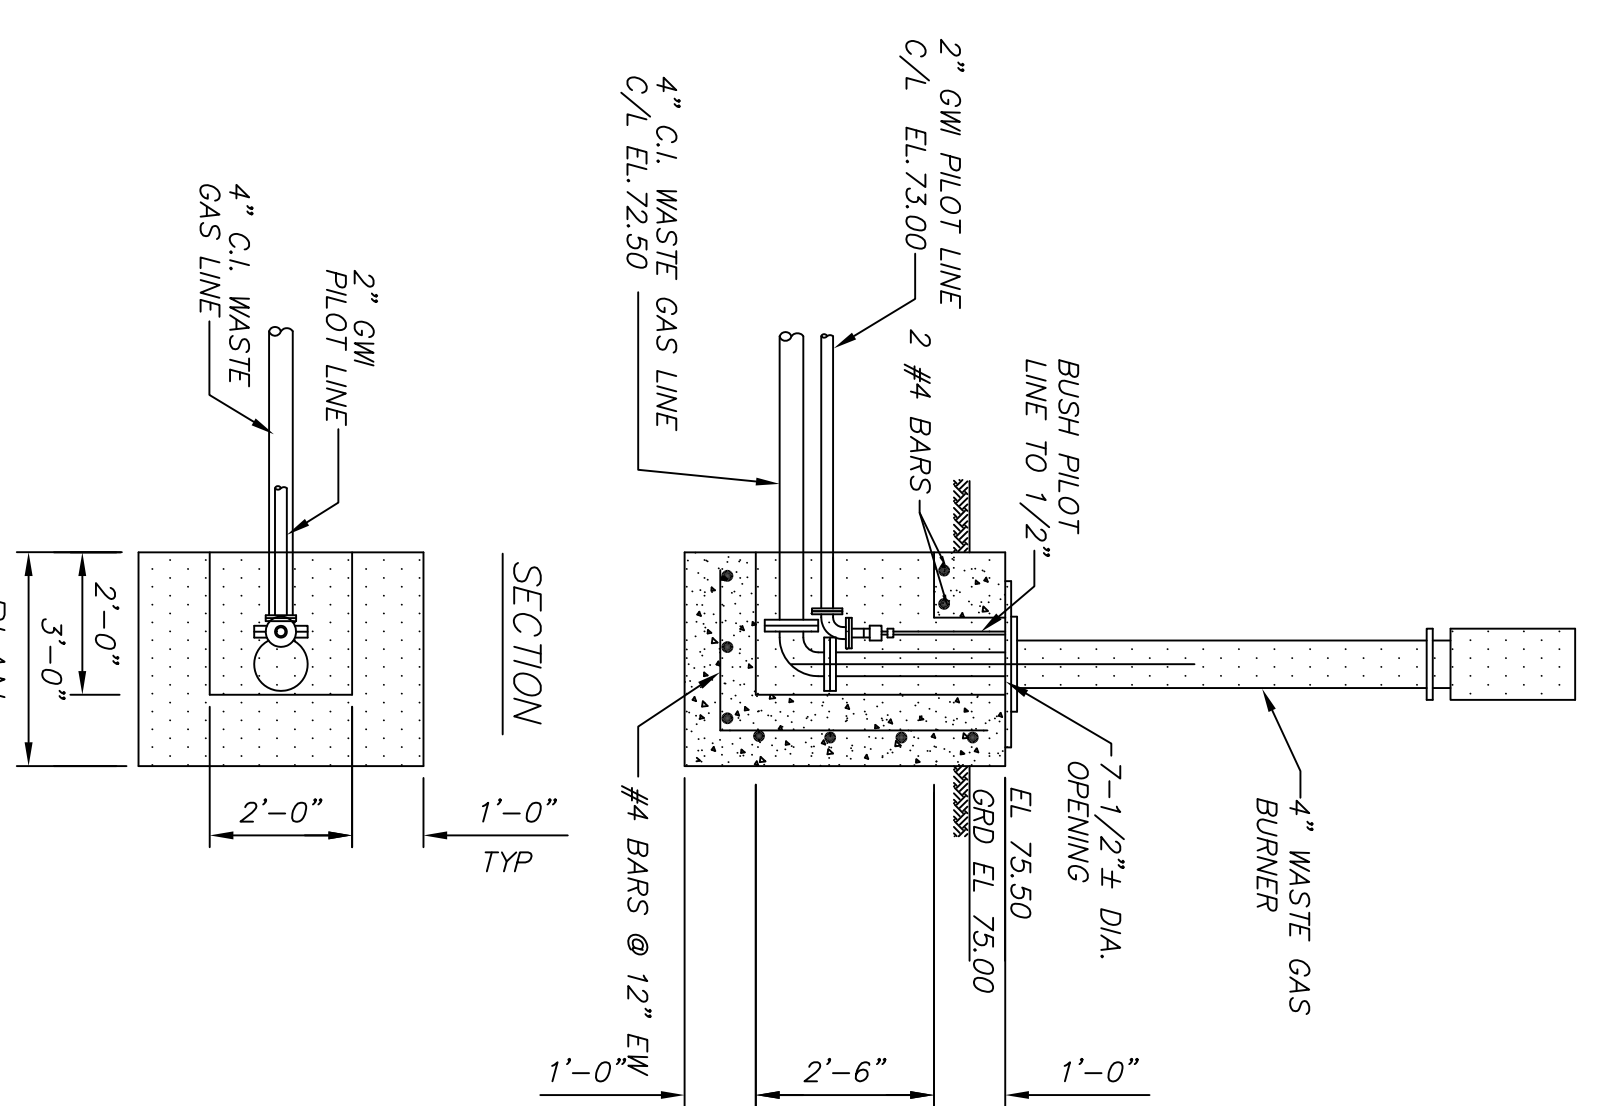

 EXISTING WASTE GAS BURNER
SCALE 3/8"=1'-0"



THESE RECORD DOCUMENTS HAVE BEEN PREPARED
BASED ON INFORMATION PROVIDED BY OTHERS. CTE
ENVIRONMENTAL HAS REVIEWED THE INFORMATION
SUBMITTED AND BELIEVES IT REFLECTS THE WORK
AS CONSTRUCTED. HOWEVER, ALL PERSONS SHALL
VERIFY INFORMATION TAKEN FROM THIS DRAWING.

THIS DRAWING IS AN INSTRUMENT OF SERVICE OWNED
BY CTE ENVIRONMENTAL, INC. WHICH SHALL BE DEEMED
THE AUTHOR AND WHICH SHALL RETAIN ALL STATUTORY
AND COMMON LAW RIGHTS, INCLUDING COPYRIGHTS.
THIS DRAWING SHALL NOT BE SCANNED, COPIED, OR
DISTRIBUTED TO OTHERS IN ANY FORM OR USED FOR
ANY OTHER PURPOSE OR PROJECT WITHOUT PRIOR
WRITTEN CONSENT OF CTE ENVIRONMENTAL, INC.
CTE ENVIRONMENTAL, INC. CANNOT GUARANTEE THAT
ELECTRONIC COPIES OF THIS DRAWING ARE EXACT
DUPLICATES OF THE SEALED ORIGINAL DRAWING.
IN THE EVENT OF A CONFLICT BETWEEN AN ELECTRONIC
COPY AND THE SEALED ORIGINAL, THE SEALED ORIGINAL
SHALL GOVERN.

REVISIONS					
NO.	DESCRIPTIONS	DATE	BY	APP'D	
1	RECORD DRAWING	5/05	MGW	WAD	

ENVIRONMENTAL, INC.
ENGINEERS IN WATER AND EARTH SCIENCES
UNIONTOWN, OHIO

CITY OF MASSILLON, OHIO
WWTP UPGRADE 2000
DIGESTER CONTROL BUILDING
LOWER PLAN AND SECTION -DEMOLITION

DWG NO.	E9031
DATE	08/13/01
SCALE	AS NOTED
SHEET	P116