
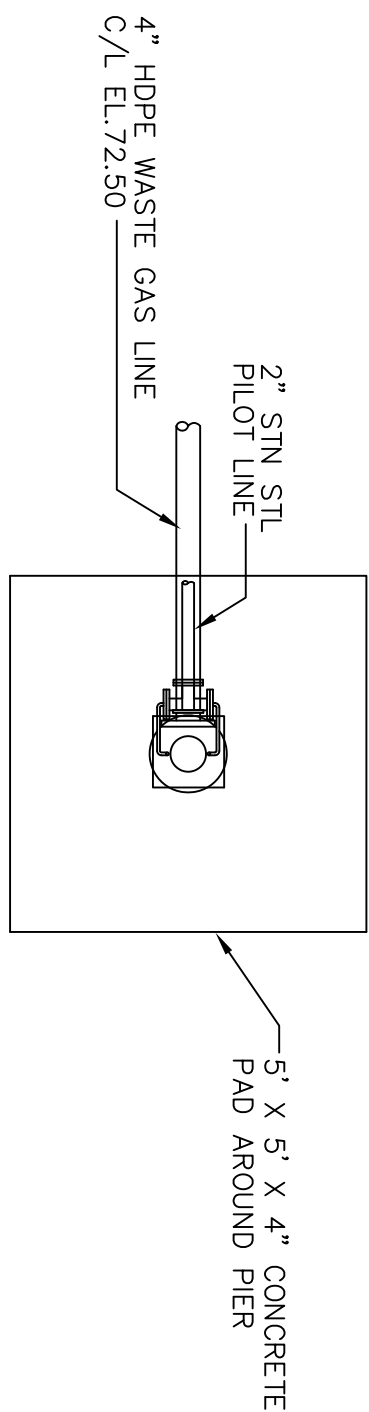
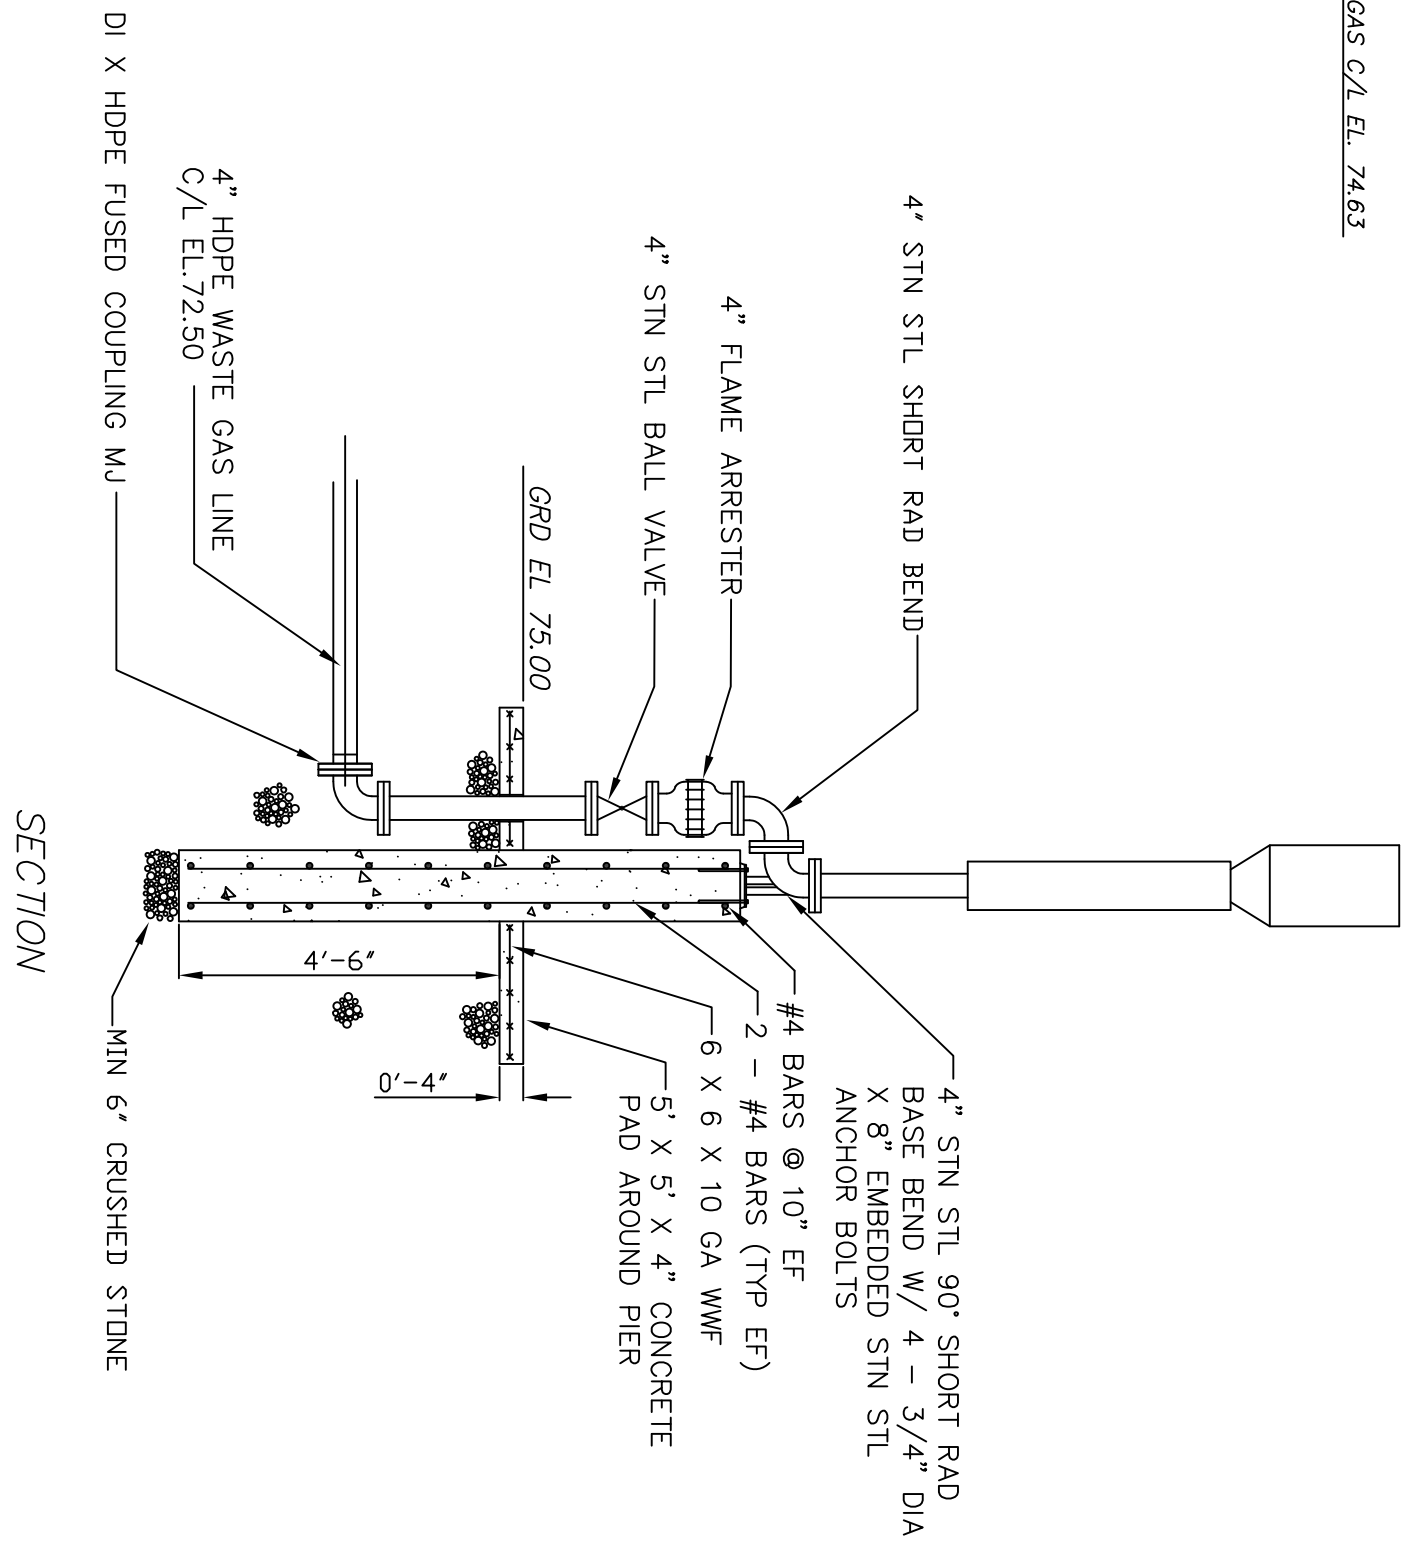
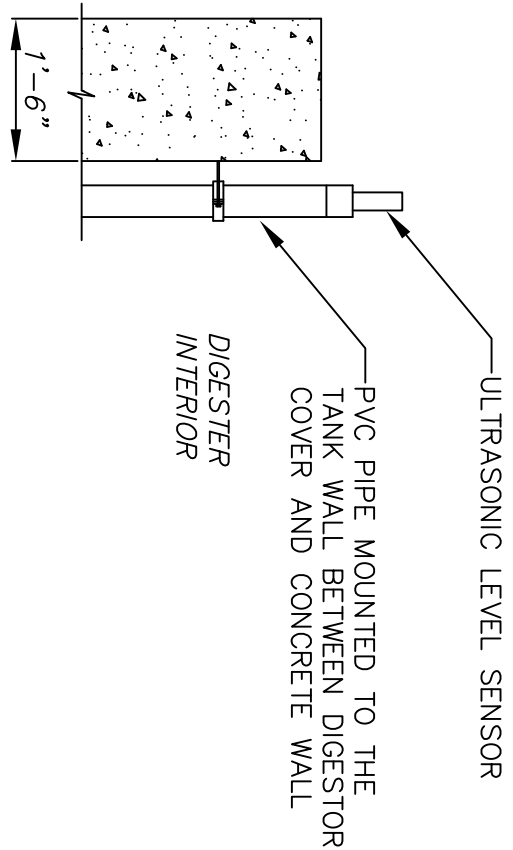
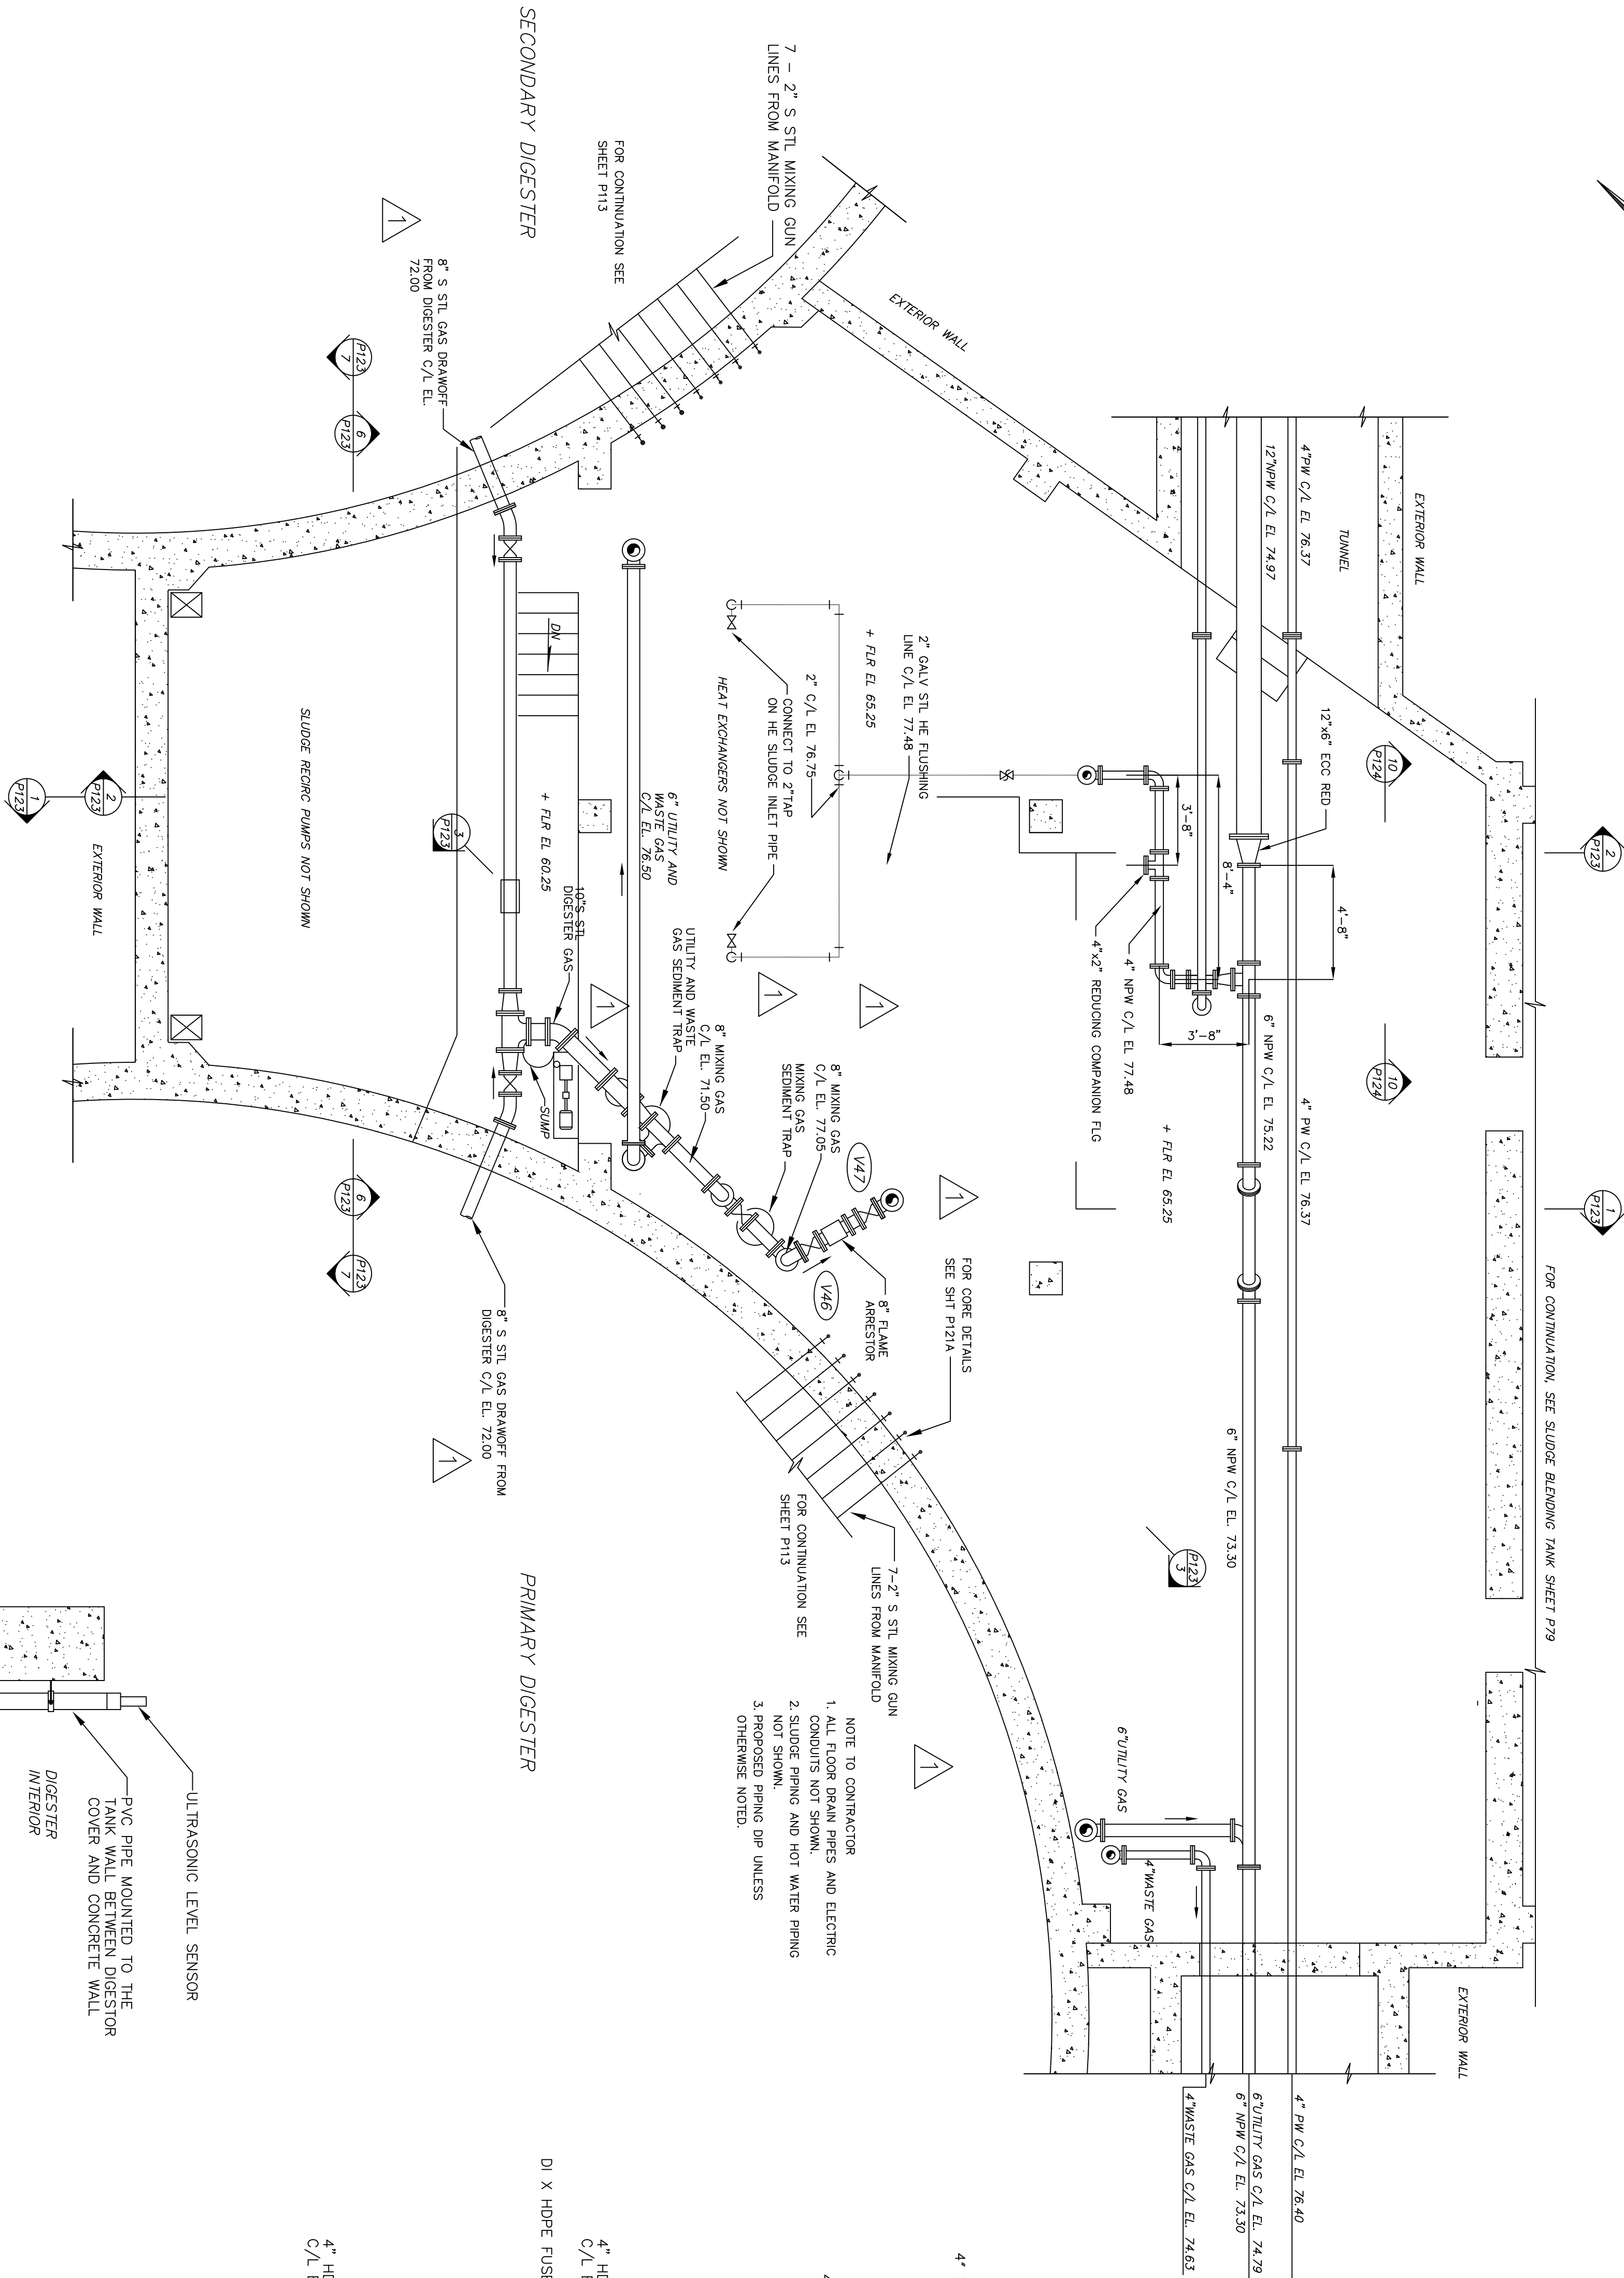


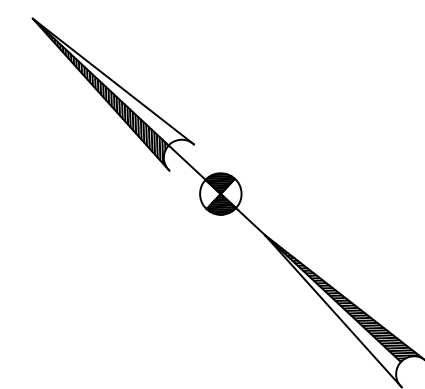

WASTE GAS BURNER

SCALE: 3/8"=1'-0"

PLAN

DIGESTER CONTROL BLDG
GAS AND WATER PIPING PLAN
BELOW EL. 77.50

SCALE: 1/4"=1'-0"

DIGESTER LEVEL CONTROL DETAIL

SCALE: 1/2" = 1'-0"



ENVIRONMENTAL, INC.
ENGINEERS IN WATER AND EARTH SCIENCES
UNIONTOWN, OHIO

CITY OF MASSILLON, OHIO
WWTP UPGRADE 2000
DIGESTER CONTROL BUILDING LOWER PLAN AND DETAILS

DESIGNED BY PMK/AJP	REVISIONS				
	NO.	DESCRIPTIONS	DATE	BY	APP'D
DRAWN BY AJP	1	REVISIONS	9/6/02	RWR	WAD
	2	RECORD DRAWING	3/17/05	MGW	WAD
CHECKED BY RWR					
APPROVED BY WAD					

THIS DRAWING IS AN INSTRUMENT OF SERVICE OWNED BY CTI ENVIRONMENTAL, INC. WHICH SHALL BE DEEMED THE AUTHOR AND WHICH SHALL RETAIN ALL STATUTORY AND COMMON LAW RIGHTS, INCLUDING COPYRIGHTS. THIS DRAWING SHALL NOT BE SCANNED, COPIED, OR DISTRIBUTED TO OTHERS IN ANY FORM OR USED FOR ANY OTHER PURPOSE OR PROJECT WITHOUT PRIOR WRITTEN CONSENT OF CTI ENVIRONMENTAL, INC. CTI ENVIRONMENTAL, INC. CANNOT GUARANTEE THAT ELECTRONIC COPIES OF THIS DRAWING ARE EXACT DUPLICATES OF THE SEALED ORIGINAL DRAWING. IN THE EVENT OF A CONFLICT BETWEEN AN ELECTRONIC COPY AND THE SEALED ORIGINAL, THE SEALED ORIGINAL SHALL GOVERN.

THESE RECORD DOCUMENTS HAVE BEEN PREPARED BASED ON INFORMATION PROVIDED BY OTHERS. CTI ENVIRONMENTAL HAS REVIEWED THE INFORMATION SUBMITTED AND BELIEVES IT REFLECTS THE WORK AS CONSTRUCTED. HOWEVER, ALL PERSONS SHALL VERIFY INFORMATION TAKEN FROM THIS DRAWING.

JOB NO. E9031
DATE 8/20/02
SCALE AS NOTED
SHEET P121