
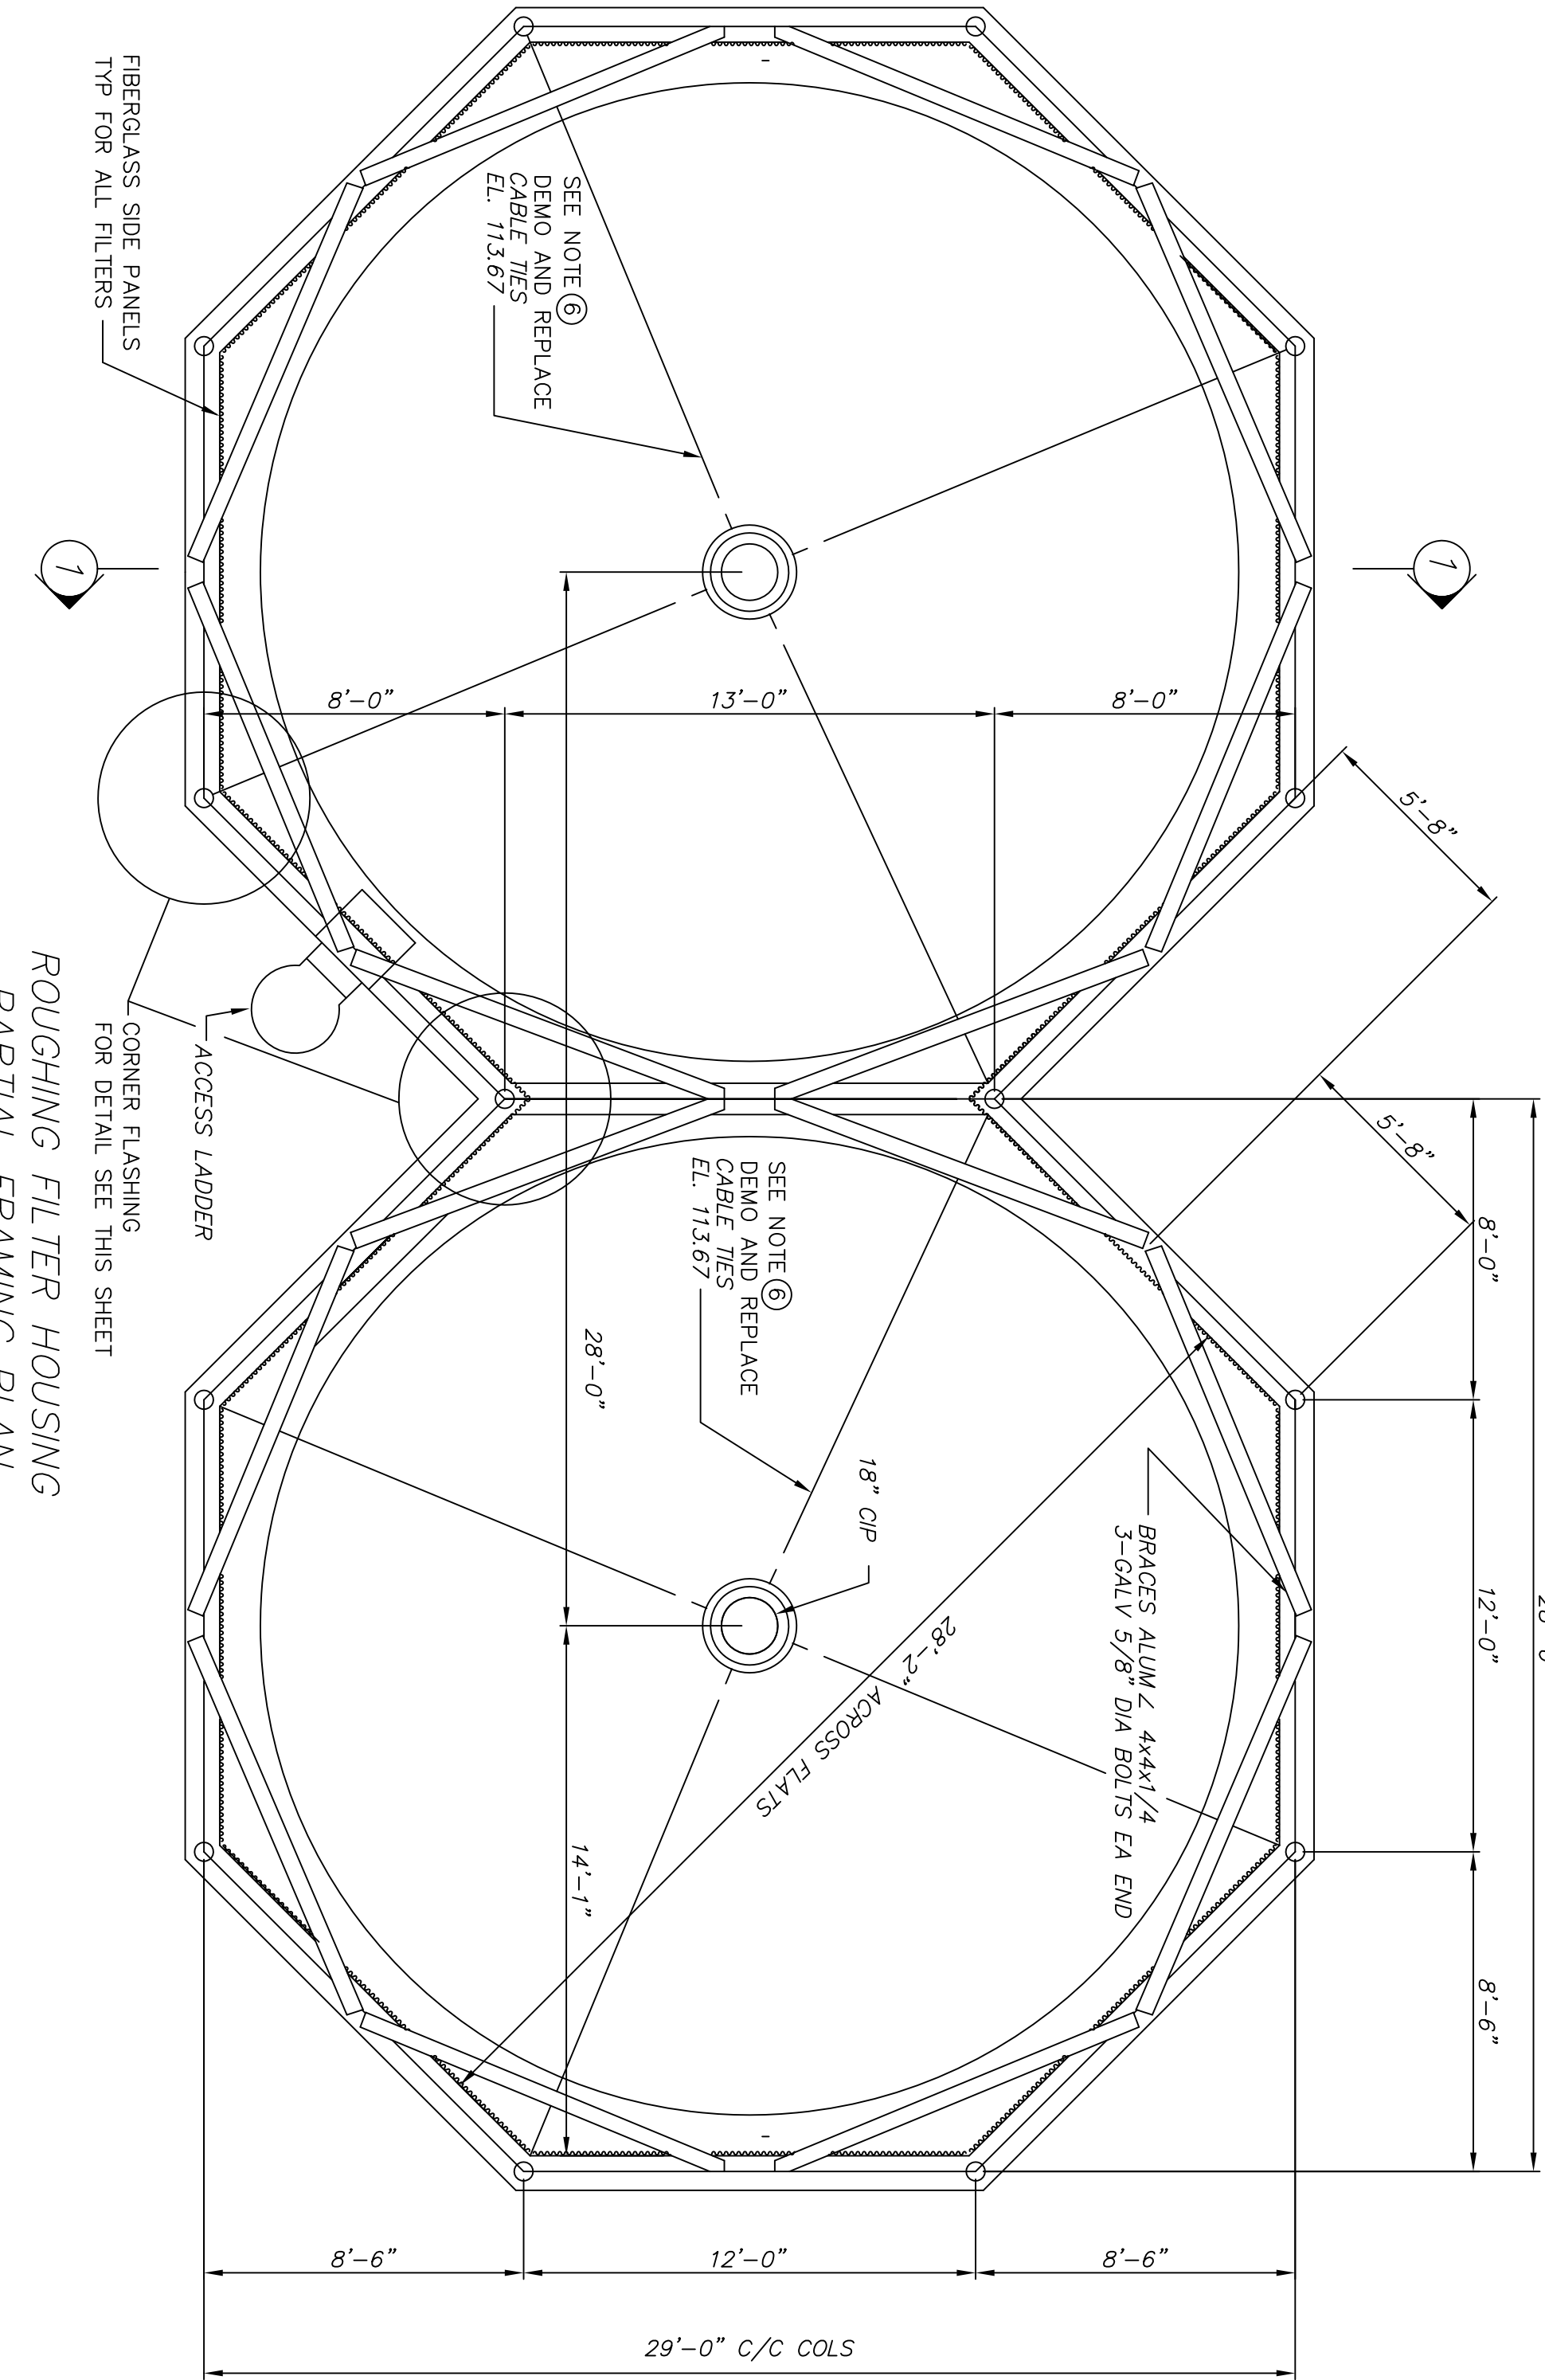


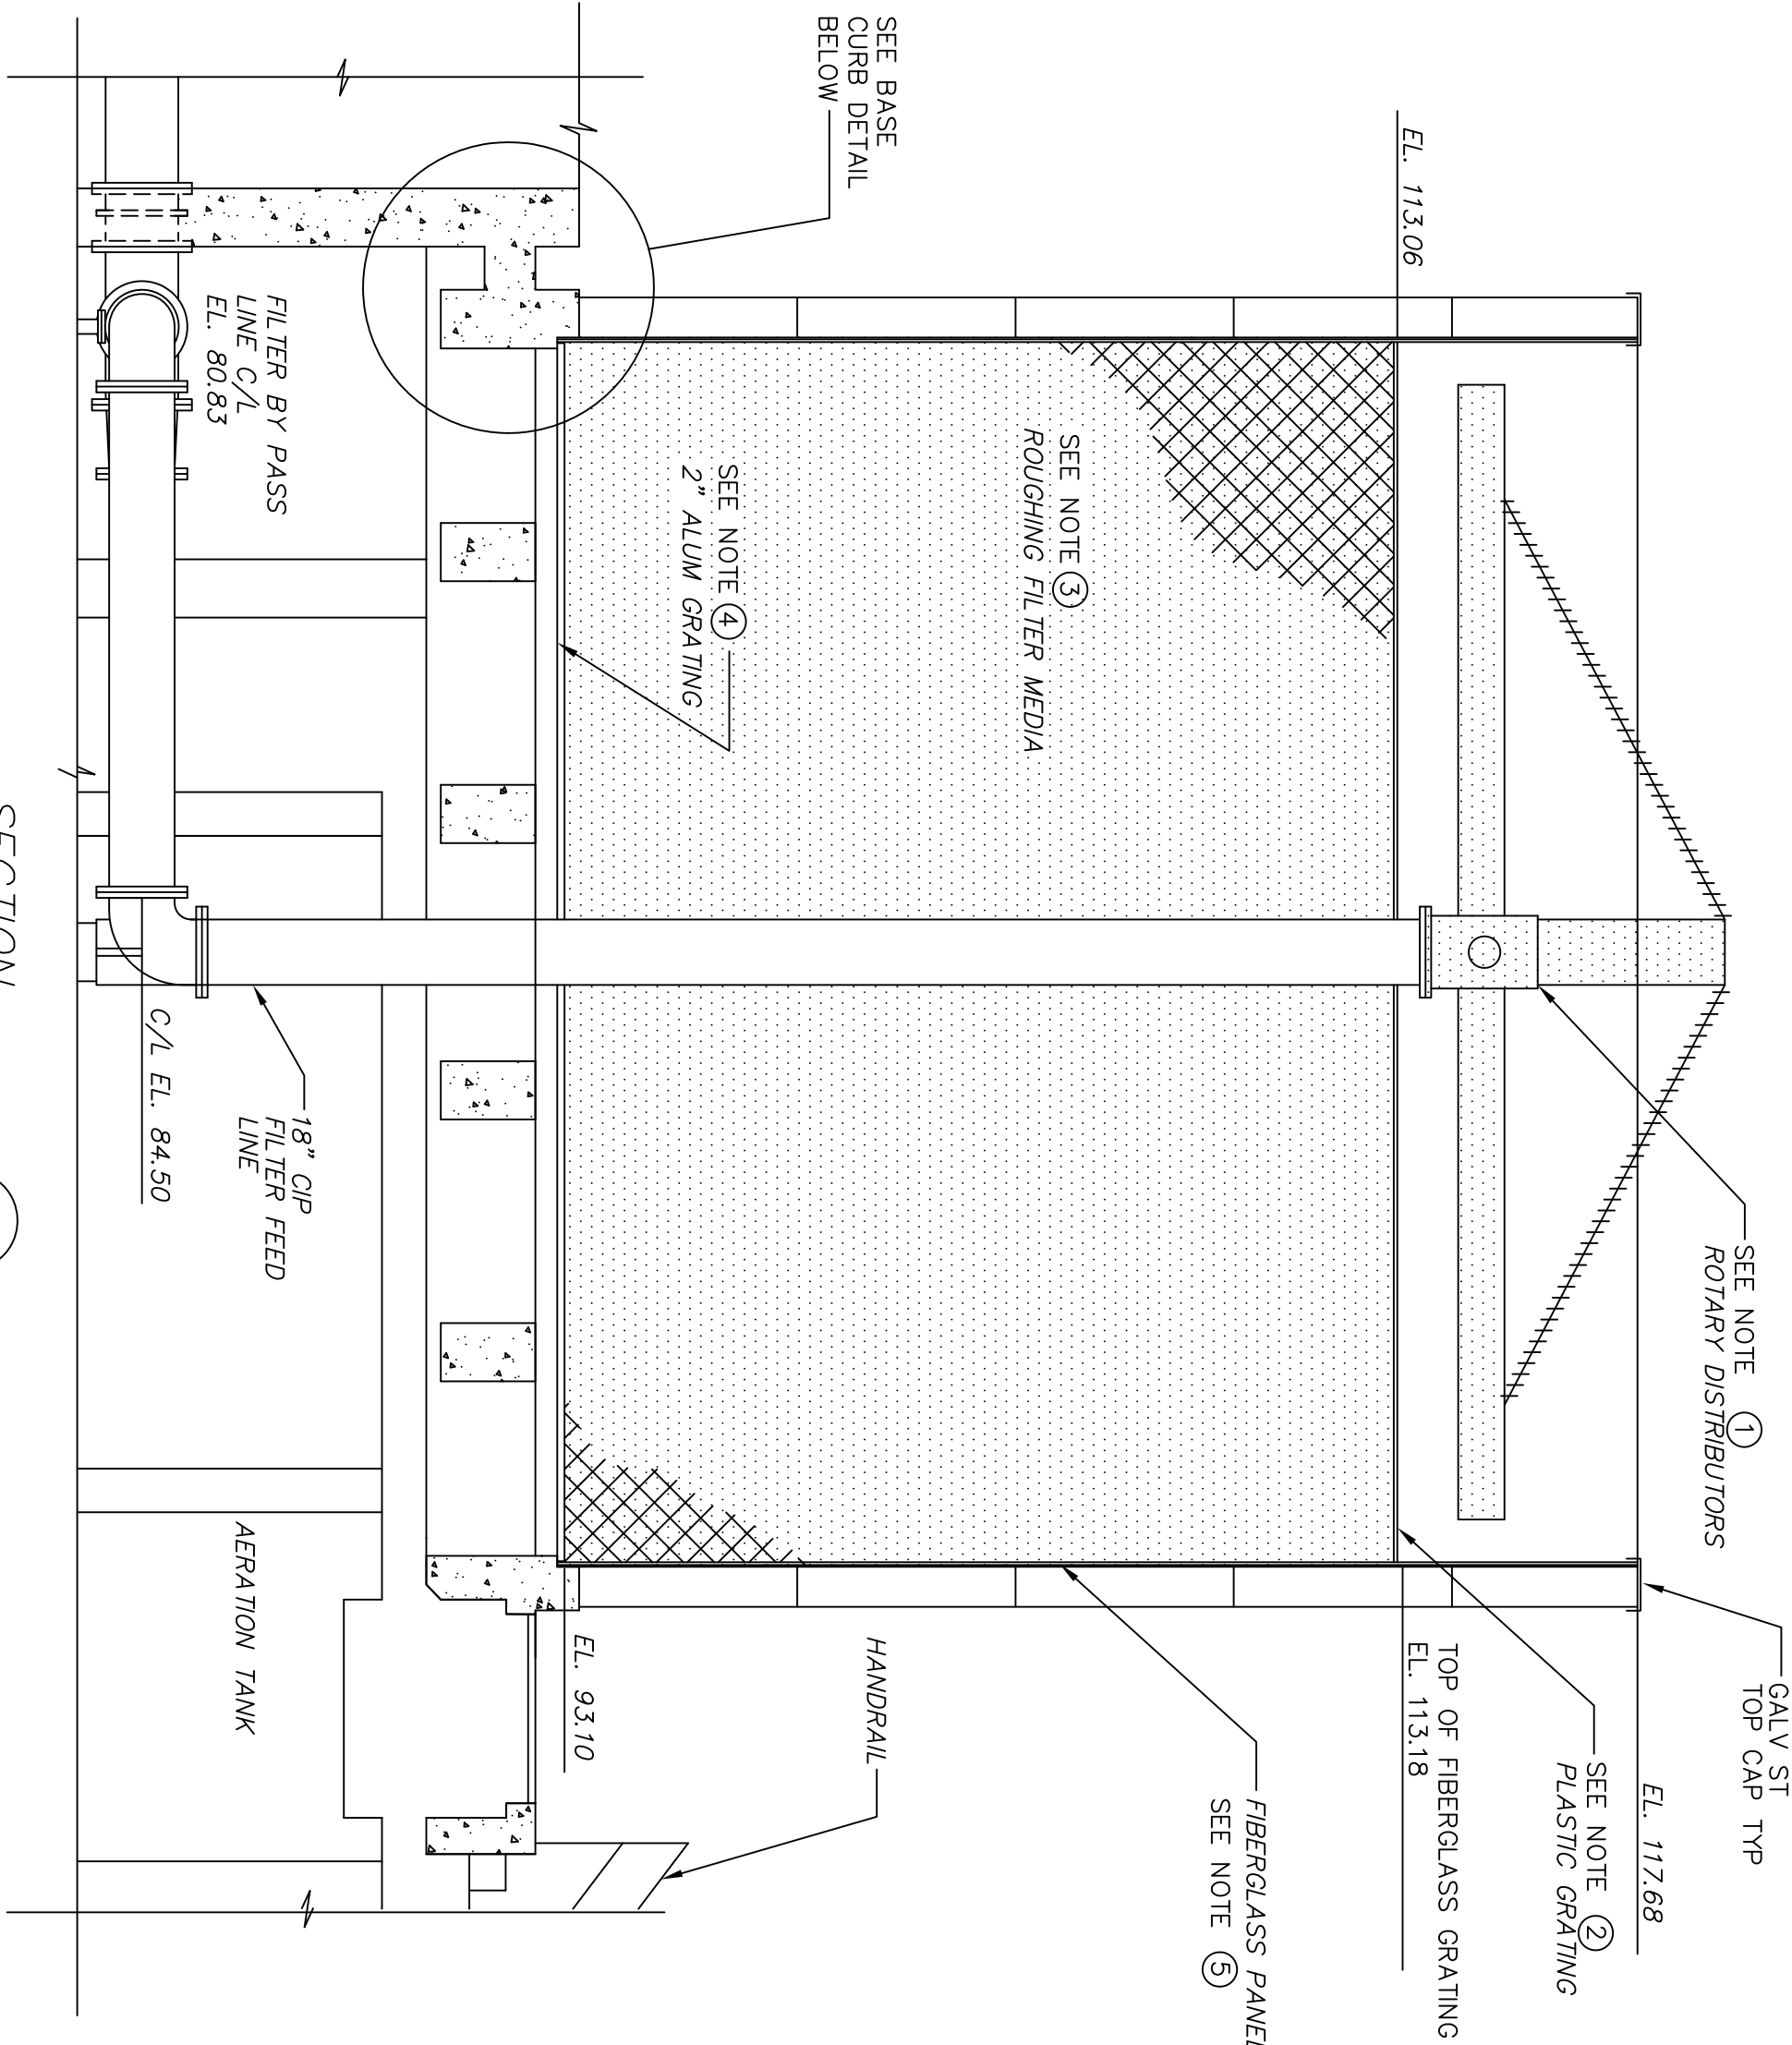


SECTION 1
SCALE: 1/4"=1'-0"

FRP OR S STL CORNER FLASHING

FIBERGLASS SIDE PANELS
TYP FOR ALL FILTERS



CORNER FLASHING
FOR DETAIL SEE THIS SHEET

ROUGHING FILTER HOUSING
PARTIAL FRAMING PLAN
SCALE: 1/4"=1'-0"

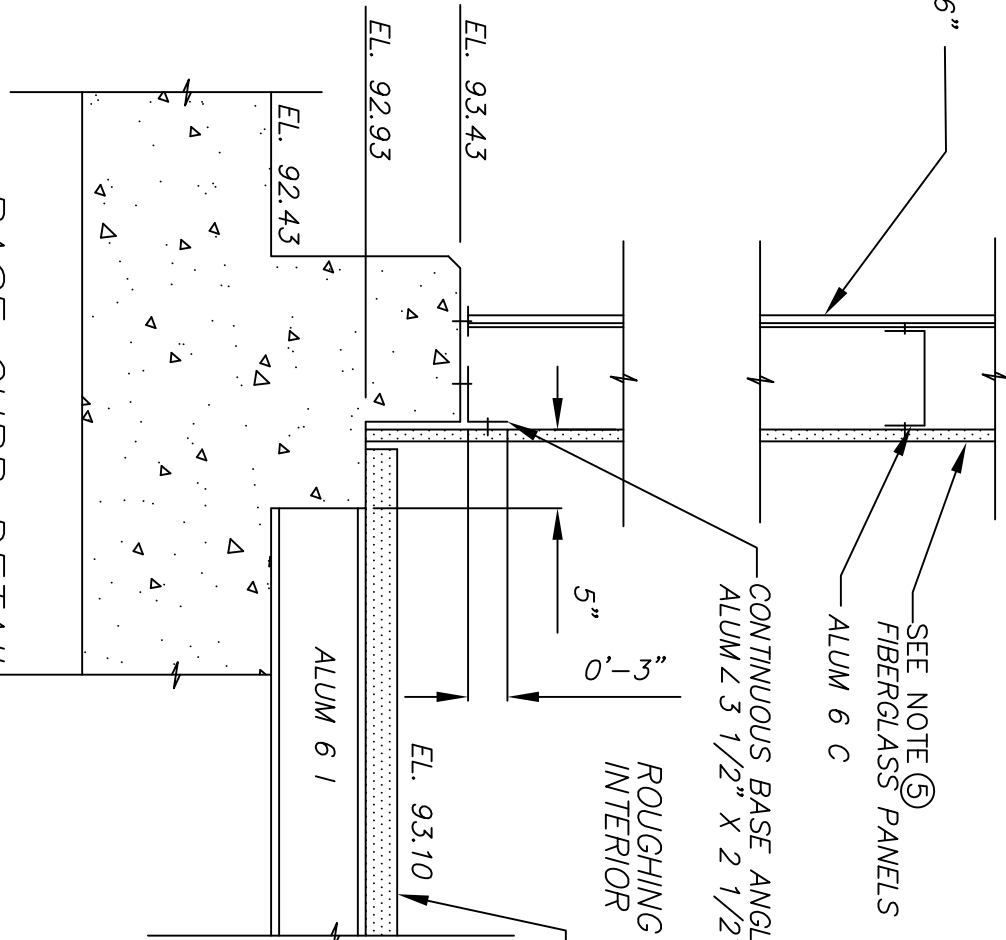


BASE CURB DETAIL
SCALE: 1"=1'-0"


CORNER FLASHING DETAILS
TYP ALL CORNERS
SCALE 1 1/2" = 1'-0"

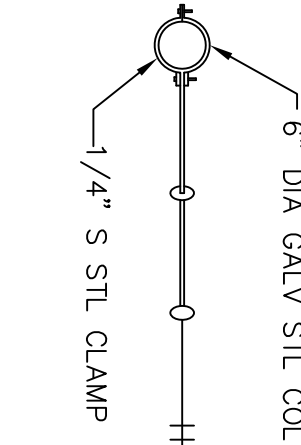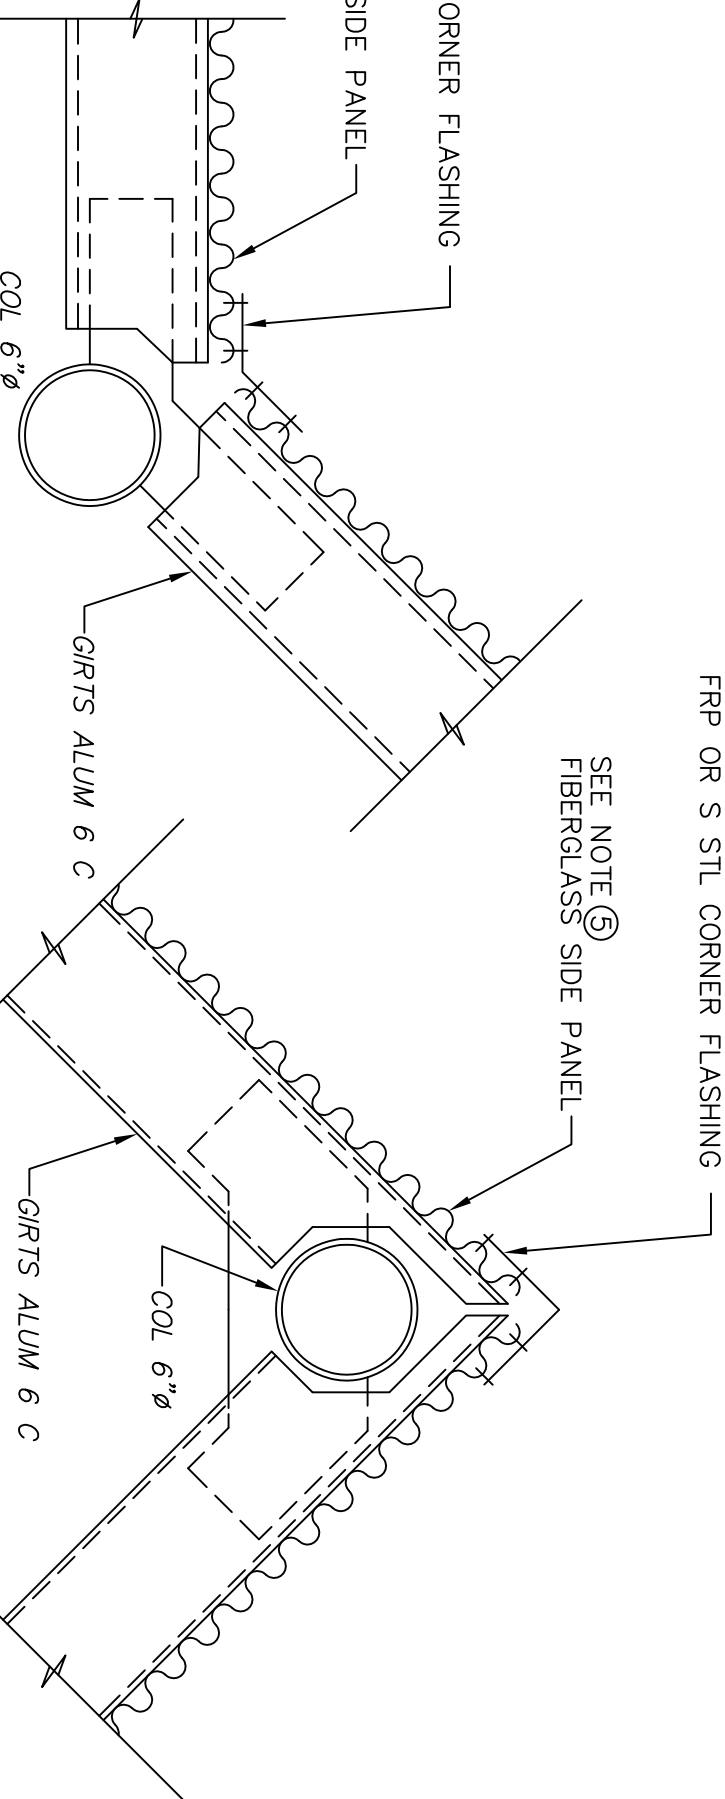


PLAN

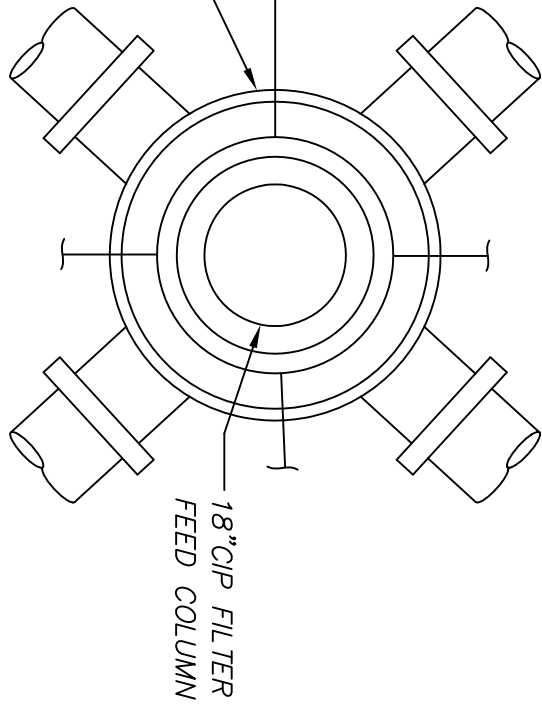


CENTER WELL AND
CENTER DRIVE ASSEMBLY

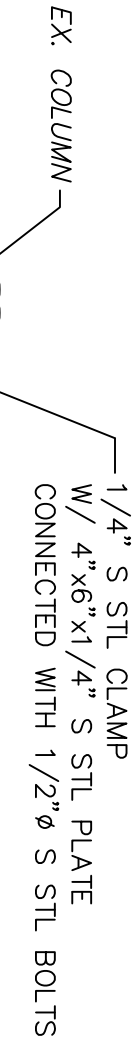

EX COLUMN

 


CABLE TIE DETAIL
NO SCALE

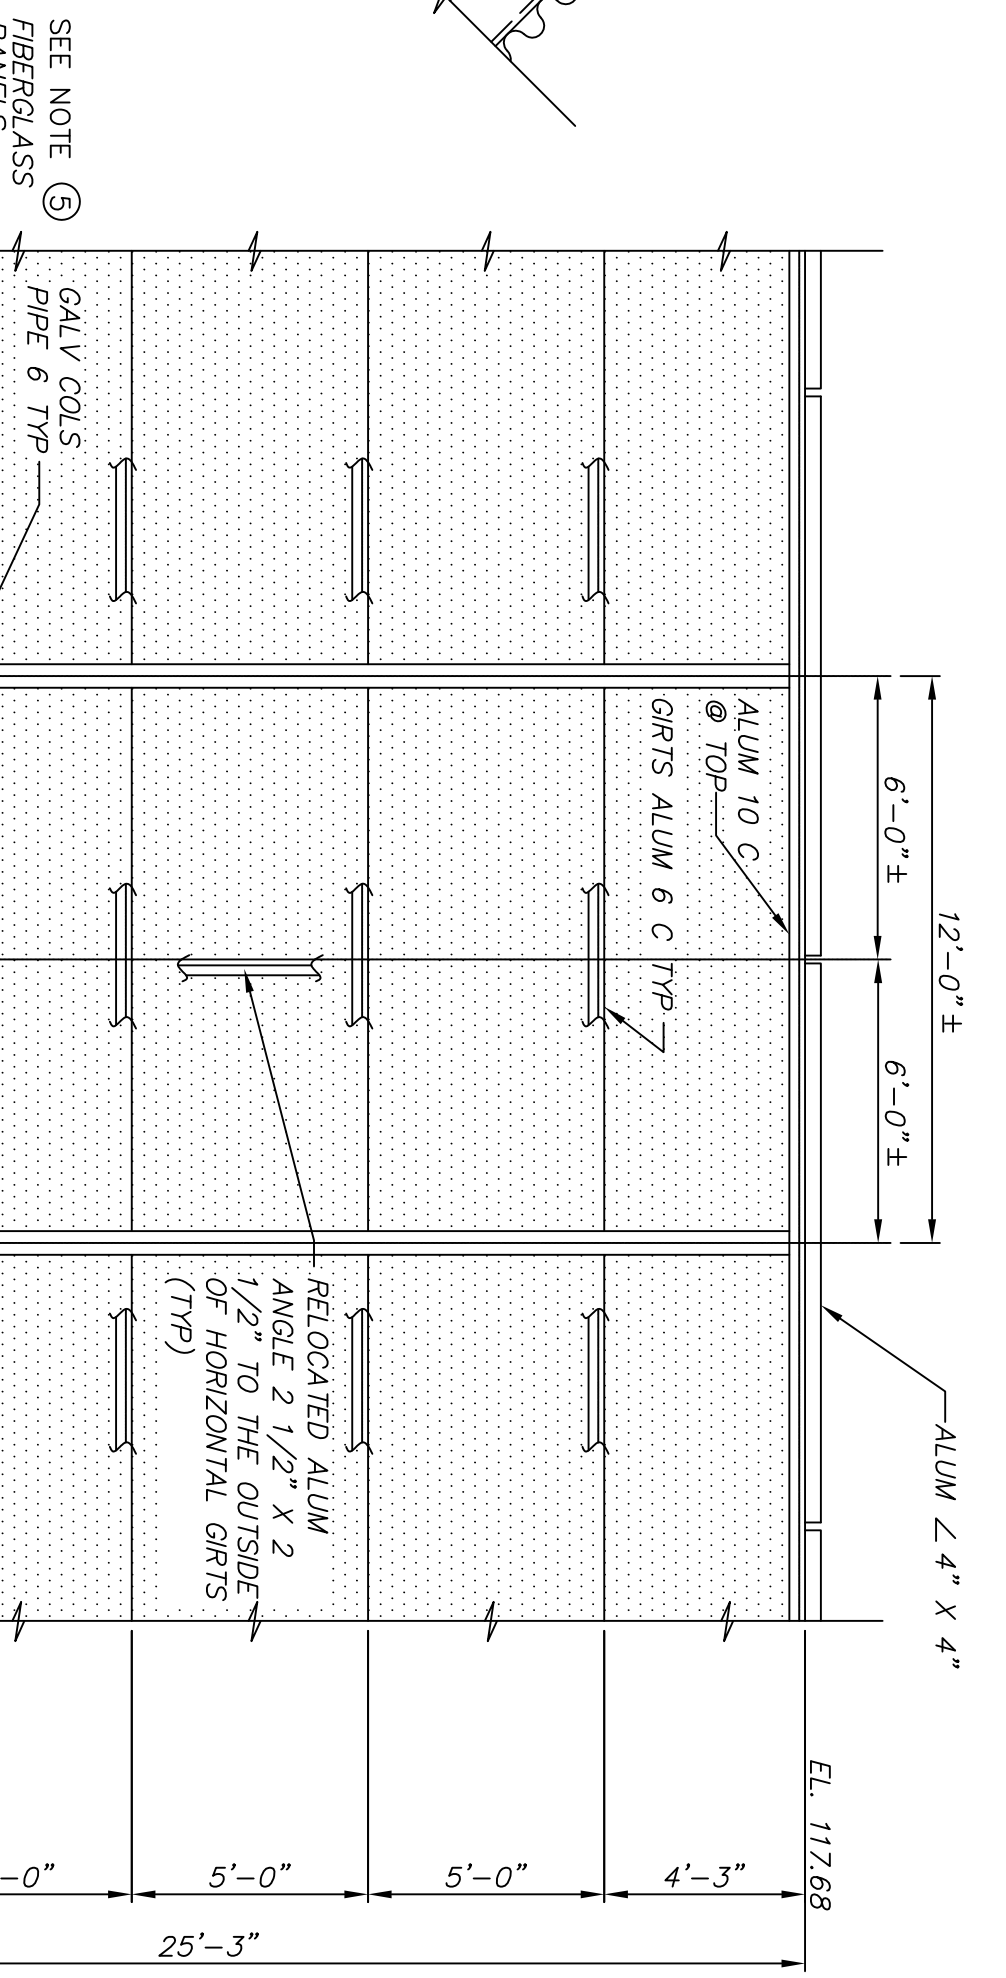

PARTIAL ELEVATION
SCALE 1/4" = 1'-0"

NOTES:

 1. ITEMS FOR DEMOLITION



NOTES TO CONTRACTOR

- CONTRACTOR SHALL REMOVE SIX (6) EXISTING ROTARY DISTRIBUTORS AND REPLACE IN ACCORDANCE WITH SECTION 11367.
- CONTRACTOR SHALL REMOVE EXISTING PLASTIC GRATING FROM SIX (6) ROUGHING FILTERS AND REPLACE WITH 1" FIBERGLASS GRATING IN ACCORDANCE WITH SECTION 06510.
- CONTRACTOR SHALL REMOVE EXISTING PVC STACKED MEDIA FROM SIX (6) ROUGHING FILTERS AND REPLACE IN ACCORDANCE WITH SECTION 11366.
- CONTRACTOR SHALL REMOVE EXISTING 2" ALUM. GRATING FROM SIX (6) ROUGHING FILTERS AND REPLACE IN KIND IN ACCORDANCE WITH SECTION 05500.
- CONTRACTOR SHALL REMOVE EXISTING FIBERGLASS PANELS FROM SIX (6) ROUGHING FILTERS AND REPLACE IN KIND IN ACCORDANCE WITH SECTION 07411.
- CONTRACTOR SHALL REMOVE EXISTING CABLE TIES AND ACCESSORIES FROM SIX (6) ROUGHING FILTERS AND REPLACE. SEE PROPOSED CABLE TIE DETAILS ON THIS SHEET.
- SEQUENCE OF CONSTRUCTION SHALL BE IN ACCORDANCE WITH SECTION 02050.
- CONTRACTOR TO COORDINATE THE ATTACHMENT OF THE CABLE TIE TO THE ROTARY DISTRIBUTOR BASE WITH THE ROTARY DISTRIBUTOR MANUFACTURER. ADJUST TIES TO SNUG CONDITION ONLY.
- CONTRACTOR SHALL REMOVE EXISTING 4"x3"x1/4" S STL PLATE AND REPAIR THE WELD WITH COLD GALVANIZING COMPOUND.
- CONTRACTOR SHALL SEAL THE GAPS BETWEEN THE PROPOSED 4"x6"x1/4" S STL PLATES AND FIBERGLASS PANELS WITH CAULKING.



ENVIRONMENTAL, INC.
ENGINEERS IN WATER AND EARTH SCIENCES
UNIONTOWN, OHIO

CITY OF MASSILLON, OHIO
WWTP UPGRADE 2000
ROUGHING FILTER PLAN, SECTION AND DETAILS

DESIGNED BY	PMK
DRAWN BY	SAT/AJP
CHECKED BY	RWR
APPROVED BY	WAD

REVISIONS				
NO.	DESCRIPTIONS	DATE	BY	APP'D
1	ADDENDUM NO. 1	9/14	RWR	WAD
2	RECORD DRAWING	4/05	MGW	WAD

THIS DRAWING IS AN INSTRUMENT OF SERVICE OWNED BY CTI ENVIRONMENTAL, INC. WHICH SHALL BE DEEMED THE AUTHOR AND WHICH SHALL RETAIN ALL STATUTORY AND COMMON LAW RIGHTS, INCLUDING COPYRIGHT. THIS DRAWING SHALL NOT BE SCANNED, COPIED, OR DISTRIBUTED TO OTHERS IN ANY FORM OR USED FOR ANY OTHER PURPOSE OR PROJECT WITHOUT PRIOR WRITTEN CONSENT OF CTI ENVIRONMENTAL, INC. CTI ENVIRONMENTAL, INC. CANNOT GUARANTEE THAT ELECTRONIC COPIES OF THIS DRAWING ARE EXACT DUPLICATES OF THE SEALED ORIGINAL DRAWING. IN THE EVENT OF A CONFLICT BETWEEN AN ELECTRONIC COPY AND THE SEALED ORIGINAL, THE SEALED ORIGINAL SHALL GOVERN.

JOB NO.	E9031
DATE	08/13/01
SCALE	AS NOTED
SHEET	P339

KEY PLAN

