



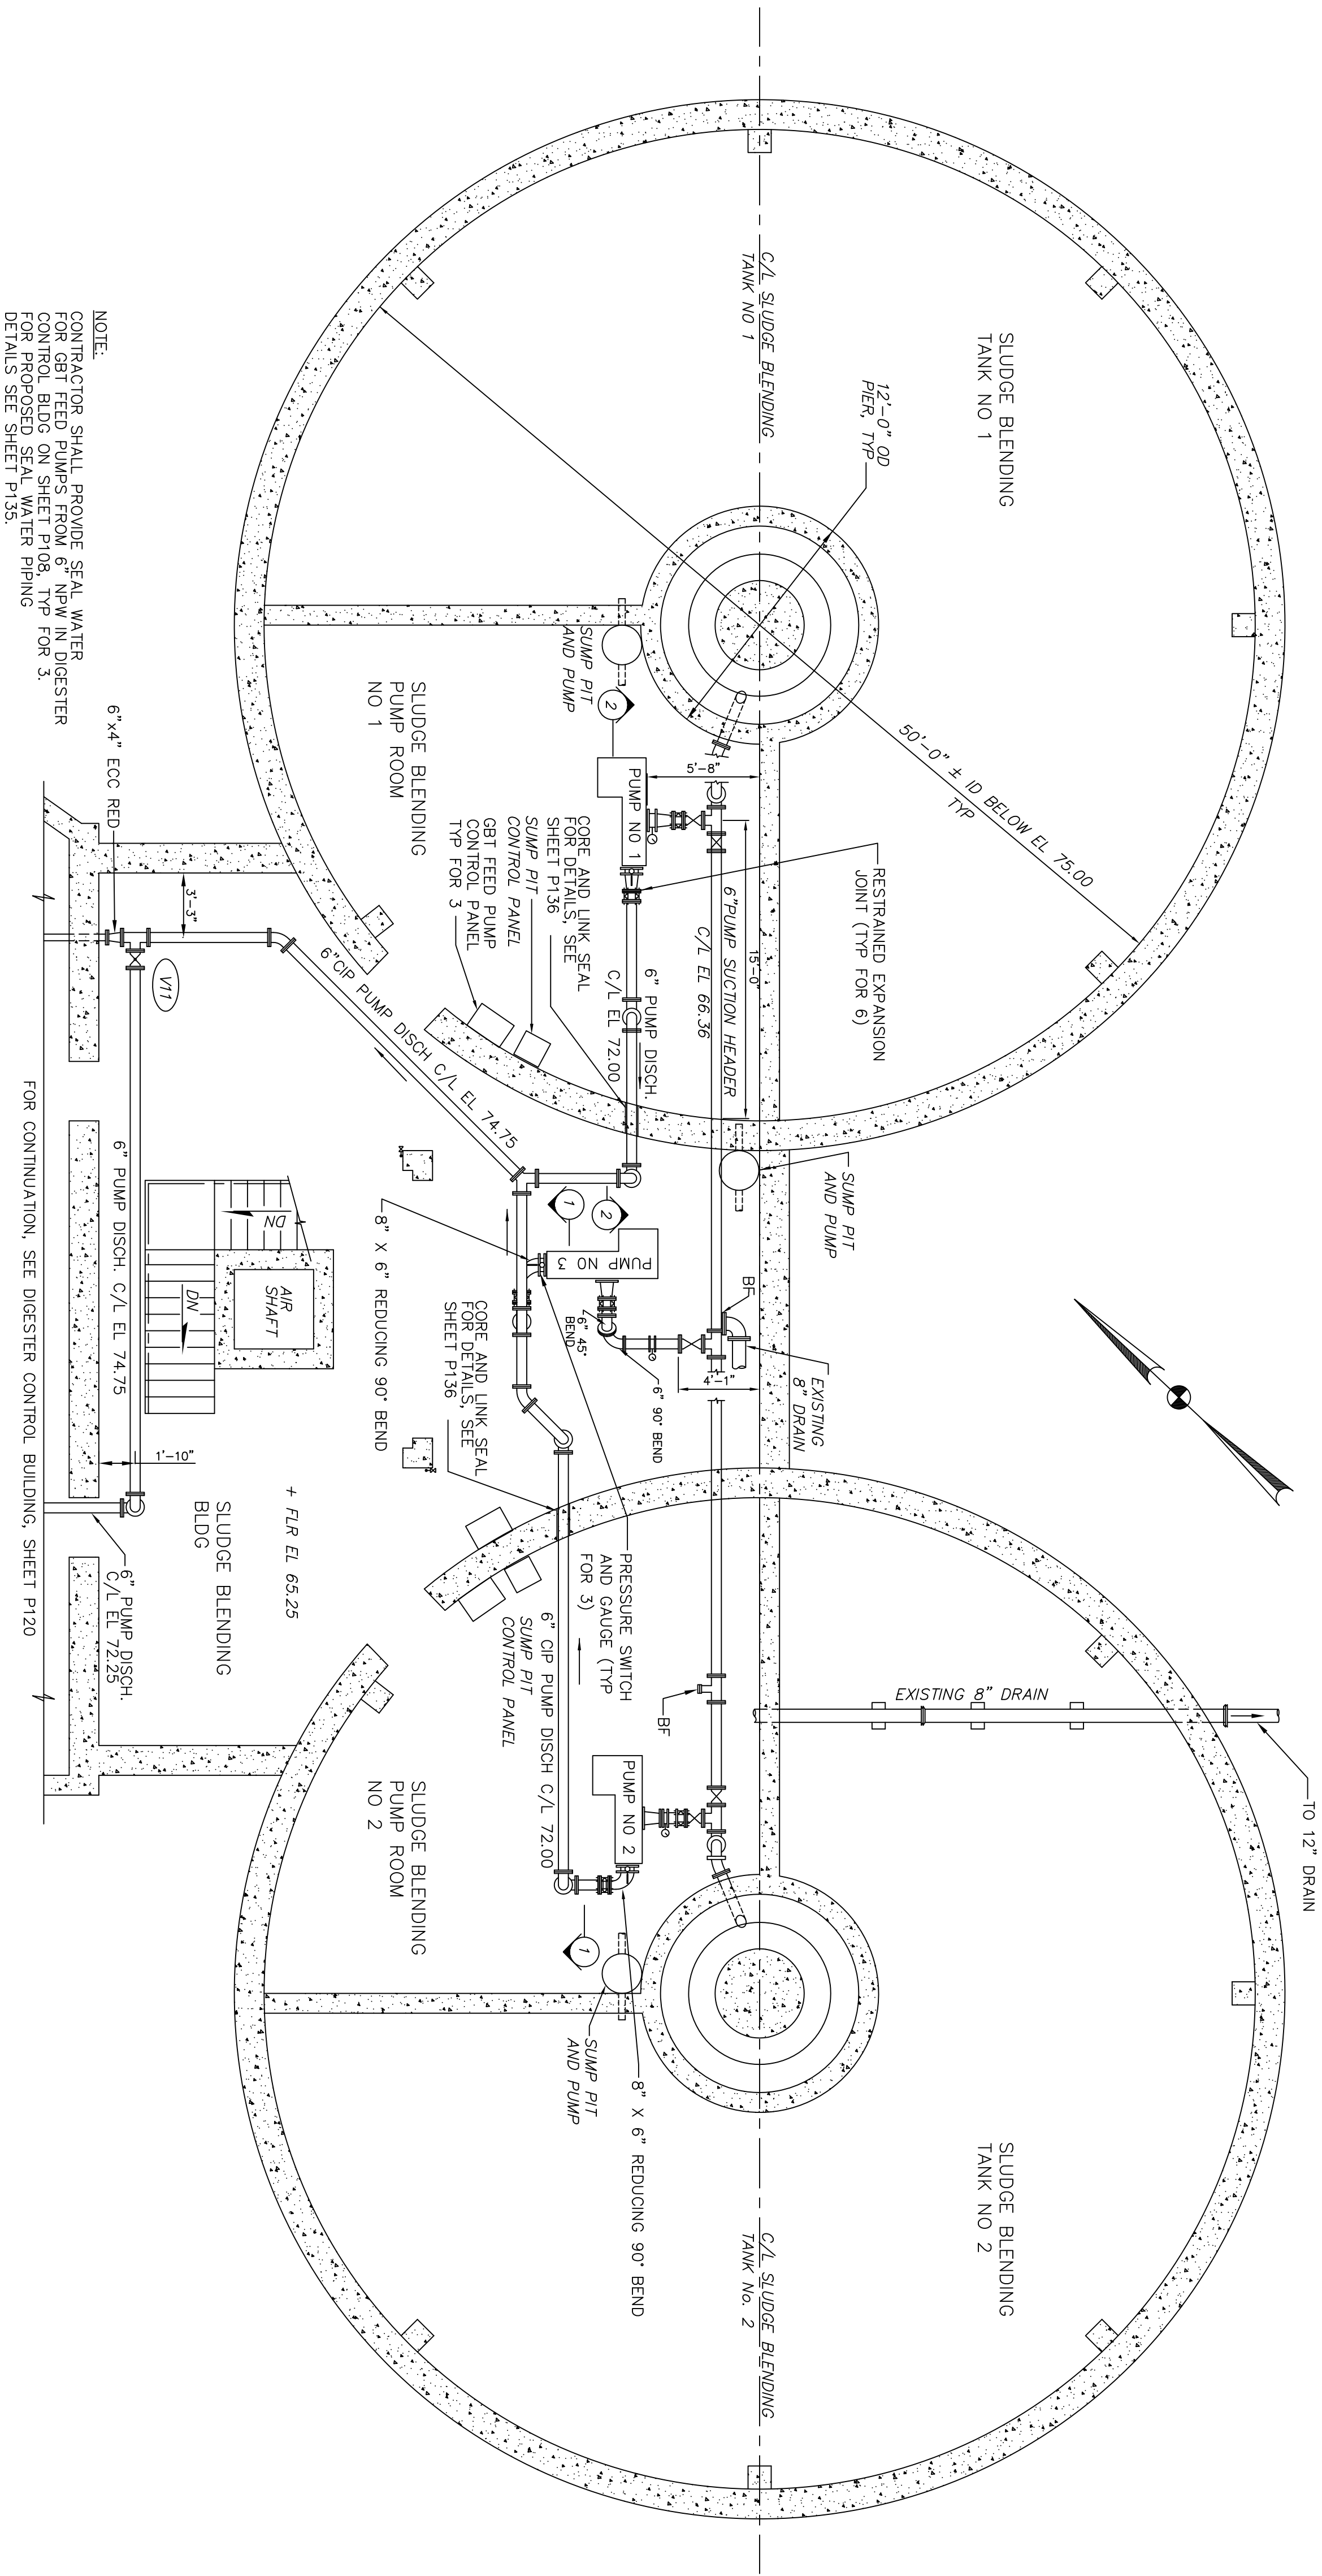


NOTE:
CONTRACTOR SHALL PROVIDE SEAL WATER
FOR GBT FEED PUMPS FROM 6" NFW IN DIGESTER
CONTROL BLDG ON SHEET P108, TYP FOR 3.
FOR PROPOSED SEAL WATER PIPING
DETAILS SEE SHEET P135.

BASMENT PLAN
SCALE: 3/16" = 1'-0"

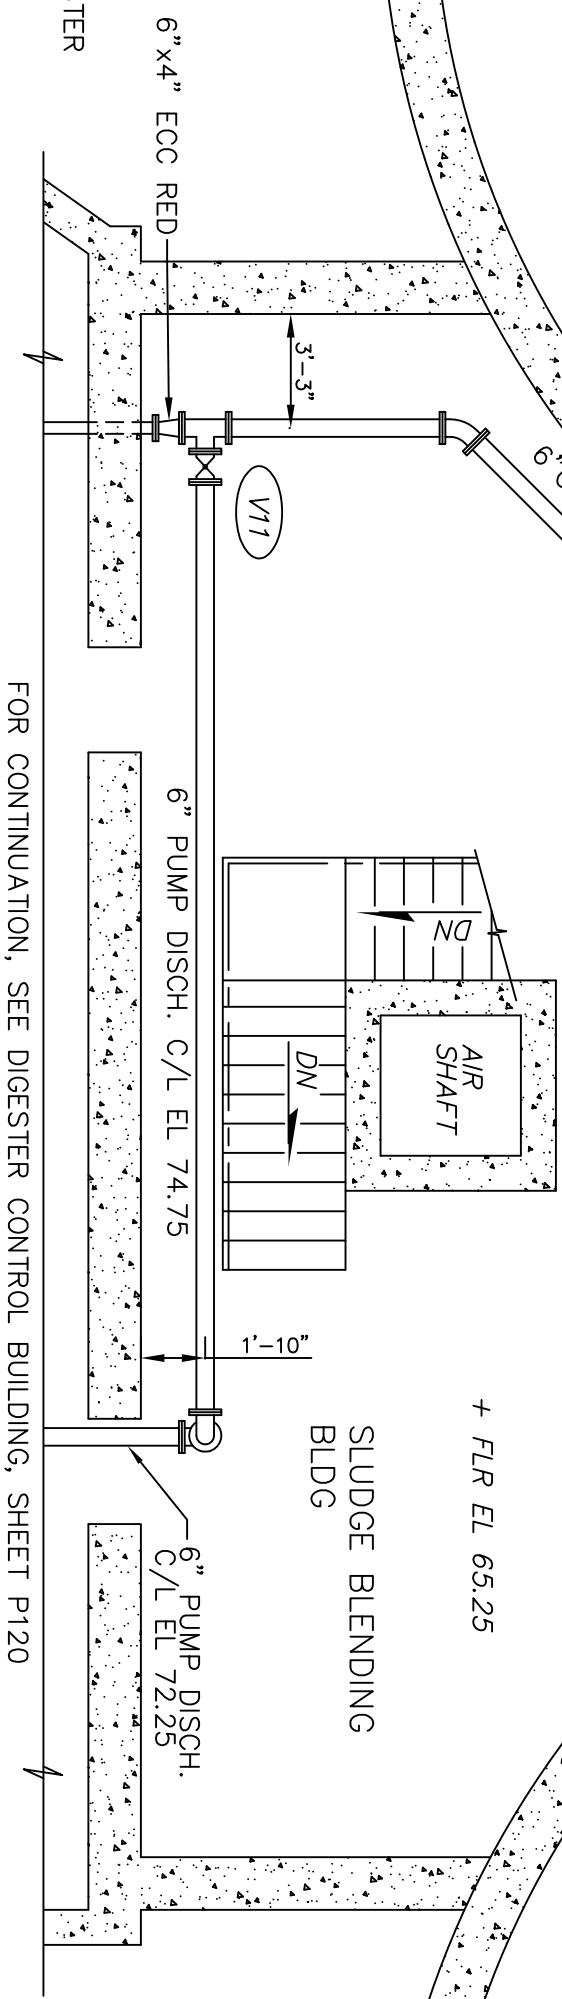


FOR CONTINUATION, SEE DIGESTER CONTROL BUILDING, SHEET P120

BASMENT PLAN
SCALE: 3/16" = 1'-0"

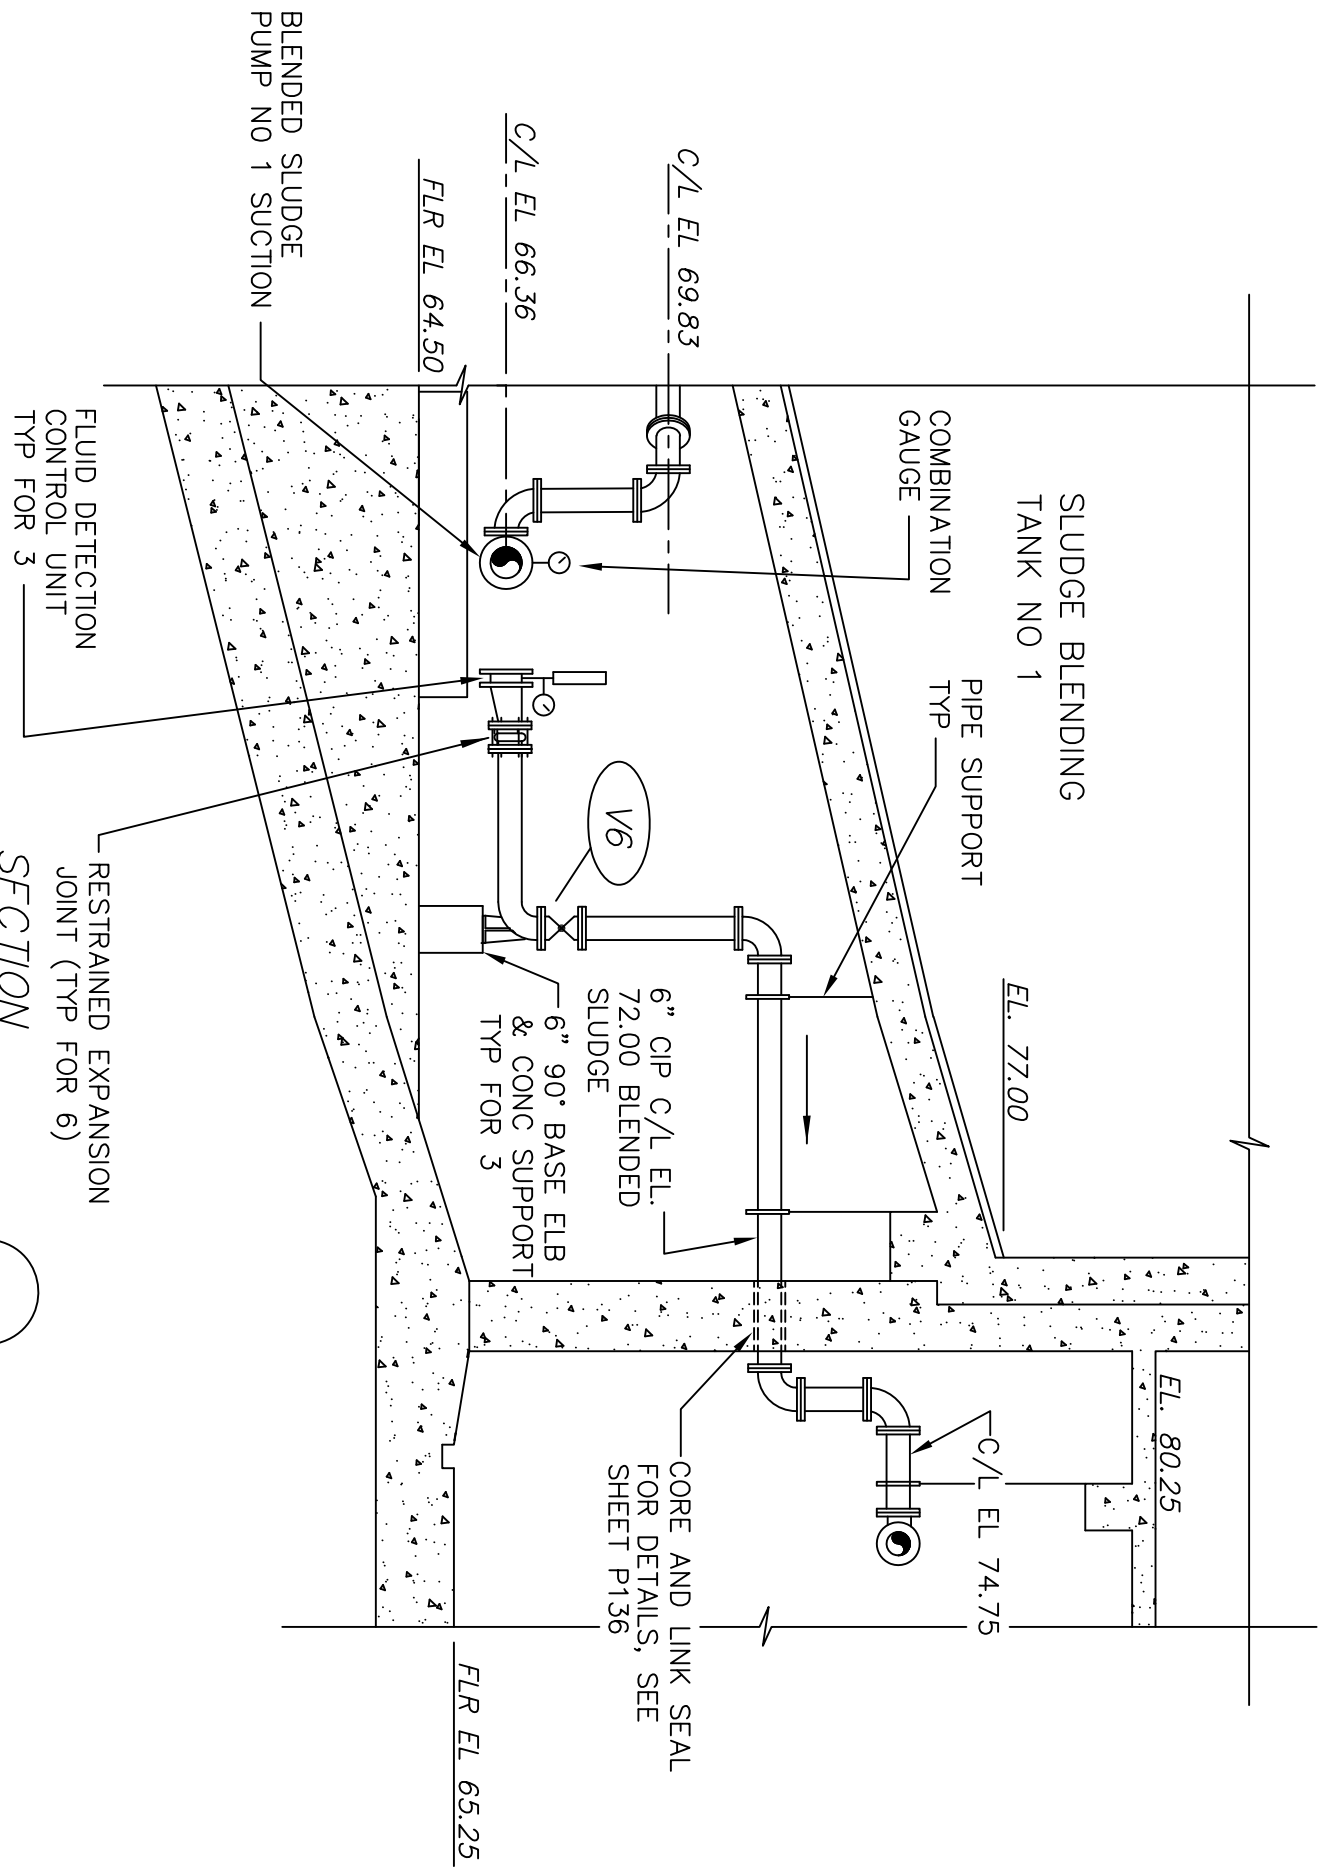

SECTION 1
SCALE: 1/4" = 1'-0"

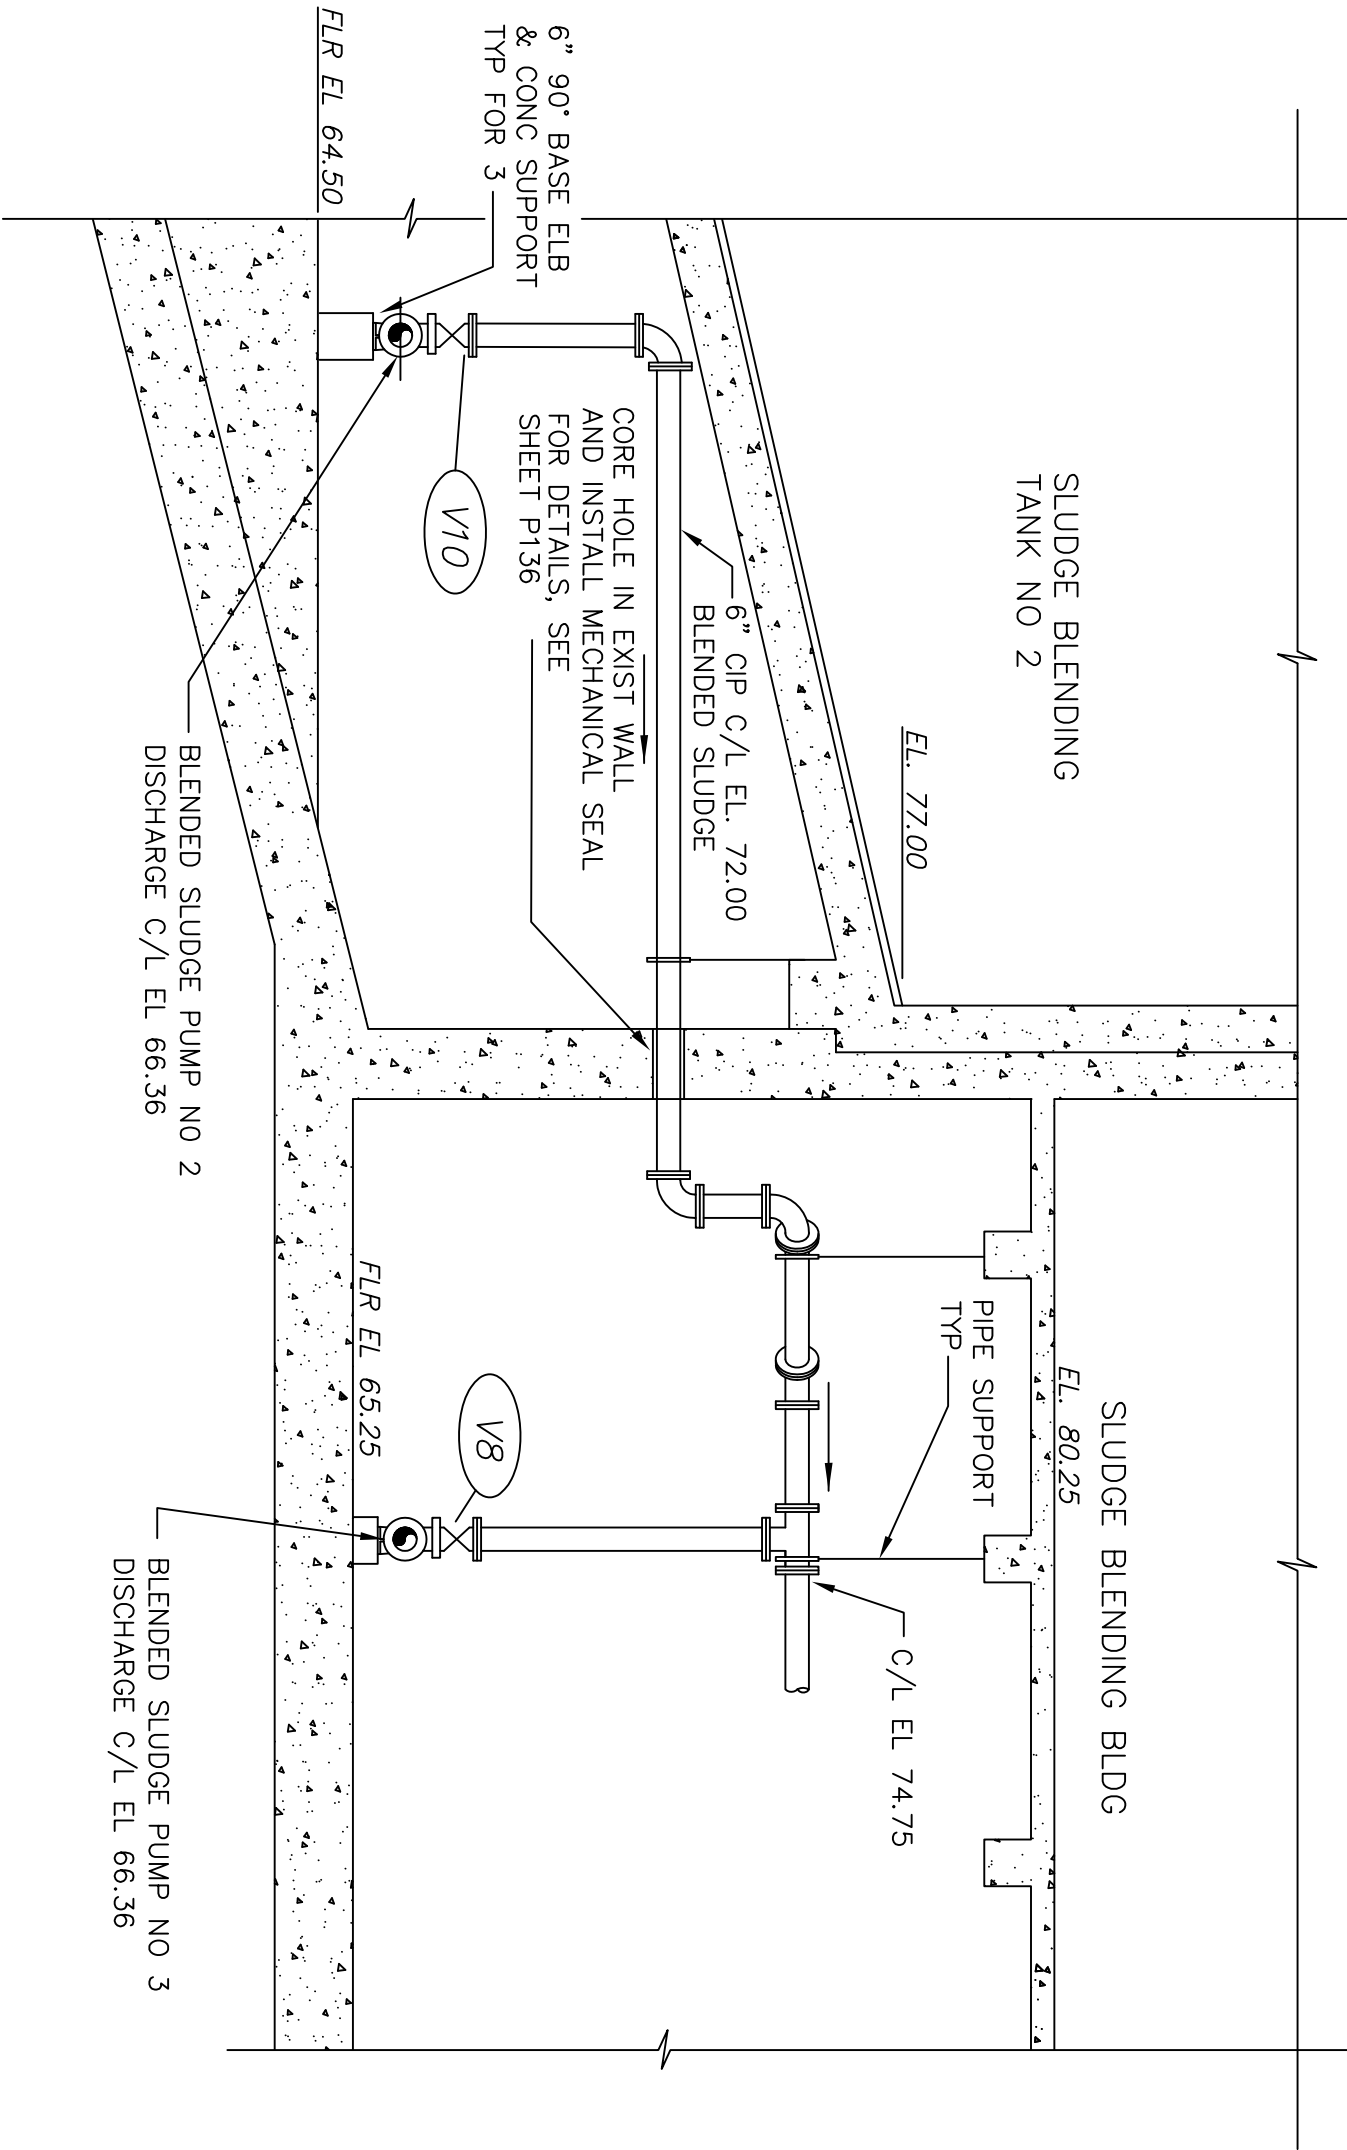

SECTION 2
SCALE: 1/4" = 1'-0"

THESE RECORD DOCUMENTS HAVE BEEN PREPARED
BASED ON INFORMATION PROVIDED BY OTHERS. CTE
ENVIRONMENTAL HAS REVIEWED THE INFORMATION
SUBMITTED AND BELIEVES IT REFLECTS THE WORK AS
CONSTRUCTED. HOWEVER, ALL PERSONS SHALL
VERIFY INFORMATION TAKEN FROM THIS DRAWING.



ENVIRONMENTAL, INC.
ENGINEERS IN WATER AND EARTH SCIENCES
UNIONTOWN, OHIO

CITY OF MASSILLON, OHIO
WWTP UPGRADE 2000
SLUDGE BLENDING TANK LOWER FLOOR PLAN AND SECTIONS

DESIGNED BY	REVISIONS				
	NO.	DESCRIPTIONS	DATE	BY	APP'D
PMK					
DRAWN BY	1	RECORD DRAWING	4/05	MGW	WAD
AJP					
CHECKED BY					
RWR					
APPROVED BY					
WAD					

THIS DRAWING IS AN INSTRUMENT OF SERVICE OWNED
BY CTE ENVIRONMENTAL, INC. WHICH SHALL BE DEEMED
THE AUTHOR AND WHICH SHALL RETAIN ALL STATUTORY
AND COMMON LAW RIGHTS, INCLUDING COPYRIGHTS.
THIS DRAWING SHALL NOT BE SCANNED, COPIED, OR
DISTRIBUTED TO OTHERS IN ANY FORM OR USED FOR
ANY OTHER PURPOSE OR PROJECT WITHOUT PRIOR
WRITTEN CONSENT OF CTE ENVIRONMENTAL, INC.
CTE ENVIRONMENTAL, INC. CANNOT GUARANTEE THAT
ELECTRONIC COPIES OF THIS DRAWING ARE EXACT
DUPLICATES OF THE SEALED ORIGINAL DRAWING.
IN THE EVENT OF A CONFLICT BETWEEN AN ELECTRONIC
COPY AND THE SEALED ORIGINAL, THE SEALED ORIGINAL
SHALL GOVERN.

JOB NO.	E9031
DATE	08/13/01
SCALE	AS NOTED
SHEET	P79